
 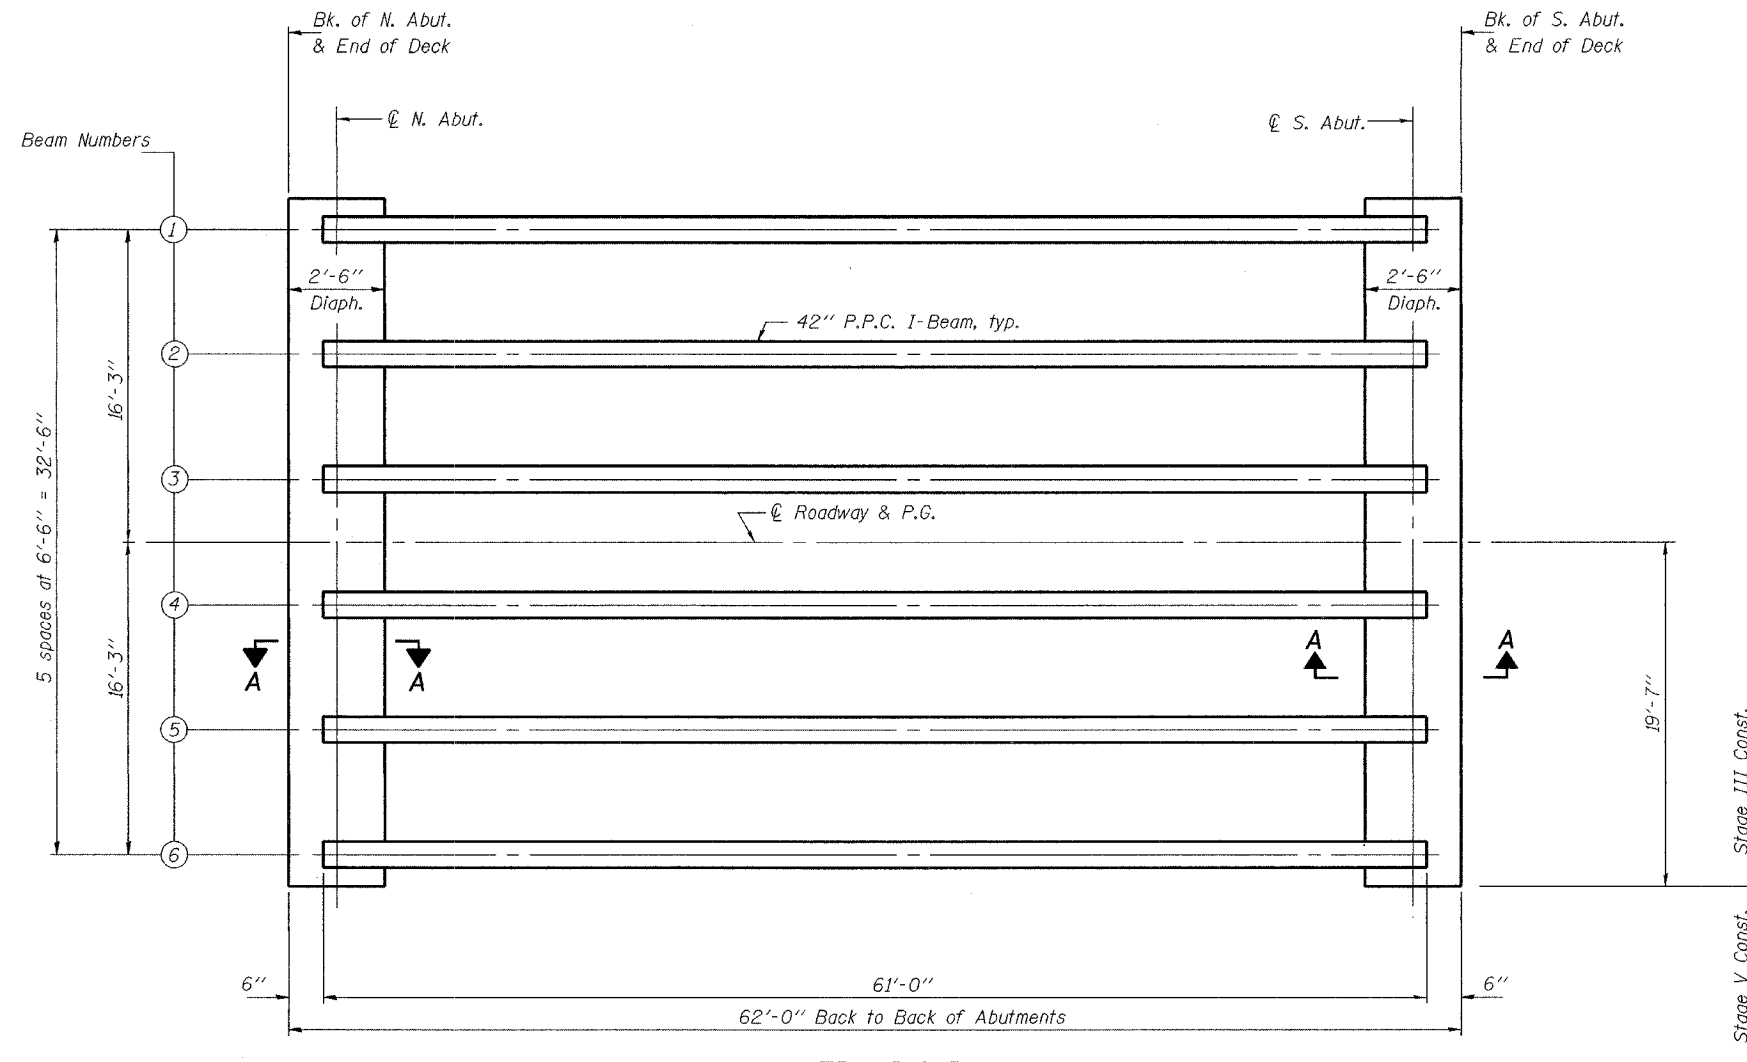


STATE OF ILLINOIS
DEPARTMENT OF TRANSPORTATION

ROUTE NO.	SECTION	COUNTY	TOTAL SHEETS	SHEET NO.	SHEET NO. 8 13 SHEETS
FAP 315	18B-1	FULTON		211	
FED. ROAD DIST. NO. 7	ILLINOIS	FED. AID PROJECT			

Contract #88753



FRAMING PLAN

Note: For Section A-A see sheet 7 of 13.

DESIGNED	Stephen M. Ryan
CHECKED	Sital J. Bhakta
DRAWN	R. Doty OMC
CHECKED	SMR/SJB

EXAMINED	Thomas J. Damagala ENGINEER OF BRIDGE DESIGN	April 11, 2005
PASSED	Ralph E. Anderson ENGINEER OF BRIDGES AND STRUCTURES	

FRAMING PLAN
F.A.P. RT. 315 SEC. 18B-1
FULTON COUNTY
STATION 84+17.00
STRUCTURE NO. 029-0060