
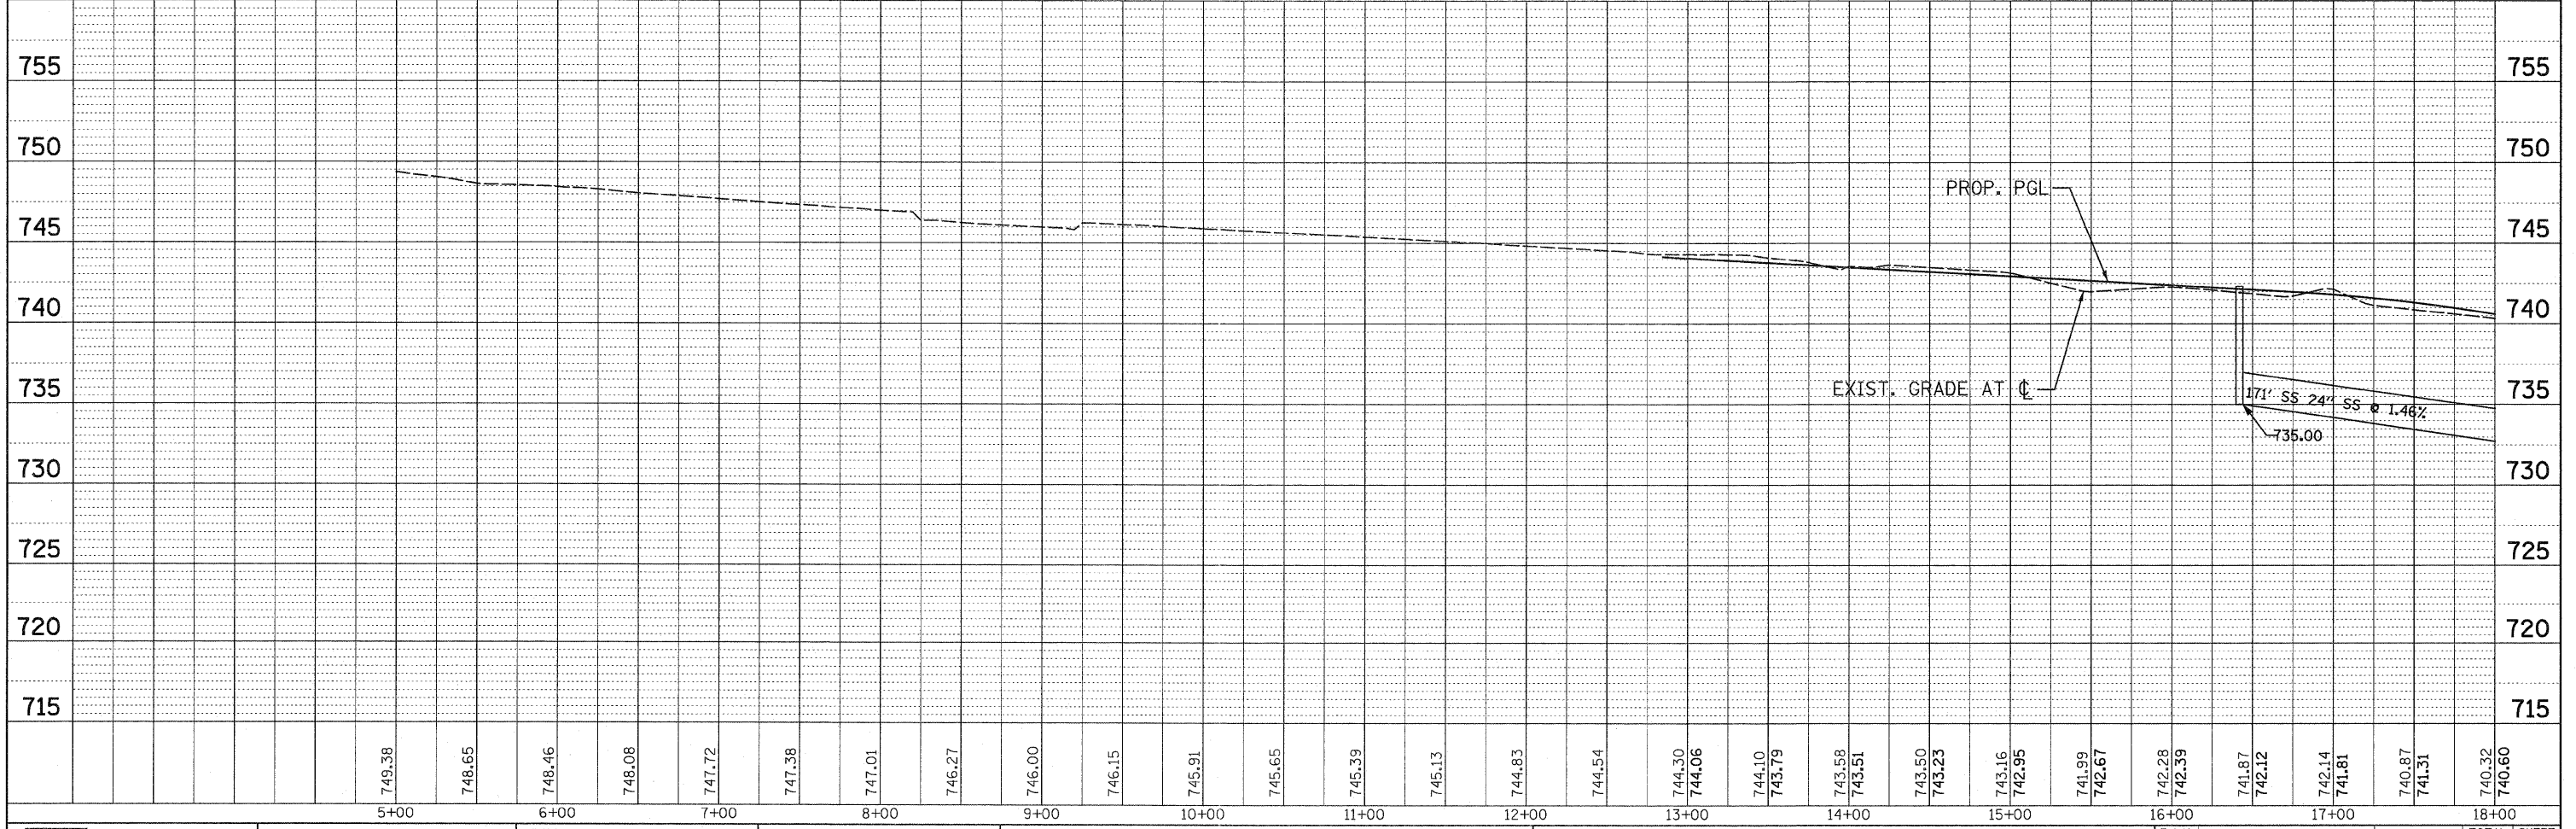


| | | |
|------|----------|------|
| PLAN | SURVEYED | DATE |
| | ALIGNED | |
| | NOTED | |
| | BY | |
| | NO. | |

| | | |
|---------|----------------|------|
| PROFILE | SURVEYED | DATE |
| | GRADES CHECKED | |
| | BY | |
| | NO. | |

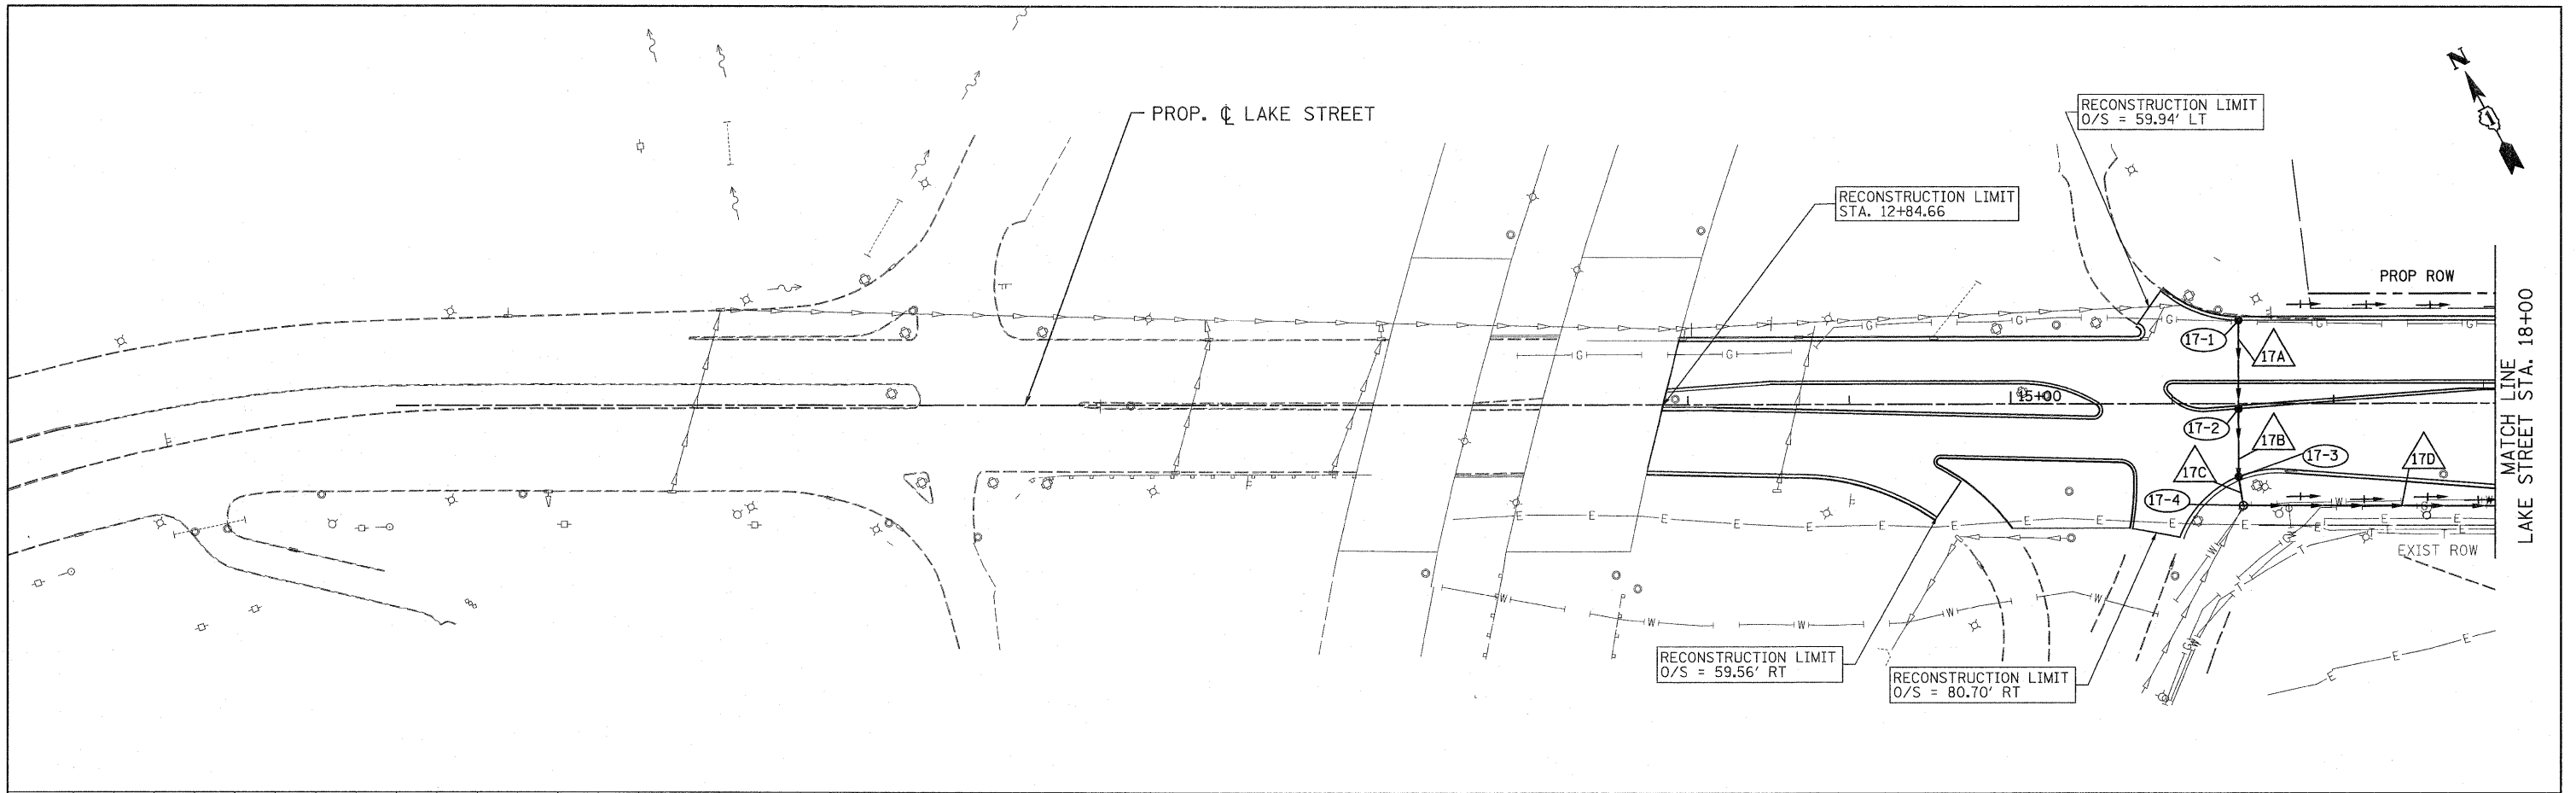

| | | | | | | | | |
|--|--|--|--|--|--|--|---|--------------------|
| PATRICK ENGINEERING INC. 4970 VARSITY DRIVE LISLE, IL 60532 patrickengineering.com | USER NAME = ddoerfler(Rdwy,Lisle) PLOT CONFIG = PDF(Grey, Large).plt PLOT SCALE = 1:50 PLOT DATE = 3/10/2011 2:38:29 PM | DESIGNED - D.DOERFLER DRAWN - D.DOERFLER CHECKED - A.JAMES DATE - 3/11/2011 | REVISED - REVISED - REVISED - REVISED - | | LAKE STREET DRAINAGE AND UTILITIES PLAN AND PROFILE | | F.A.U. RTE. 2578 SECTION 532B COUNTY TOTAL SHEETS 781 SHEET NO. 280 | CONTRACT NO. 60477 |
| | SCALE: 1"=50' SHEET NO. DRA-25 OF 36 STA. 5+00 TO STA. 18+00 | | | | FED. ROAD DIST. NO. ILLINOIS FED. AID PROJECT | | | |

q:\dot\9356_e0_1153\drawings\cadd sheets\019139797-ahd-drain_280.dgn