
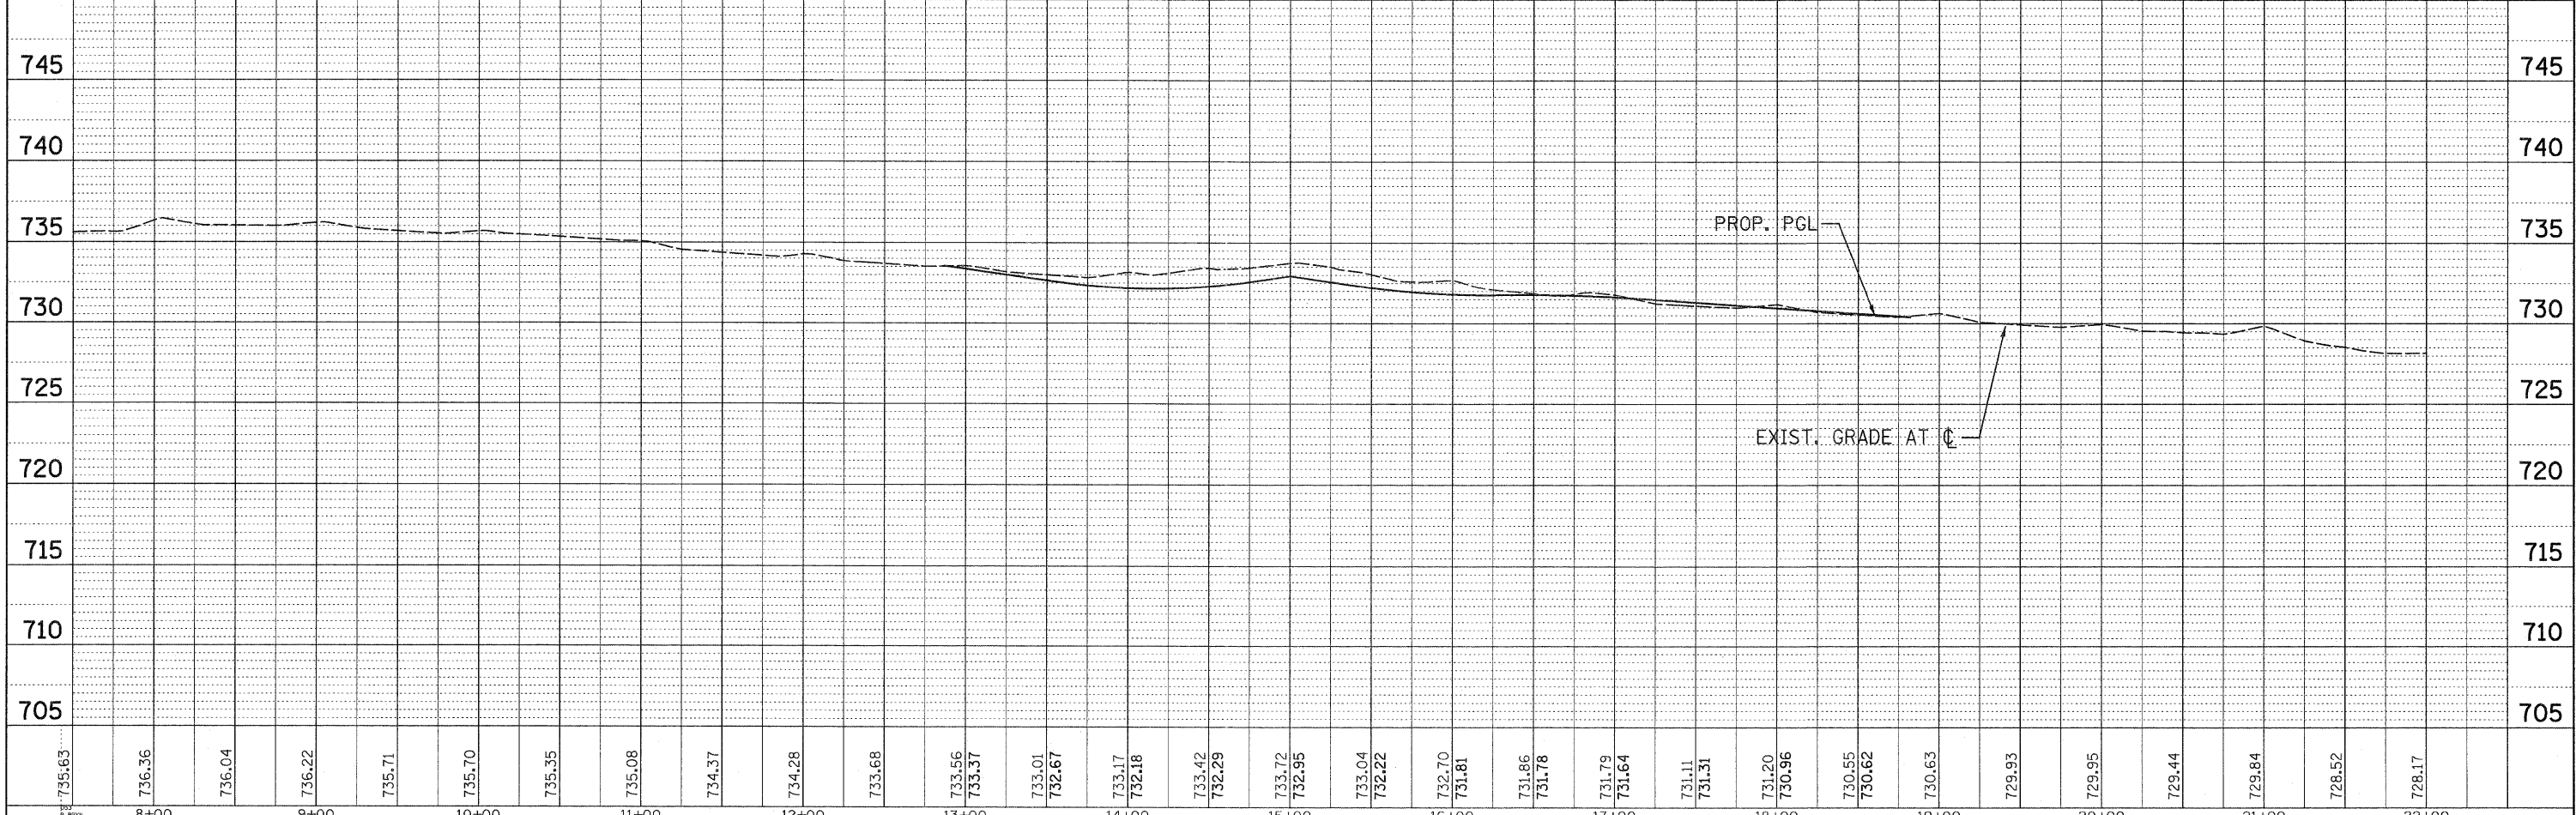


PLAN	SURVEYED	DATE
	NOTE BOOK	BY
	NO.	
	ALIGNED CHECKED	
	RT. OF WAY CHECKED	
	PAID FILE NAME	

PROFILE	SURVEYED	DATE
	GRADES CHECKED	BY
	B.M. NOTED	
	STRUCTURE NOTATIONS CHKD	
	NOTE BOOK	
	NO.	

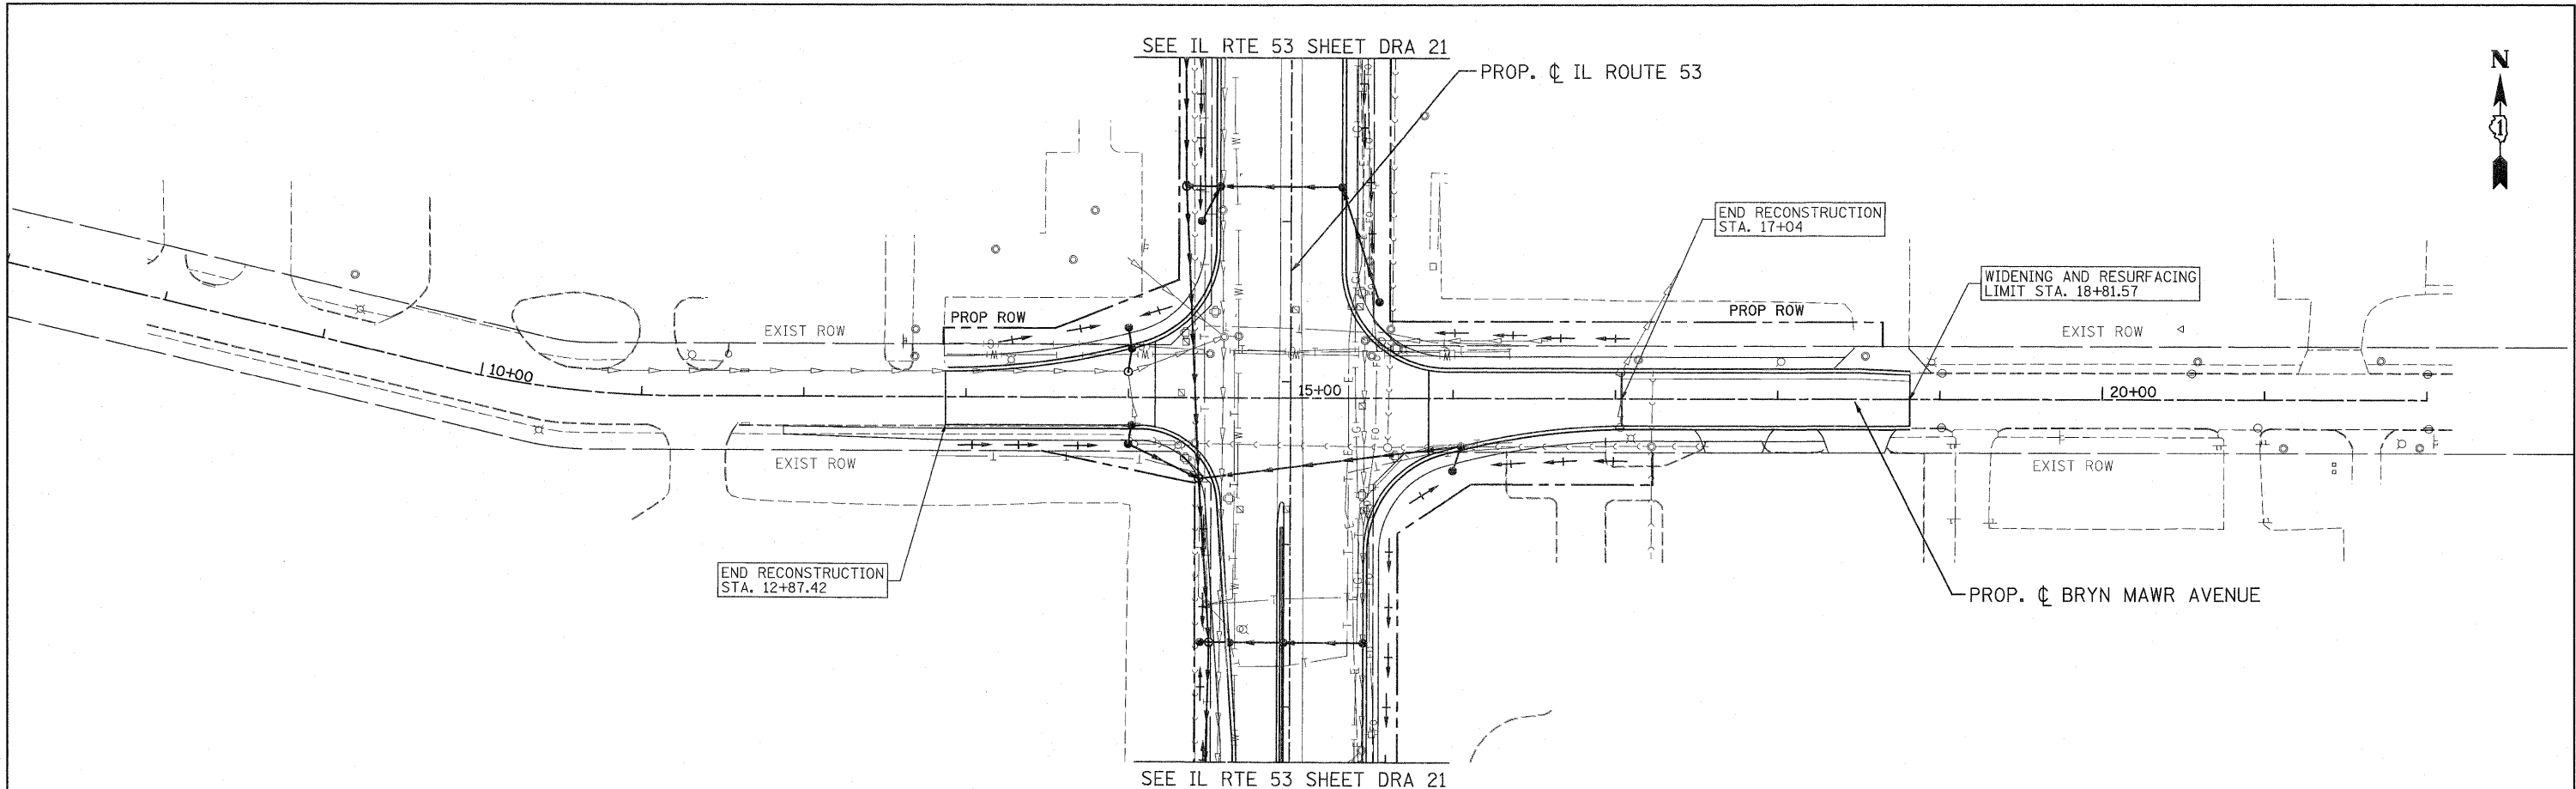

PATRICK ENGINEERING INC. 4870 VARSITY DRIVE LISLE, IL 60532 patrickengineering.com	USER NAME = ddoerfler(Rowj.Lisle) PLOT CONFIG = PDF(Grey_Large).plt PLOT SCALE = 1:50 PLOT DATE = 3/18/2011 2:39:38 PM	DESIGNED - D.DOERFLER DRAWN - D.DOERFLER CHECKED - A.JAMES DATE - 12/3/2010	REVISED - REVISED - REVISED - REVISED -	Illinois Department of Transportation	BRYN MAWR AVENUE DRAINAGE AND UTILITIES PLAN AND PROFILE		F.A.U. RTE. 2578 SECTION 532B COUNTY DUPAGE TOTAL SHEETS 781 SHEET NO. 285	CONTRACT NO. 60477
	SCALE: 1"=50' SHEET NO. DRA-30 OF 36 STA. 11+00 TO STA. 19+45				FED. ROAD DIST. NO. ILLINOIS FED. AID PROJECT			

q:\dot\9356_e0.1153\drawings\cadd sheets\019139797-shd-dra-285.dgn