
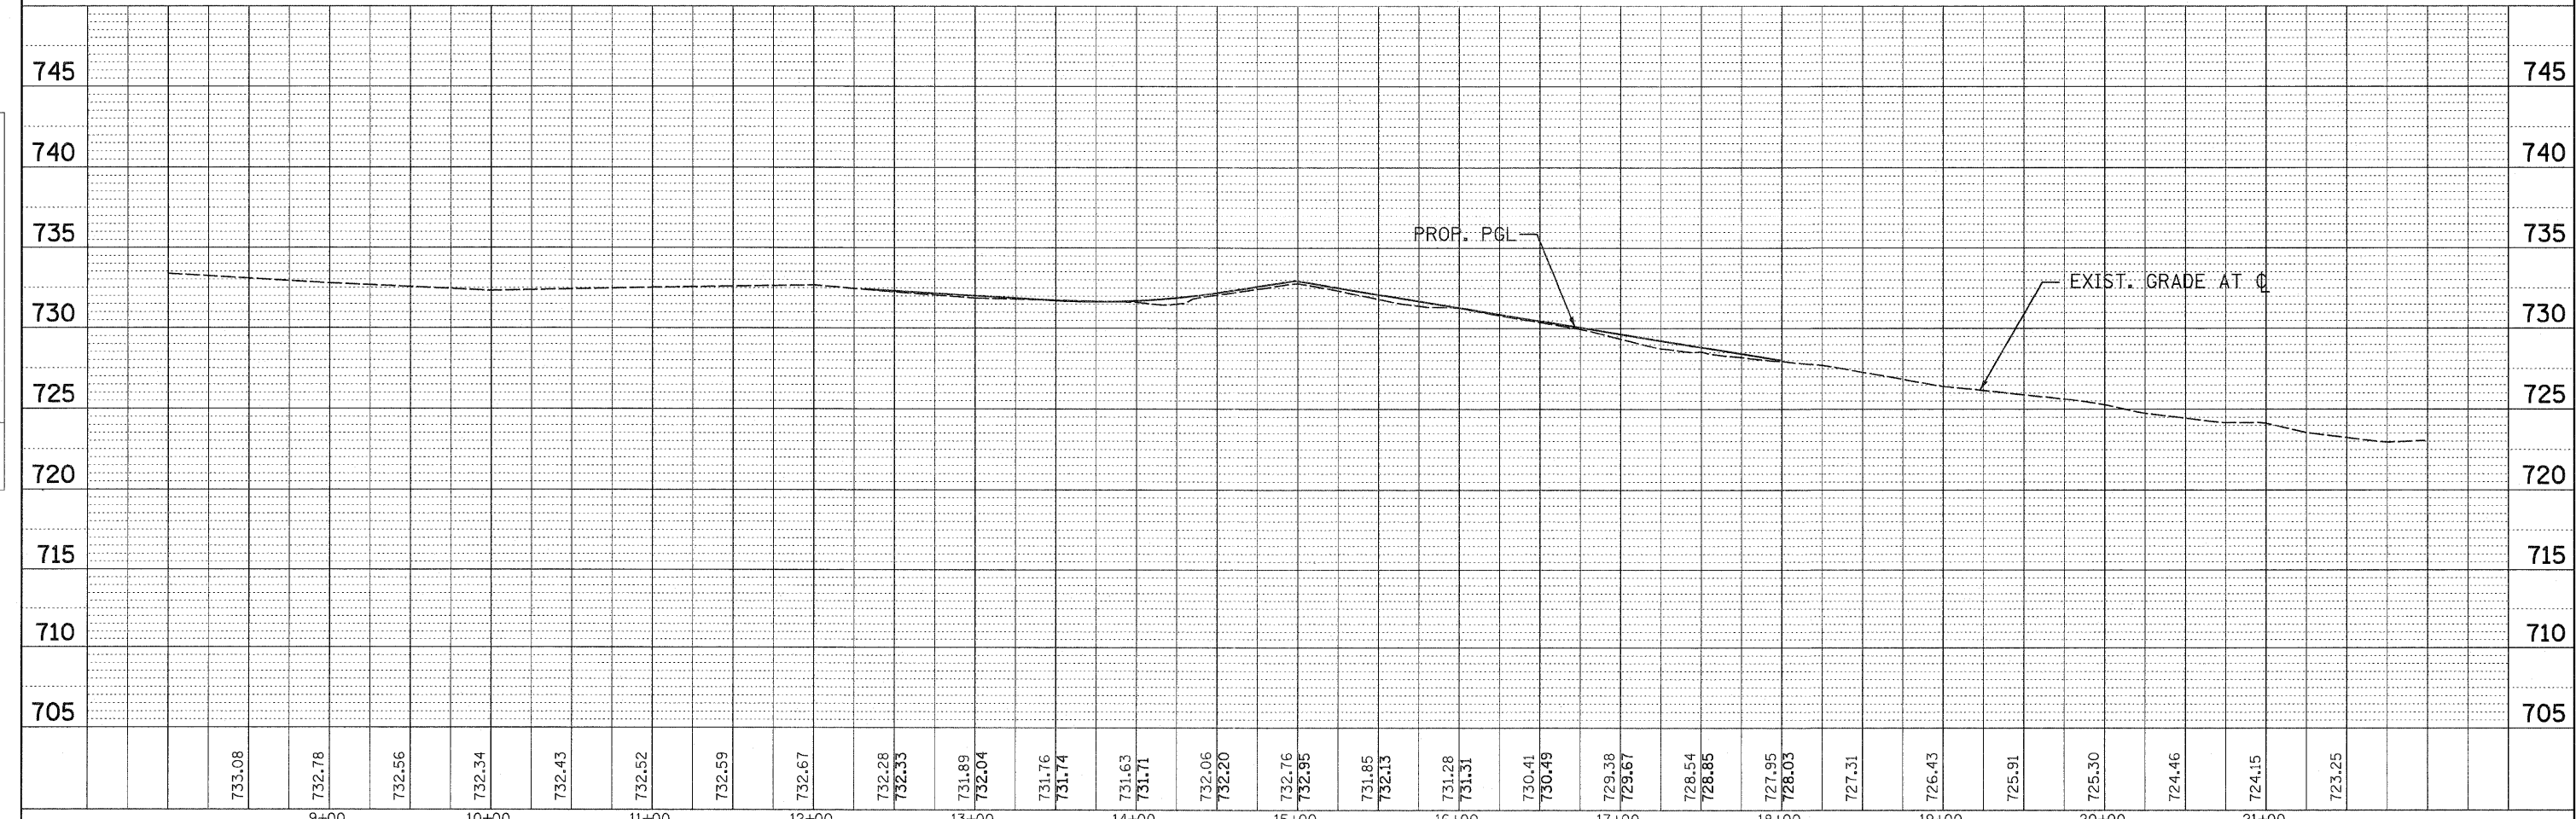


PLAN	SURVEYED	BY	DATE
	ALIGNED		
	NOTED		
	NO.		

PROFILE	SURVEYED	BY	DATE
	GRADES		
	NOTED		
	NO.		

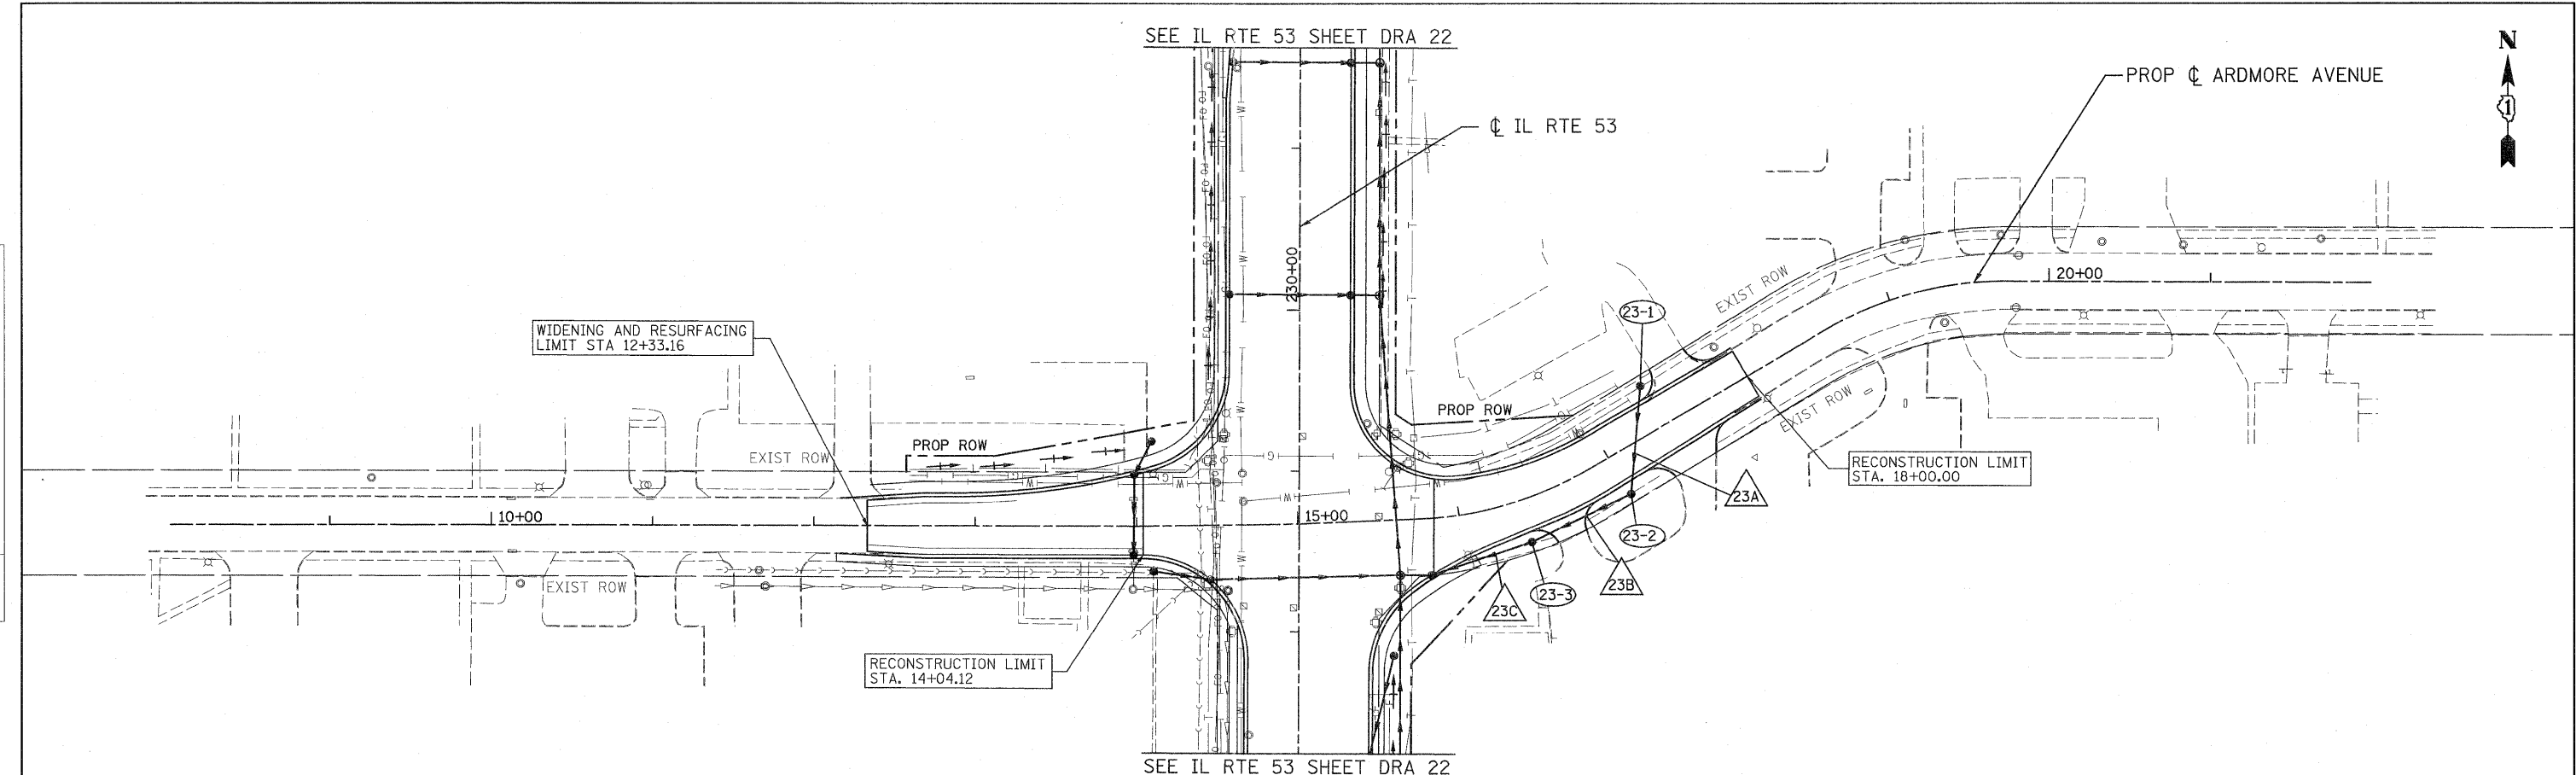

<b>PATRICK ENGINEERING INC.</b> 4870 VARSITY DRIVE LISLE, IL 60532 patrickengineering.com	USER NAME = ddoerfler(Rdwj.Lisle) PLOT CONFIG = PDF(Grey_Large).plt PLOT SCALE = 1:50 PLOT DATE = 3/10/2011 2:39:51 PM	DESIGNED - D.DOERFLER DRAWN - D.DOERFLER CHECKED - A.JAMES DATE - 12/3/2010	REVISED - REVISED - REVISED - REVISED -	Illinois Department of Transportation	<b>ARDMORE AVENUE          DRAINAGE AND UTILITIES PLAN AND PROFILE</b>		F.A.U. RTE. = 2578 SECTION = 532B COUNTY = DUPAGE ILLINOIS FED. AID PROJECT	TOTAL SHEETS = 781 SHEET NO. = 286 CONTRACT NO. = 60477
	SCALE: 1"=50'    SHEET NO. DRA-31 OF 36    STA. 11+50.00 TO STA. 17+81.53		FED. ROAD DIST. NO.					

q:\dot\9356\_e0\_4153\drawings\cadd sheets\019139747-shd-drain\_286.dgn