
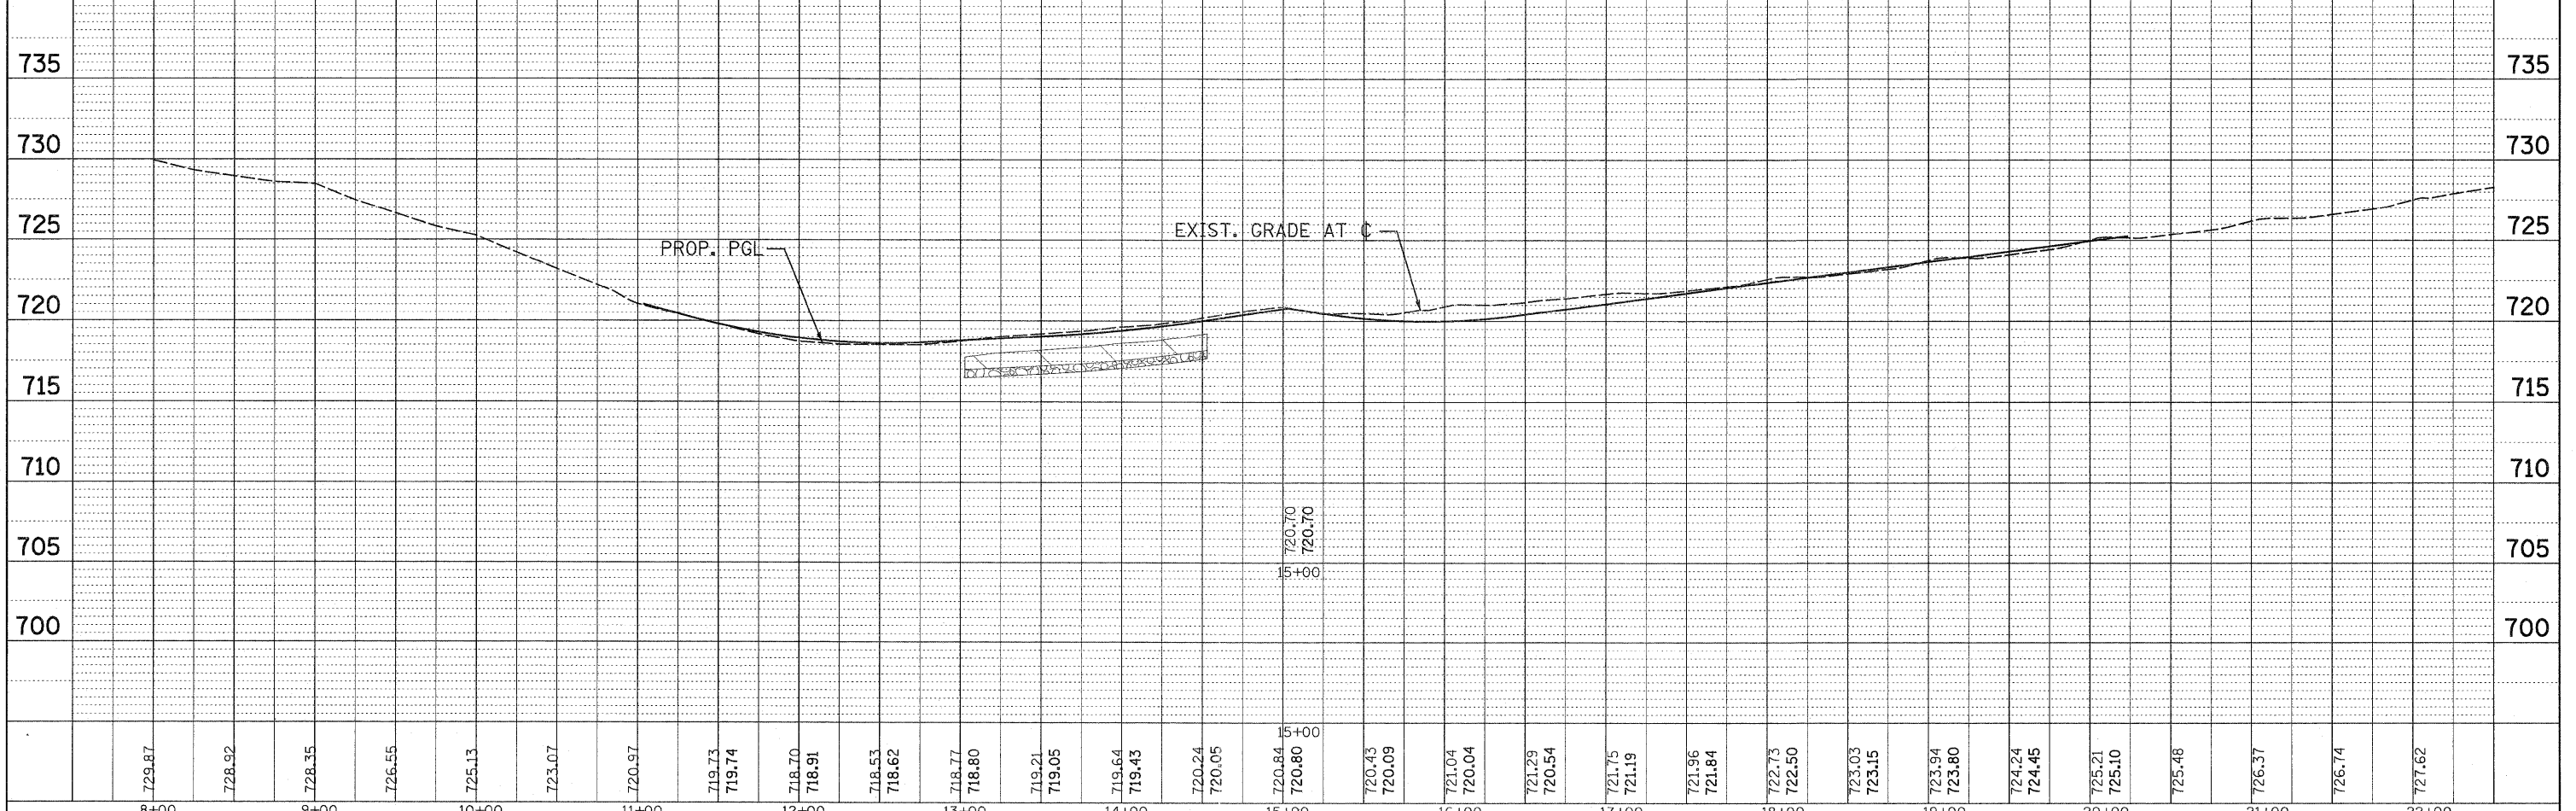


PLAN SURVEYED BY DATE
 ALIGNMENT CHECKED
 RT. OF WAY CHECKED
 NOTE BOOK NO. DDD FILE NAME

PROFILE SURVEYED BY DATE
 GRADES CHECKED
 B.M. NOTED
 STRUCTURE NOTATIONS OK'D
 NOTE BOOK NO.

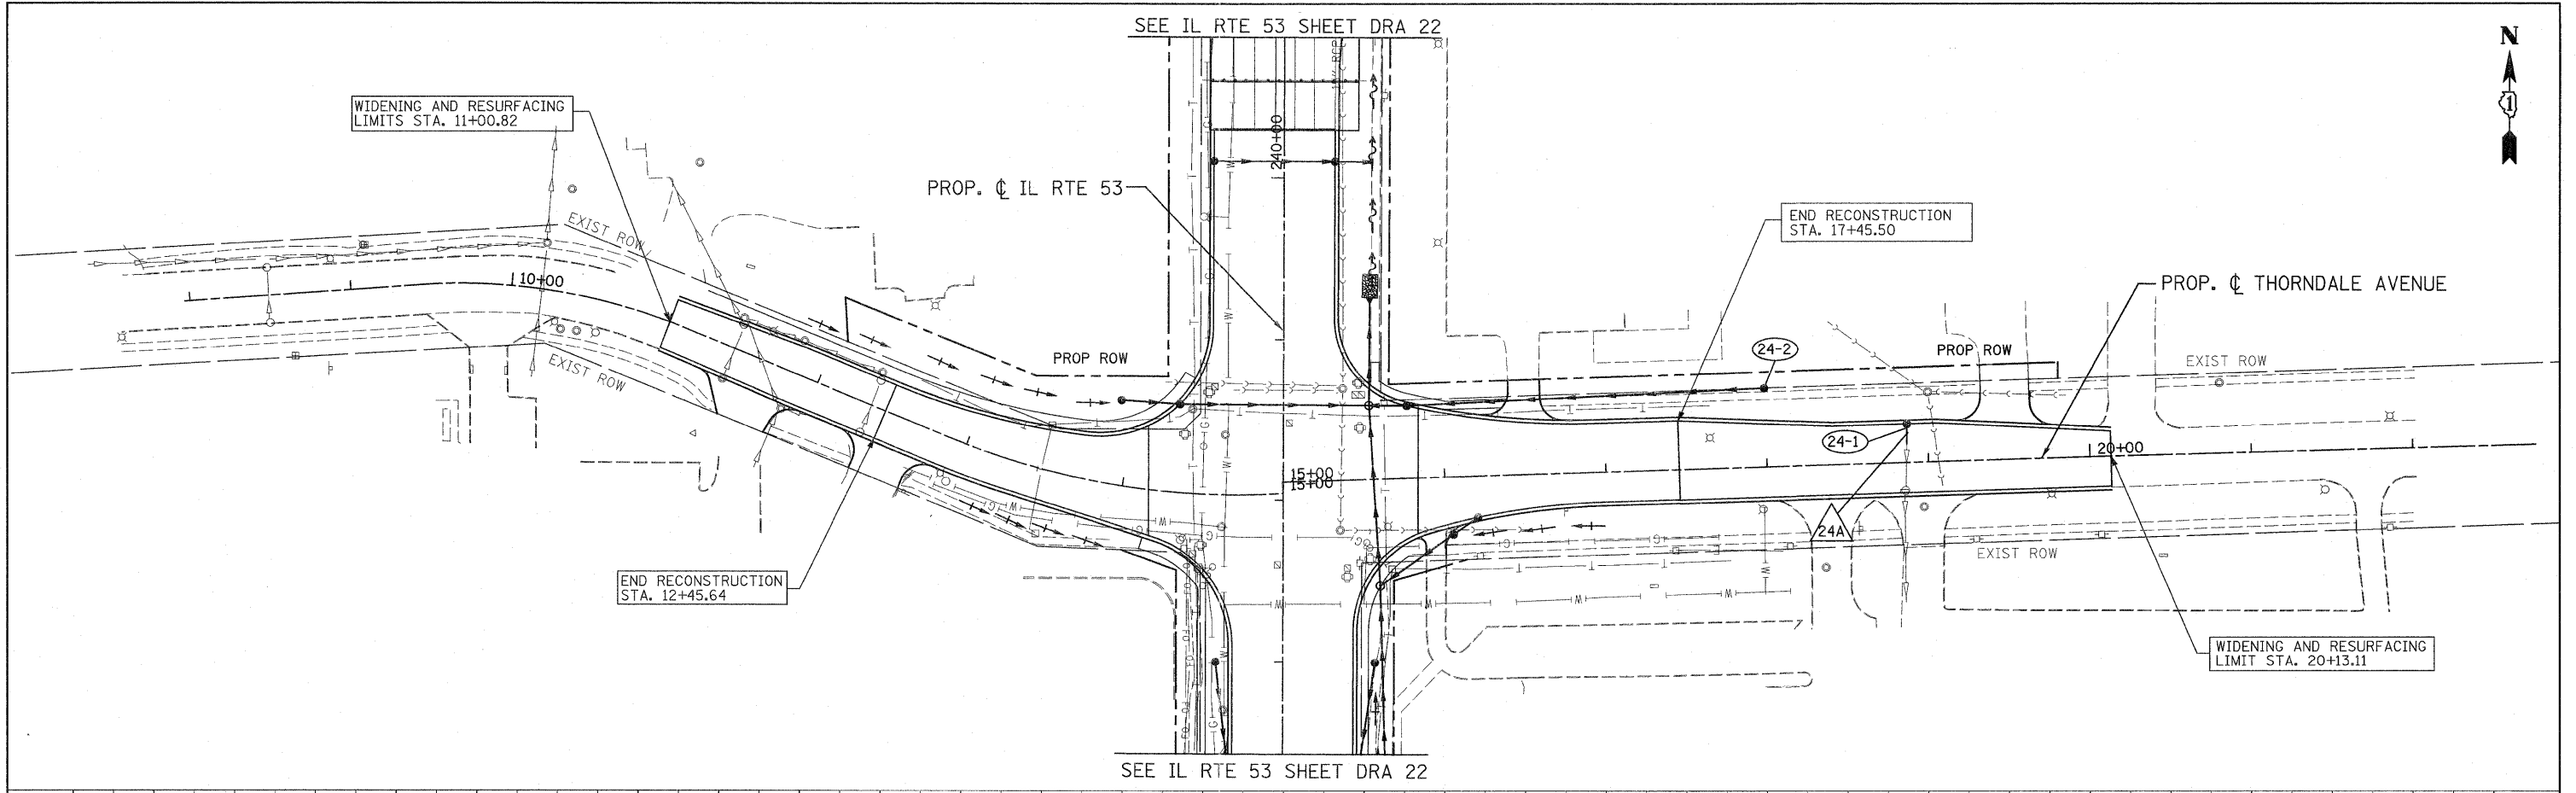

PATRICK ENGINEERING INC. 4970 VARSITY DRIVE LISLE, IL 60532 patrickengineering.com	USER NAME = ddoerfler(Rdwj.Lisla) PLOT CONFIG = PDF(Grey_Large).plt PLOT SCALE = 1:50 PLOT DATE = 3/10/2011 2:40:04 PM	DESIGNED - D.DOERFLER DRAWN - D.DOERFLER CHECKED - A.JAMES DATE - 12/3/2010	REVISED - REVISED - REVISED - REVISED -		THORNDALE AVENUE DRAINAGE AND UTILITIES PLAN AND PROFILE		F.A.U. RTE. 2578 SECTION 532B COUNTY DUPAGE ILLINOIS FED. AID PROJECT	TOTAL SHEETS 781 SHEET NO. 287 CONTRACT NO. 60477
	SCALE: 1"=50' SHEET NO. DRA-32 OF 36 STA. 9+50 TO STA. 20+12				FEDERAL ROAD DIST. NO. ILLINOIS FED. AID PROJECT			

q:\dot\9356_e2.l153\drawings\cadd sheets\019139797-shd-draen.287.dgn