
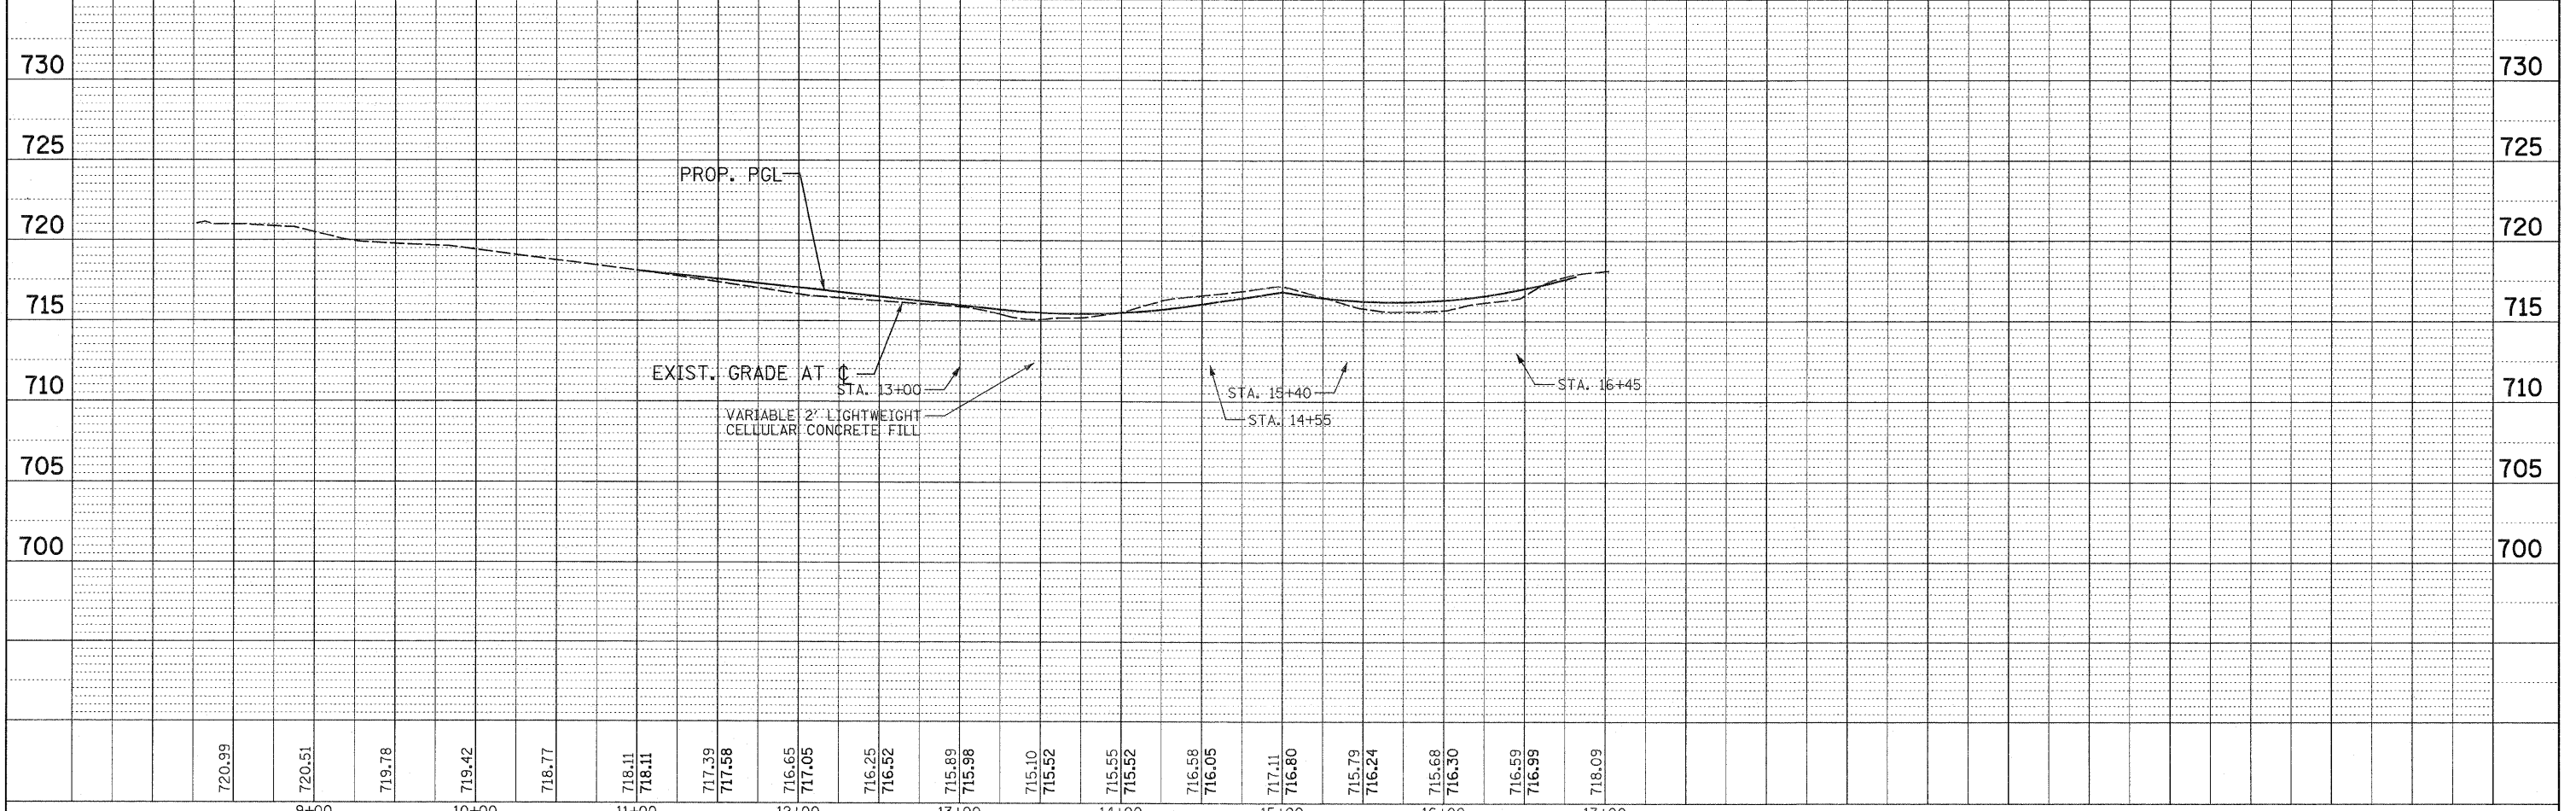


PLAN	SURVEYED	DATE
	ALIGNED	BY
	ALIGNED CHECKED	
	RT. OF WAY CHECKED	
	ADD FILE NAME	
	NO.	

PROFILE	SURVEYED	DATE
	GRADES CHECKED	BY
	B.M. NOTED	
	STRUCTURE NOTATIONS OK'D	
	NO.	

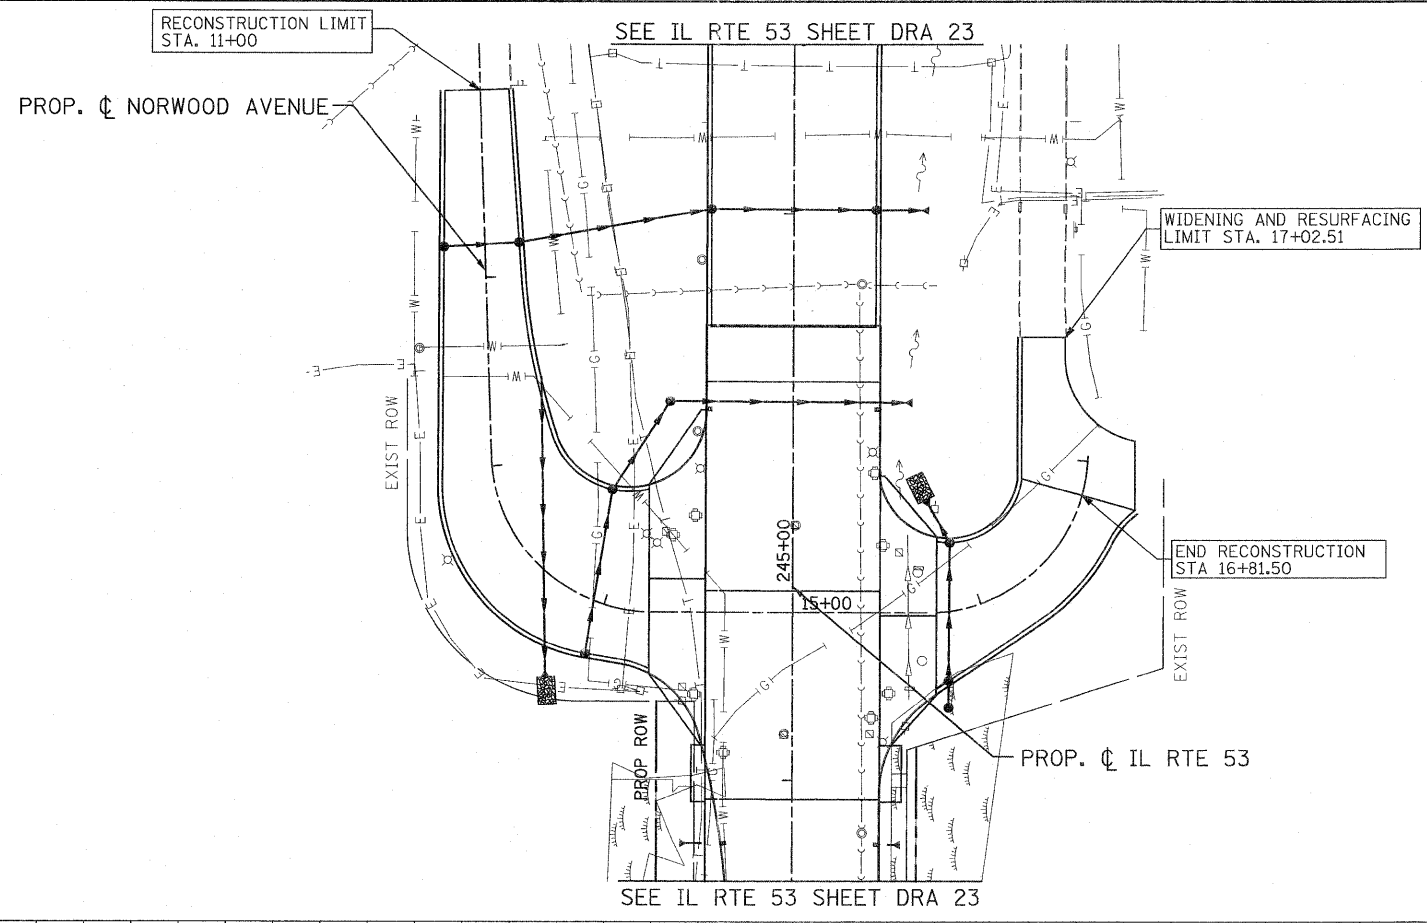

	PATRICK ENGINEERING INC. 4870 VARSITY DRIVE LISLE, IL 60532 patrickengineering.com	USER NAME = ddoerfler(rdwj.Lis1e) PLOT CONFIG = PDF(Grey_Large).plt PLOT SCALE = 1/8"=1'-0" PLOT DATE = 3/18/2011 2:48:16 PM	DESIGNED - D.DOERFLER DRAWN - D.DOERFLER CHECKED - A.JAMES DATE - 12/3/2010	REVISED - REVISED - REVISED - REVISED -		NORWOOD AVENUE DRAINAGE AND UTILITIES PLAN AND PROFILE	F.A.U. RTE. 2578 SECTION 532B COUNTY DUPAGE TOTAL SHEETS 781 SHEET NO. 288 CONTRACT NO. 60477	SCALE: 1"=50' SHEET NO. DRA-33 OF 36 STA. TO STA.	FED. ROAD DIST. NO. ILLINOIS FED. AID PROJECT
--	---	---	--	--	--	---	--	---	--

g:\dot\9356_a0.t153\drawings\cadd sheets\01\39797-ah-dra-288.dgn