
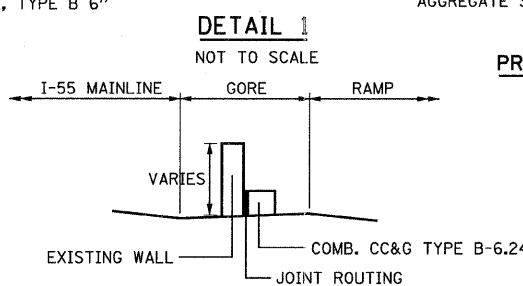
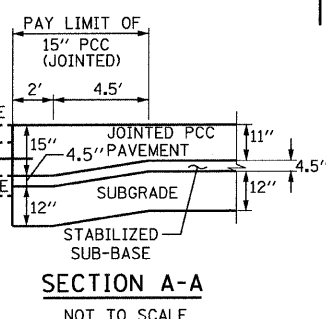
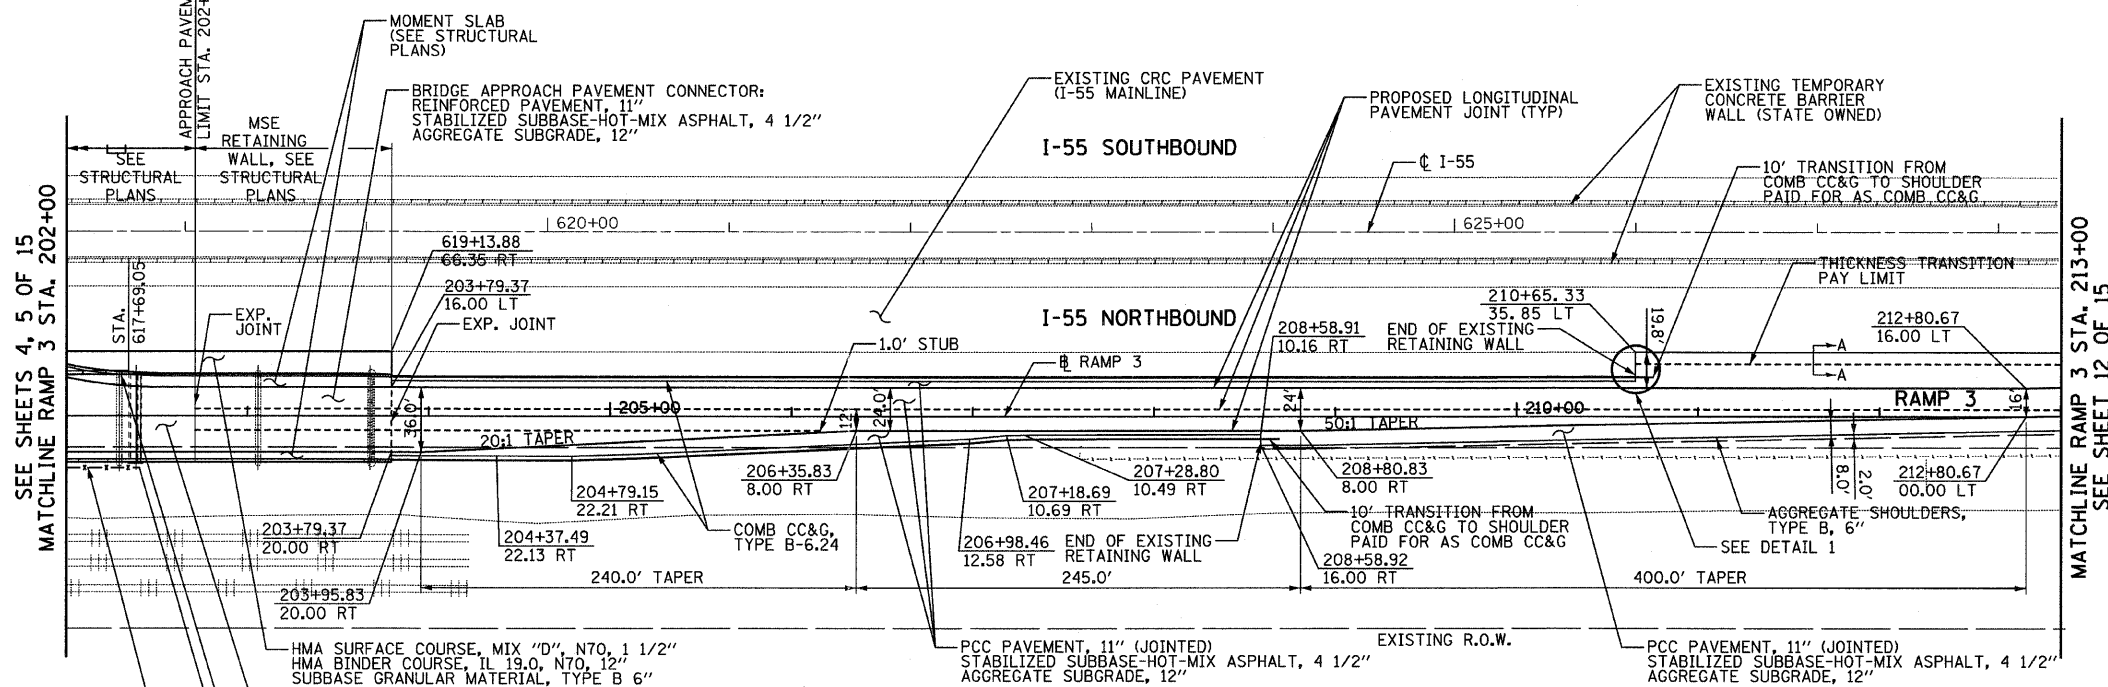


NOTES:

- SEE EXISTING LIGHTING PLAN FOR REMOVAL OF EXISTING LIGHTING UNITS.
- REMOVE SIGN PANEL ASSEMBLY, TYPE A OR TYPE B INCLUDES THE REMOVAL OF THE EXISTING SIGN PANELS.
- CONCRETE BARRIER REMOVAL SHALL INCLUDE ANY ATTACHED APPURTENANCES AND BARRIER BASE.

LEGEND - REMOVAL

 

- APPROACH SLAB REMOVAL
- PAVEMENT REMOVAL
- SIDEWALK REMOVAL, MEDIAN REMOVAL, SHOULDER REMOVAL
- GUARDRAIL REMOVAL, COMB. CC&G REMOVAL
- FENCE REMOVAL
- CONCRETE BARRIER REMOVAL
- TREE REMOVAL (SIZE IN UNITS)
- TREE TRUNK PROTECTION

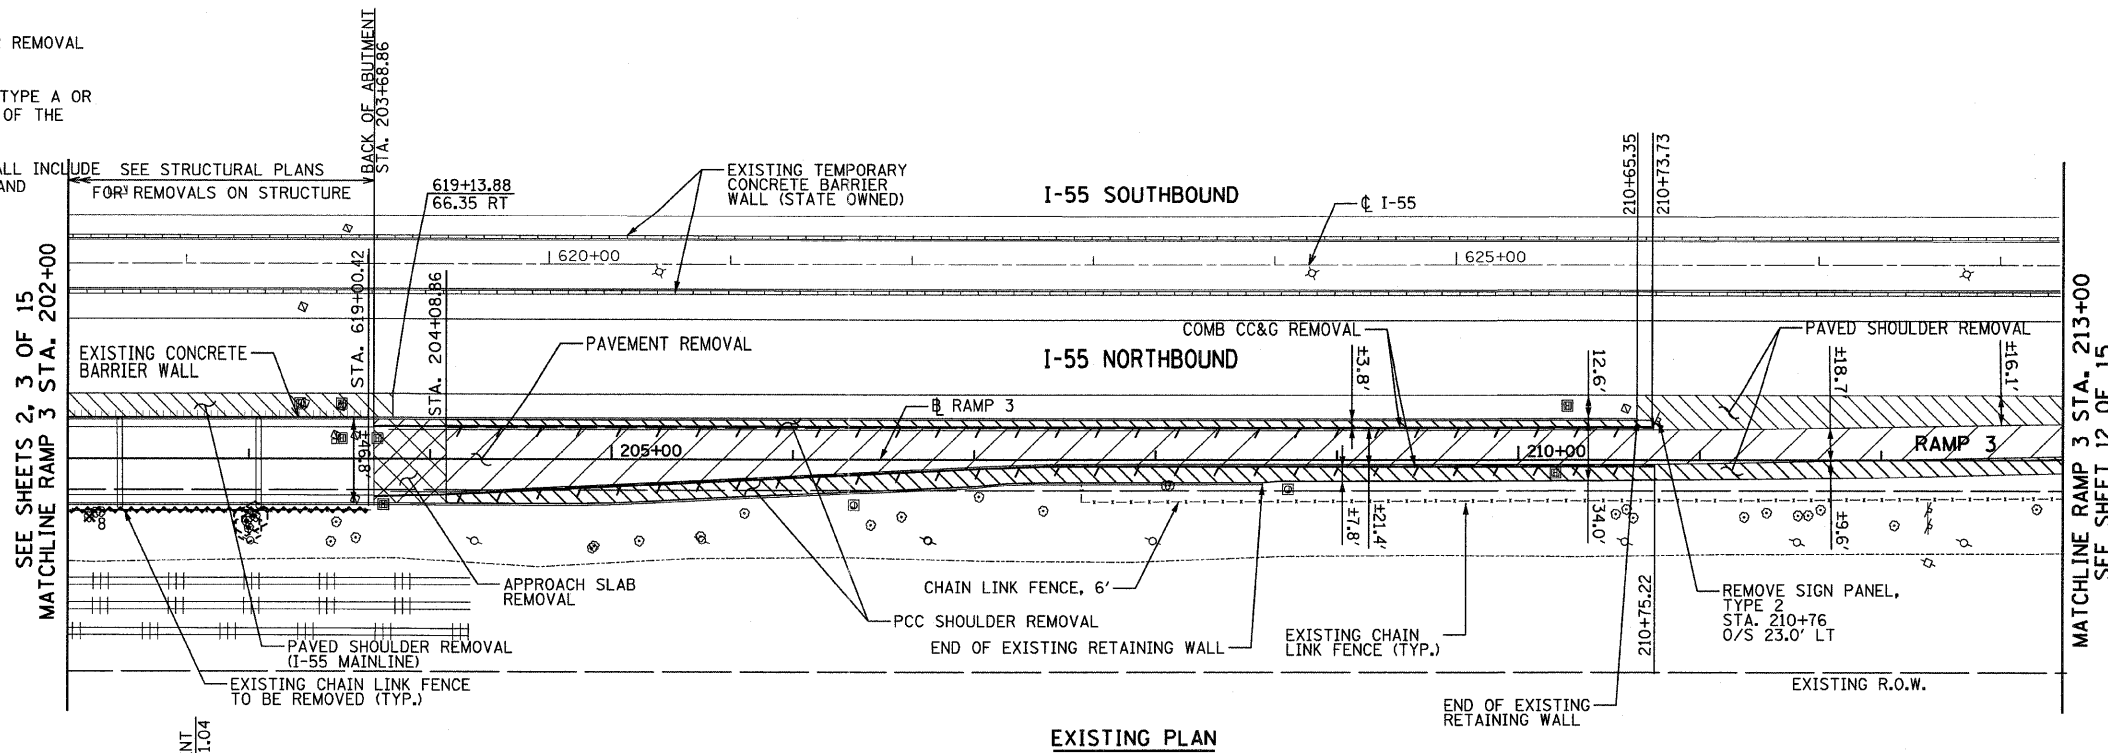

PROPOSED PLAN

NOTES:

- RUMBLE STRIPS SHALL BE PLACED ALONG I-55 PER STANDARD 642001 IN ALL AREAS WHERE THEY ARE REMOVED FOR MAINTENANCE OF TRAFFIC OPERATIONS. THIS WORK SHALL BE PAID FOR AS SHOULDER RUMBLE STRIP.
- DELINEATORS SHALL BE PLACED ALONG THE RAMPS PER STANDARD 635001 EVERY 100 FT.
- BARRIER TO CURB AND GUTTER TRANSITION SHOWN ON STRUCTURAL MSE WALL SHEETS.

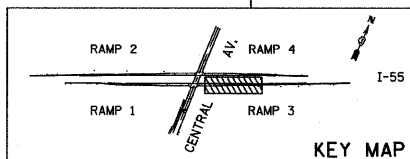

TYLIN INTERNATIONAL USER NAME = #USER# PLOT SCALE = #SCALE# PLOT DATE = 4/28/2011	DESIGNED - AZ	REVISED -	STATE OF ILLINOIS DEPARTMENT OF TRANSPORTATION	CENTRAL AVENUE OVER I-55 EXISTING AND PROPOSED PLAN - I-55 - RAMP 3		F.A.I. R.T.E.	SECTION	COUNTY	TOTAL SHEETS	SHEET NO.
	DRAWN - AZ	REVISED -		I-55	0711.2R & 1011.1BR	COOK	741	116		
	CHECKED - DMJ	REVISED -		CONTRACT NO. 60999						
	DATE - 03/25/2011	REVISED -		FED. ROAD DIST. NO. ILLINOIS FED. AID PROJECT						
STA. 202+00 TO STA. 213+00		SCALE: 1:50	SHEET NO. 11 OF 15 SHEETS	STA. 202+00	TO STA. 213+00					