




- NOTES:**
- SEE EXISTING LIGHTING PLAN FOR REMOVAL OF EXISTING LIGHTING UNITS.
 - REMOVE SIGN PANEL ASSEMBLY, TYPE A OR TYPE B INCLUDES THE REMOVAL OF THE EXISTING SIGN PANELS.

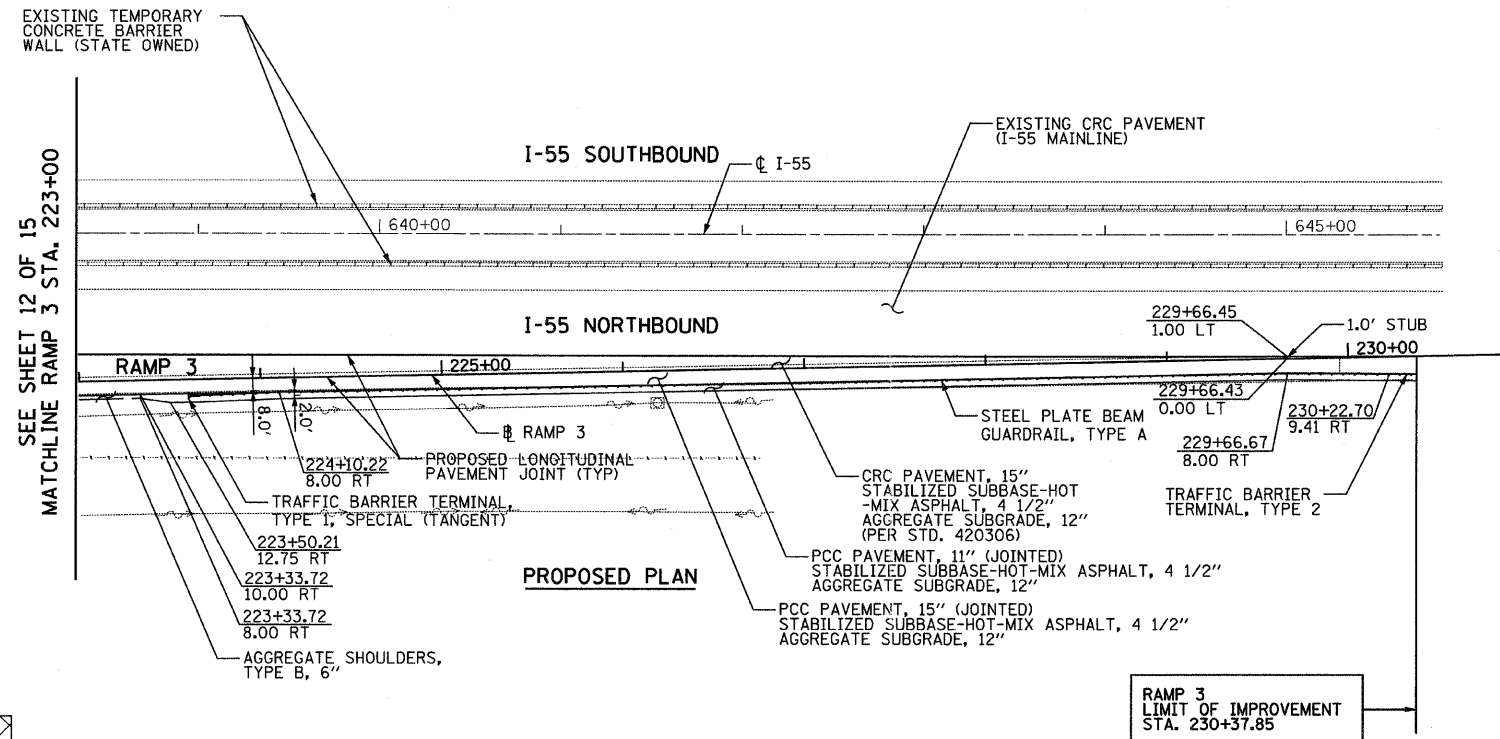

LEGEND - REMOVAL

APPROACH SLAB REMOVAL	
PAVEMENT REMOVAL	
SIDEWALK REMOVAL, MEDIAN REMOVAL, SHOULDER REMOVAL	
GUARDRAIL REMOVAL, COMB. CC&G REMOVAL	
FENCE REMOVAL	
CONCRETE BARRIER REMOVAL	
TREE REMOVAL (SIZE IN UNITS)	
TREE TRUNK PROTECTION	

 - NOTES:**
- RUMBLE STRIPS SHALL BE PLACED ALONG I-55 PER STANDARD 642001 IN ALL AREAS WHERE THEY ARE REMOVED FOR MAINTENANCE OF TRAFFIC OPERATIONS. THIS WORK SHALL BE PAID FOR AS SHOULDER RUMBLE STRIP.
 - DELINEATORS SHALL BE PLACED ALONG THE RAMPS PER STANDARD 635001 EVERY 100 FT.

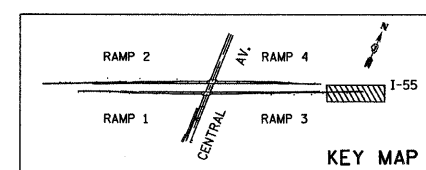

TYLIN INTERNATIONAL	USER NAME = #USER#	DESIGNED - AZ	REVISED -	STATE OF ILLINOIS DEPARTMENT OF TRANSPORTATION	CENTRAL AVENUE OVER I-55 EXISTING AND PROPOSED PLAN - I-55 - RAMP 3			F.A.I. RTE.	SECTION	COUNTY	TOTAL SHEETS	SHEET NO.
	PLOT SCALE = #SCALE#	DRAWN - AZ	REVISED -		I-55	0711.2R & 1011.1BR	COOK	741	118			
	PLOT DATE = 4/28/2011	CHECKED - DMJ	REVISED -		SCALE: 1:50 SHEET NO. 13 OF 15 SHEETS STA. 223+00 TO STA. 230+37.85			CONTRACT NO. 60999				
		DATE - 03/25/2011	REVISED -		FED. ROAD DIST. NO. [ILLINOIS] FED. AID PROJECT							