
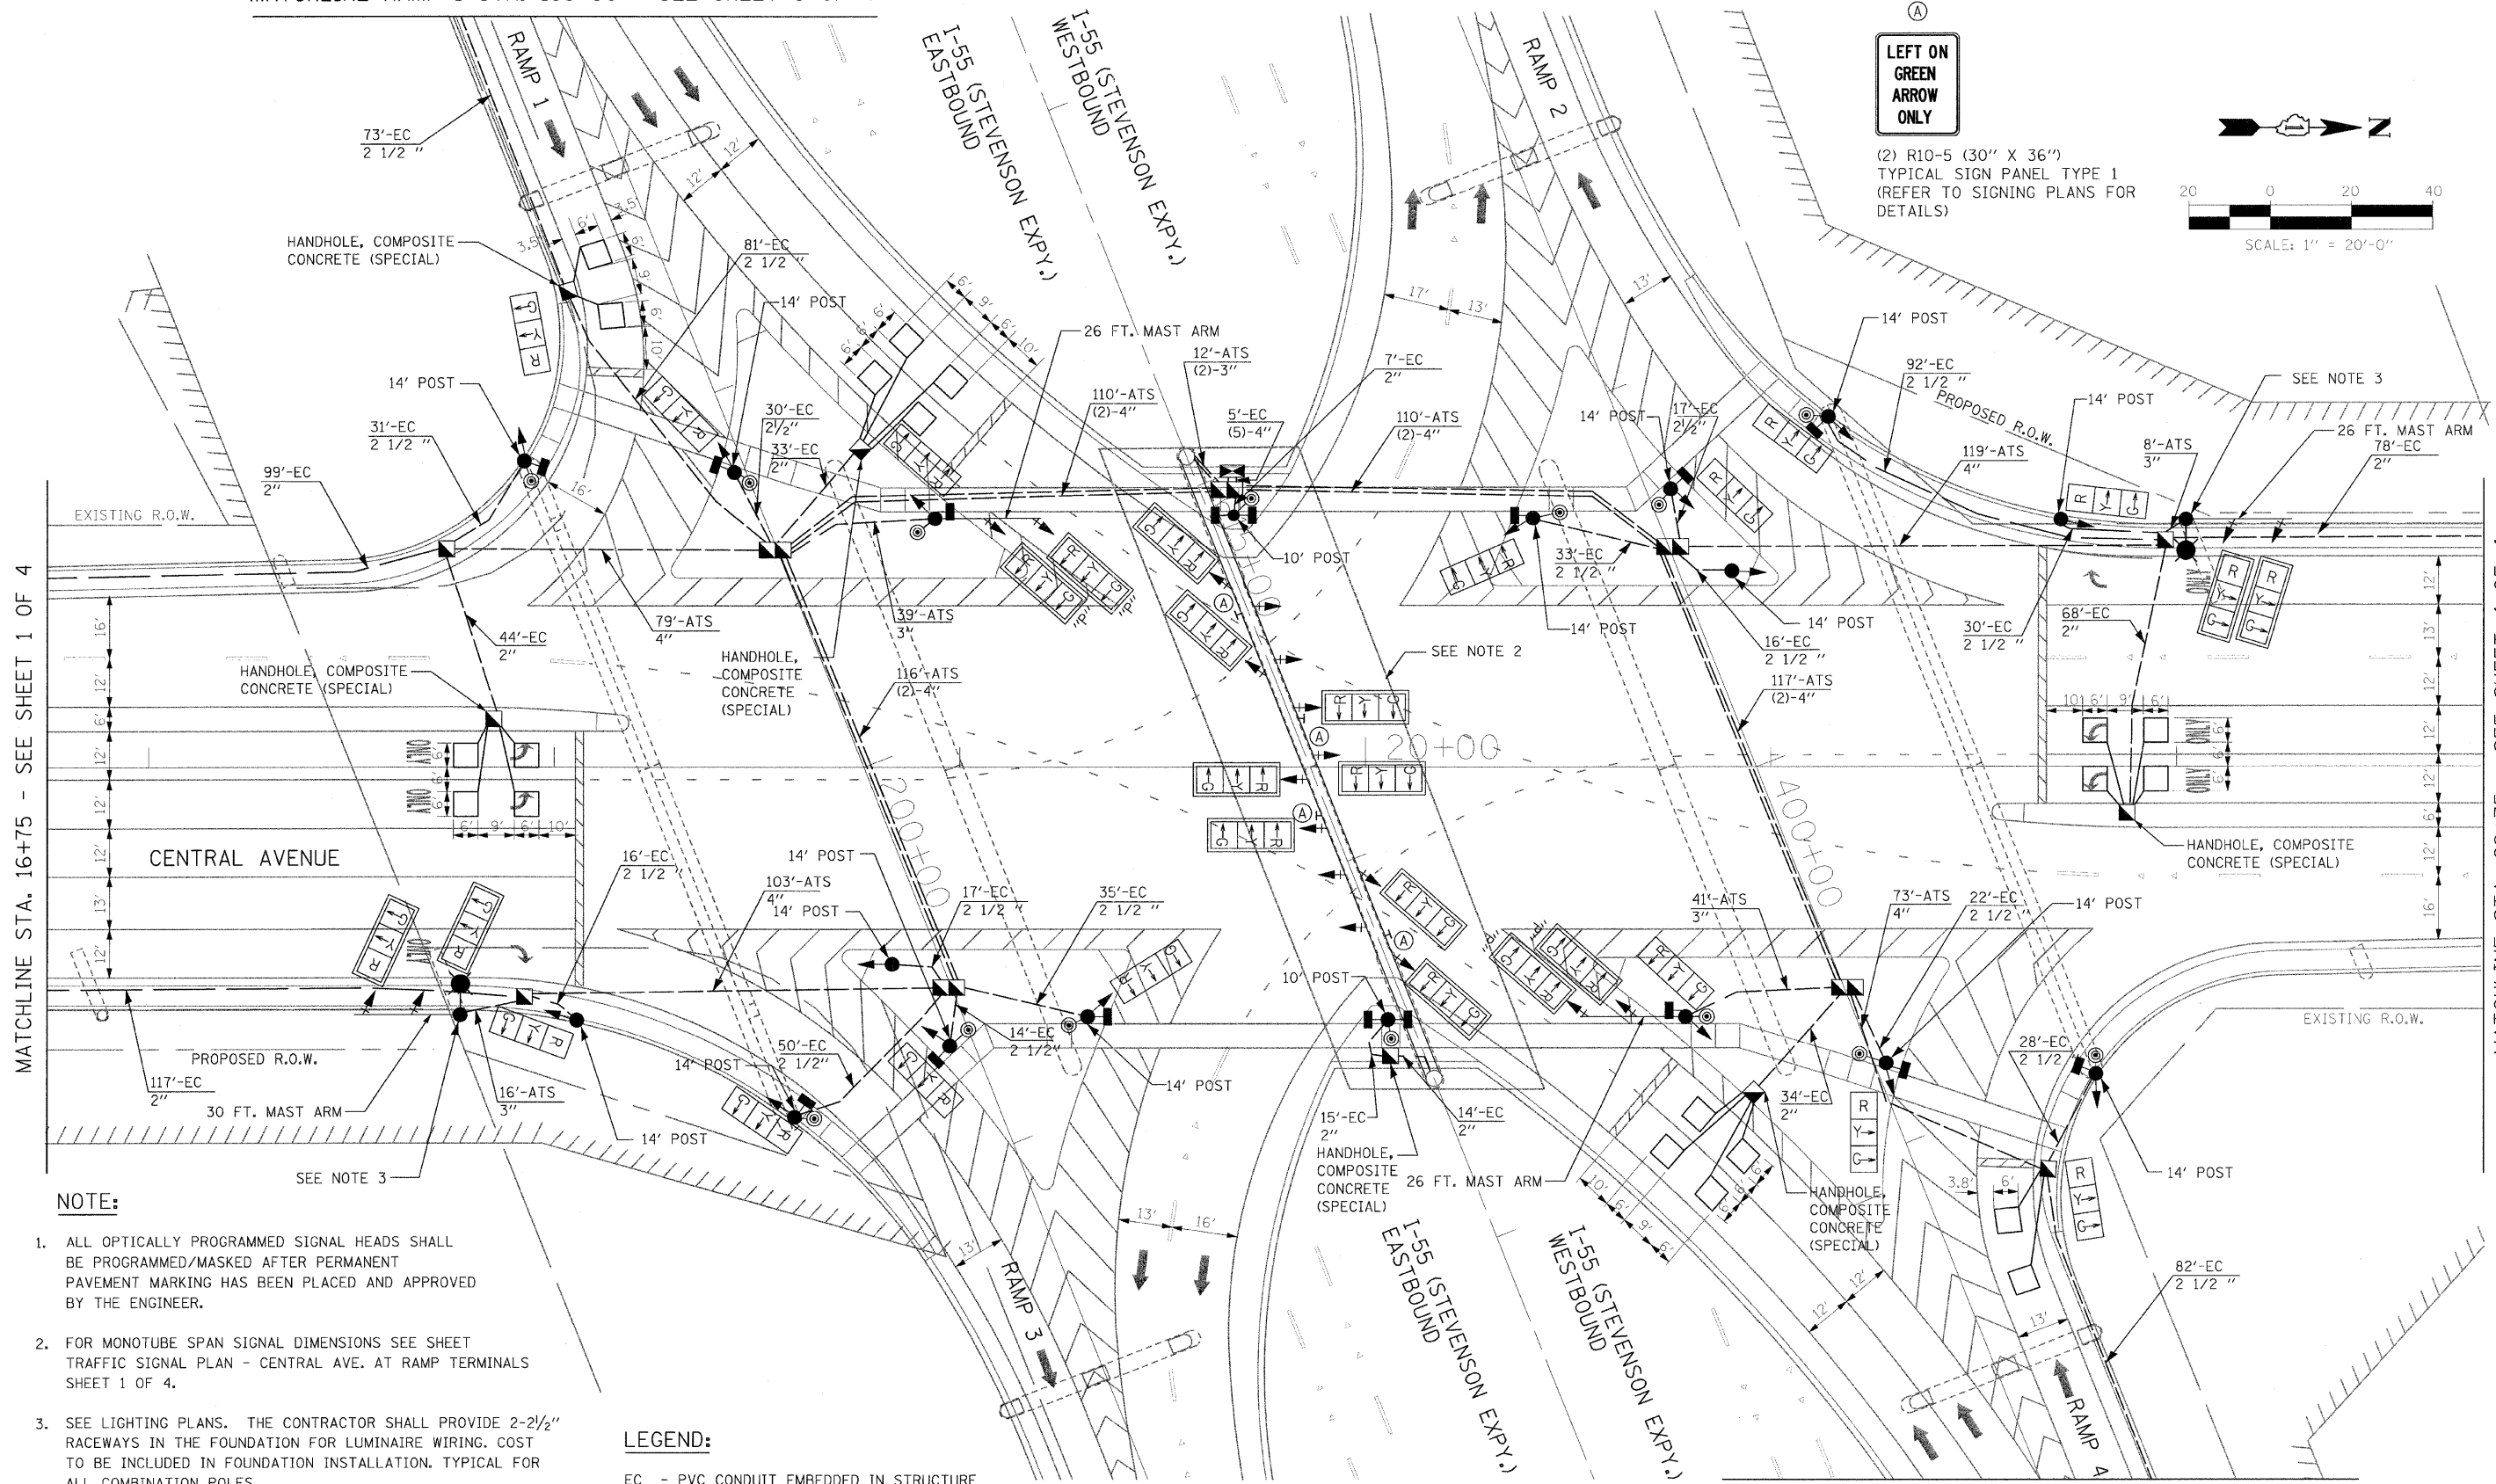


MATCHLINE RAMP 1 STA. 198+00 - SEE SHEET 3 OF 4

(A)  
LEFT ON GREEN  
ARROW  
ONLY

(2) R10-5 (30" X 36")  
TYPICAL SIGN PANEL TYPE 1  
(REFER TO SIGNING PLANS FOR  
DETAILS)

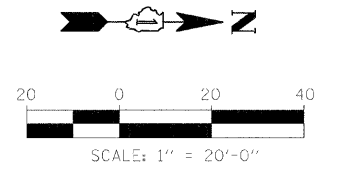

MATCHLINE STA. 16+75 - SEE SHEET 1 OF 4

MATCHLINE STA. 22+75 - SEE SHEET 4 OF 4

**NOTE:**

1. ALL OPTICALLY PROGRAMMED SIGNAL HEADS SHALL BE PROGRAMMED/MASKED AFTER PERMANENT PAVEMENT MARKING HAS BEEN PLACED AND APPROVED BY THE ENGINEER.
2. FOR MONOTUBE SPAN SIGNAL DIMENSIONS SEE SHEET TRAFFIC SIGNAL PLAN - CENTRAL AVE. AT RAMP TERMINALS SHEET 1 OF 4.
3. SEE LIGHTING PLANS. THE CONTRACTOR SHALL PROVIDE 2-2 1/2" RACEWAYS IN THE FOUNDATION FOR LUMINAIRE WIRING. COST TO BE INCLUDED IN FOUNDATION INSTALLATION. TYPICAL FOR ALL COMBINATION POLES.
4. SEE STRUCTURAL PLANS FOR HANDHOLE BLOCKOUT LOCATIONS.

**LEGEND:**

EC - PVC CONDUIT EMBEDDED IN STRUCTURE  
ATS - ATTACHED TO STRUCTURE

MATCHLINE RAMP 4 STA. 402+00 - SEE SHEET 3 OF 4

**SINGH**  
SINGH & ASSOCIATES, INC.  
CONSULTING ENGINEERS

300 W. ADAMS ST.  
CHICAGO, IL 60606  
TEL: (312) 629-0240  
FAX: (312) 629-8449

USER NAME = #USER#  
DESIGNED - PKT  
DRAWN - PKT  
CHECKED - GR  
DATE - 3-25-2011

REVISED -  
REVISED -  
REVISED -  
REVISED -

**STATE OF ILLINOIS  
DEPARTMENT OF TRANSPORTATION**

**CENTRAL AVENUE OVER I-55  
TRAFFIC SIGNAL PLAN - CENTRAL AVENUE AT RAMP TERMINALS**

SCALE: SHEET NO. 2 OF 4 SHEETS STA. TO STA.

F.A. RTE. 55	SECTION 9th, HB & SBIR-1	COUNTY COOK	TOTAL SHEETS 741	SHEET NO. 193
FED. ROAD DIST. NO.		ILLINOIS FED. AID PROJECT		
CONTRACT NO. 60999				