
 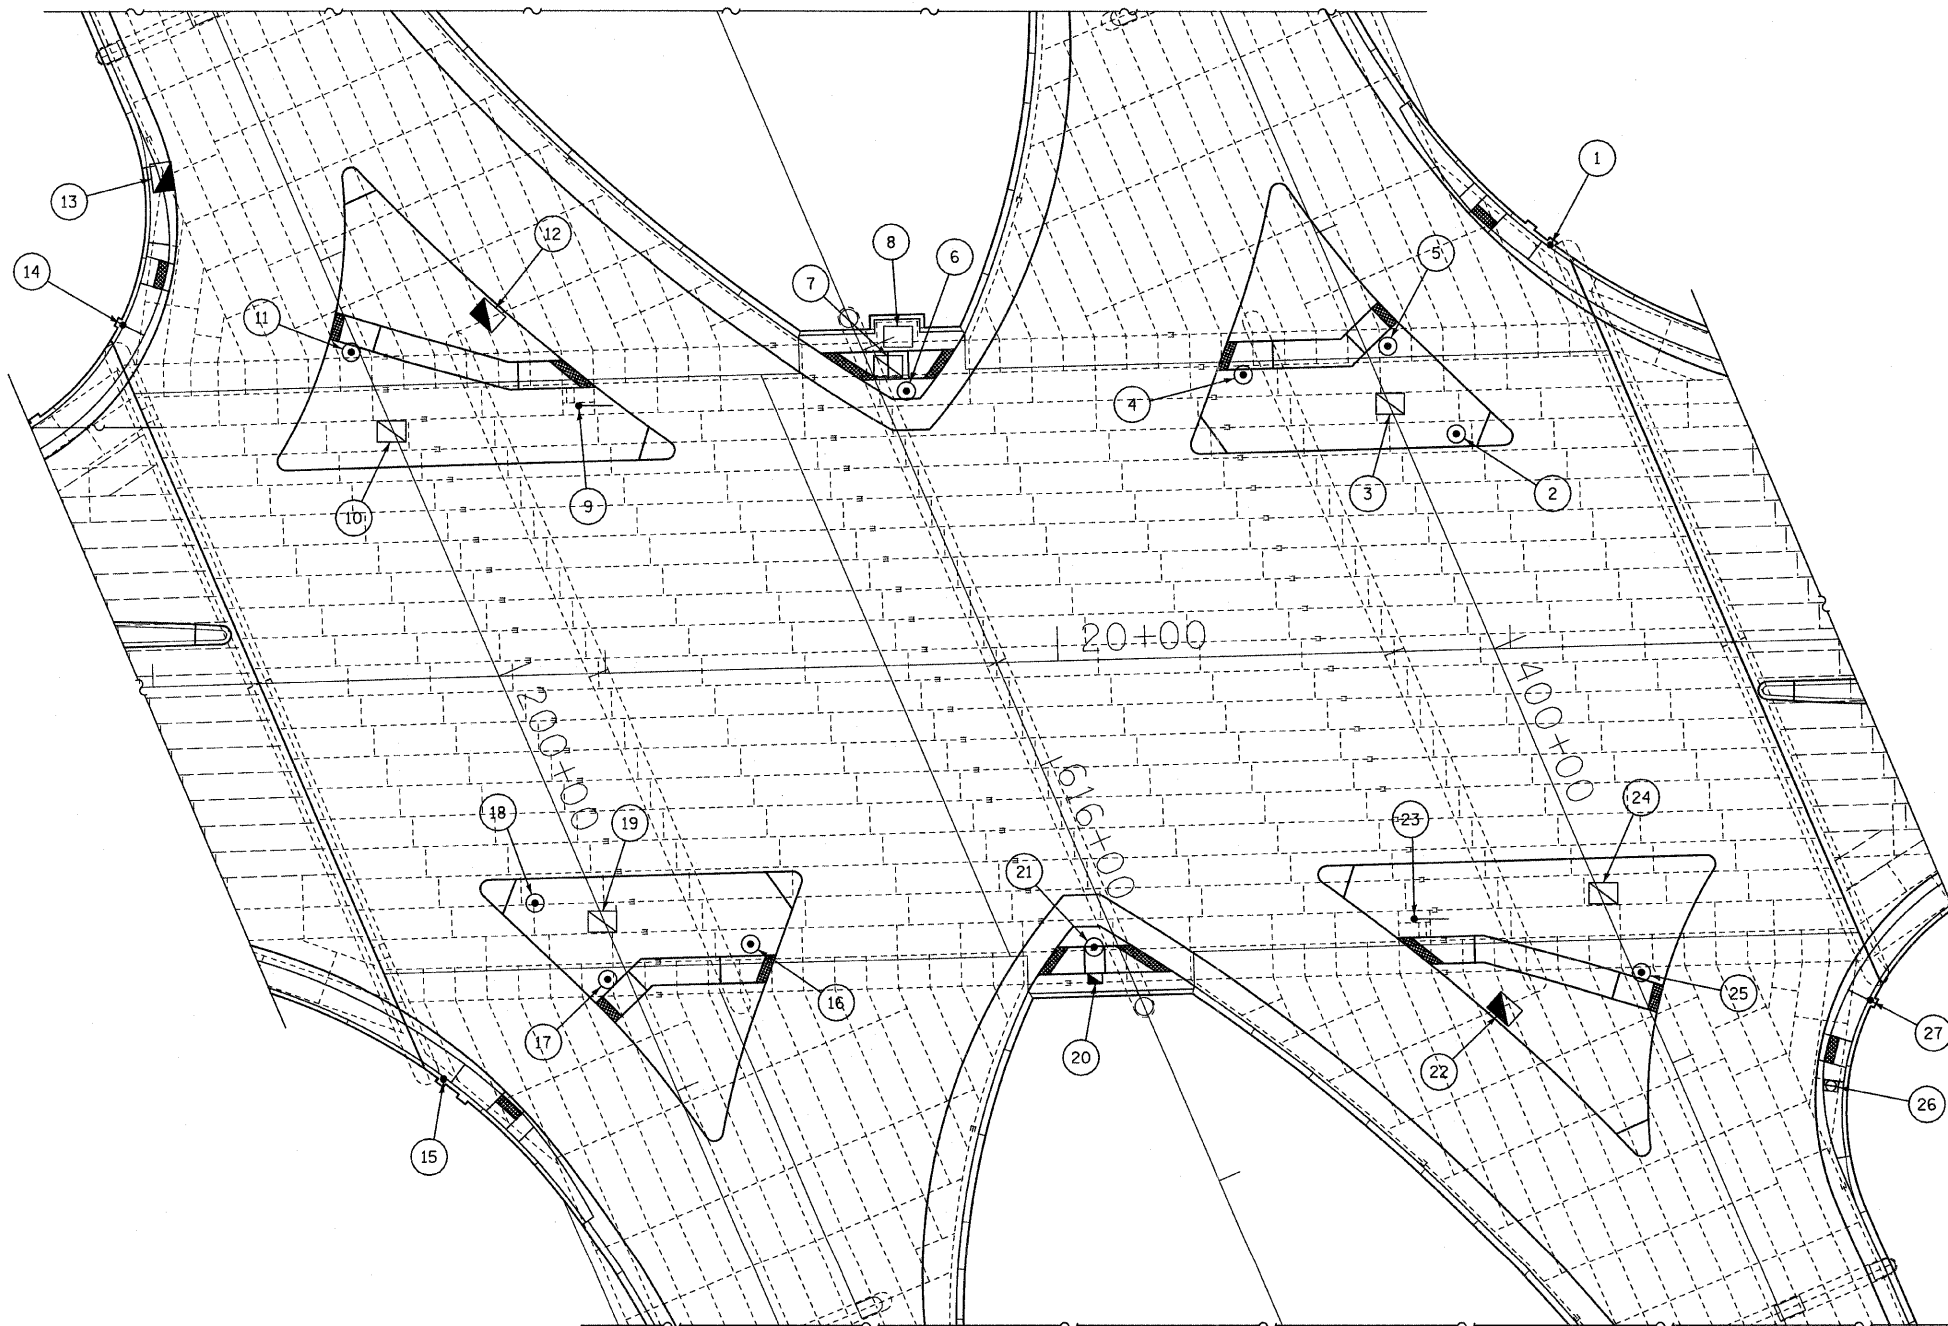


STATE OF ILLINOIS
DEPARTMENT OF TRANSPORTATION



I.D. No.	Type	TP Mounting Detail	Reference Baseline	Station	Offset
1	TP	PM	Central	21+10.79	88.54 LT
2	TP	IM-A	Central	20+90.28	49.02 LT
3	DHH		Central	20+75.92	54.00 LT
4	TP	IM-B	Central	20+41.28	61.71 LT
5	TP	IM-B	Central	20+75.24	68.92 LT
6	TP	IM-A	Central	19+67.51	62.50 LT
7	DHH		Central	19+66.51	68.33 LT
8	TC		Central	19+66.51	73.63 LT
9	TPMA		Central	18+93.86	61.71 LT
10	DHH		Central	18+53.97	54.00 LT
11	TP	IM-C	Central	18+44.41	73.17 LT
12	HH-C		Central	18+75.51	78.84 LT
13	HH-C		Central	18+03.22	112.48 LT
14	TP	PM	Central	17+95.77	80.13 LT
15	TP	PM	Central	18+62.04	88.53 RT
16	TP	IM-B	Central	19+31.56	61.71 RT
17	TP	IM-B	Central	18+97.60	68.92 RT
18	TP	IM-A	Central	18+82.55	49.02 RT
19	DHH		Central	18+96.90	54.00 RT
20	HH-C		Central	20+06.33	70.08 RT
21	TP	IM-A	Central	20+05.34	62.50 RT
22	HH-C		Central	20+94.81	81.46 RT
23	TPMA		Central	20+78.99	61.71 RT
24	DHH		Central	21+18.86	54.00 RT
25	TP	IM-C	Central	21+28.44	73.17 RT
26	HH		Central	21+68.19	99.08 RT
27	TP	PM	Central	21+77.07	80.13 RT

LEGEND

- TP-PM Traffic Post - Parapet Mounted
- ⊙ TP-IM Traffic Post - Island Mounted
- TPMA Traffic Post w/Mast Arm - Island Mounted
- ⊠ HH Precast Concrete Handhole (20" x 20")
- ⊠ DHH Precast Concrete Double Handhole (24" x 48")
- ⊠ HH-C Handhole - Composite
- ⊠ TC Traffic Controller/UPS Pad (31" x 72")

NOTES:

1. For pay items for Lighting Appurtenances, see Lighting Plans.
2. See sheet 69 for details of precast concrete handholes.
3. See sheet 67 thru 68 for installation details for Traffic Signal and Lighting Appurtenances.
4. Traffic pole stationing and offset measured from inside face of parapet.

TRAFFIC SIGNAL APPURTENANCES

KEY PLAN

STRUCTURE NO. 016-0724

TYLIN INTERNATIONAL

DESIGNED - JPN	REVISIONS	
	NAME	DATE
CHECKED - AMD,		
DRAWN - MAU		
CHECKED - AMD,		
DATE - 03/25/2011		

SHEET NO. 66	F.A.I. RTE.	SECTION	COUNTY	TOTAL SHEETS	SHEET NO.
	55	0711.2R & 1011.1BR	COOK	741	390
239 SHEETS	CONTRACT NO. 60999				
FED. ROAD DIST. NO. 1 ILLINOIS FED. AID PROJECT					

p:\01345\structure\2 Central Ave. 016-0724\155.tbl.dwg 4/28/2011 11:51:40 AM