


LEGEND

<ul style="list-style-type: none"> PROPOSED COM ED POWER POLE EXISTING COM ED POWER POLE 2" CONDUIT, PUSHED 8' LONG WITH 1" UNIT DUCT GROUND OR AS INDICATED 2" CONDUIT, TRENCHED 4' LONG WITH 3" UNIT DUCT GROUND OR AS INDICATED 1 1/4" UNIT DUCT, 2" x 2" & 1" x 4" GND OR AS INDICATED 	<ul style="list-style-type: none"> EXISTING STREET LIGHT, CLEAN AND RELAMP PROPOSED RELOCATION OF EXISTING LIGHT, CLEAN AND RELAMP PROPOSED STREET LIGHT 310W HPS, 35 FT M.H., 10 FT MAST ARM PROPOSED STREET LIGHT, 250W HPS, 45 FT M.H., 15 FT MAST ARM ON COMBINATION TRAFFIC SIGNAL/STREET LIGHT POLE PROPOSED LIGHTING CONTROLLER, 100 AMP, 120/240 V, 3 WIRE
--	--

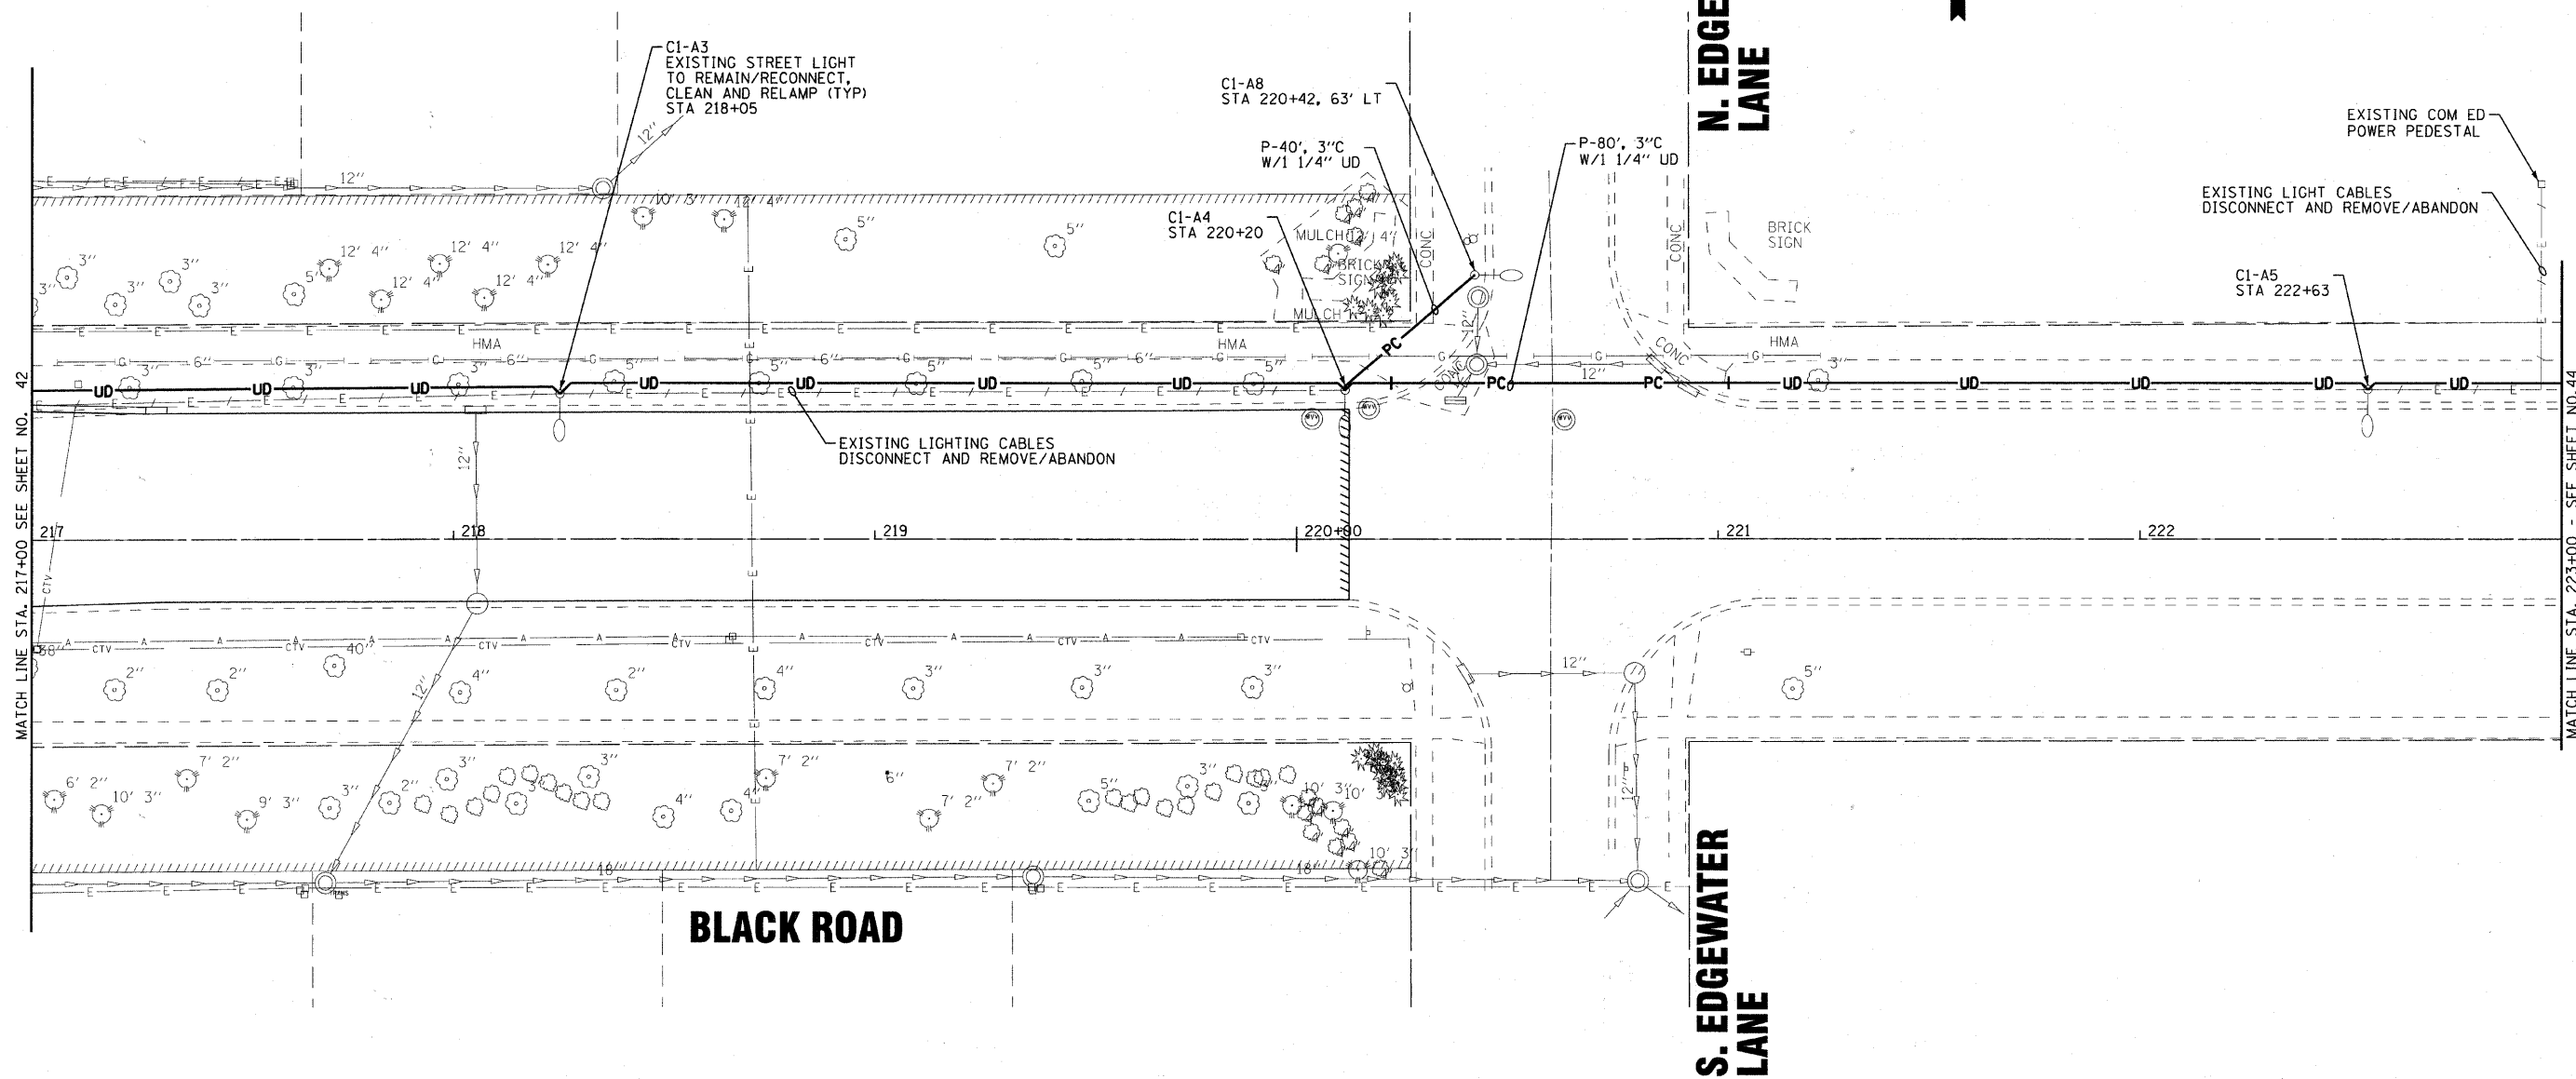

MATCH LINE STA. 217+00 SEE SHEET NO. 42

MATCH LINE STA. 223+00 - SEE SHEET NO. 44

COPYRIGHT © 2009 BY BAXTER & WOODMAN, INC.
 STATE OF ILLINOIS - PROFESSIONAL DESIGN FIRM
 LICENSE NO. 196-00021 - EXPIRES 4/30/2011
 227 E. 2nd St.
 Chicago, IL 60611-4141
 FAX: 312.467.1444
 www.baxterandwoodman.com



DESIGNED - MWH	REVISED - 1-31-11 PER VILLAGE
DRAWN - CJC	REVISED -
CHECKED - MDK	REVISED -
DATE - 12/6/10	FILE - 090491-PH2-SL2.sh+

**VILLAGE OF SHOREWOOD, ILLINOIS
BLACK ROAD & RIVER ROAD
INTERSECTION IMPROVEMENT**

**LIGHTING PLAN
BLACK ROAD**

SCALE: 1"=20'

STA. 217+00 TO STA. 223+00

F.A.U. R.T.E.	SECTION	COUNTY	TOTAL SHEETS	SHEET NO.
0298 0386	09-00028-00-CH	WILL	63	43
C-91-726-09			CONTRACT NO. 63562	
FED. ROAD DIST. NO. 1 ILLINOIS FED. AID PROJECT M-9003(385)				