


FOR INFORMATION ONLY

LIGHT NO.	STATION	45 F	55 FT	400 W HPS	250 W HPS
50	30+63 US 24				
51	379+35 FAI 474				
52	388+30 FAI 474				
53	382 28 FAI 474				
54	382+83 FAI 474				
55	38+70 FAI 474				
56	38+00 FAI 474				
57	37+35 FAI 474				
58	408 35 FAI 474				
59	3+15 RAMP C				
60	6+00 RAMP C				
61	9+18 RAMP C				
62	12+18 RAMP C				
63	5+18 RAMP C				
64	17+50 RAMP C				
65	20+00 RAMP				
66	22+85 RAMP C				
67	183+85 US 24				
68	184+00 US 24				
69	20+5 US 24				
70	201+58 US 24				
71	203+75 US 24				
72	208+15 US 24				
73	21+00 RAMP B				
74	31+00 RAMP B				
75	4+5 RAMP B				
76	6+00 RAMP B				
77	3+47 RAMP B				
78	400 RAMP B				
79	408 RAMP B				
80	209+35 US 24				
81	209+60 US 24				
82	212 31+44 US 24				
83	211+98.76 US 24				
84	214+78.23 US 24				
85	214+50 US 24				
86	21 30.01 US 2				
87	215+98.51 US 24				
88	228+08 US 24				
89	219+58 US 24				

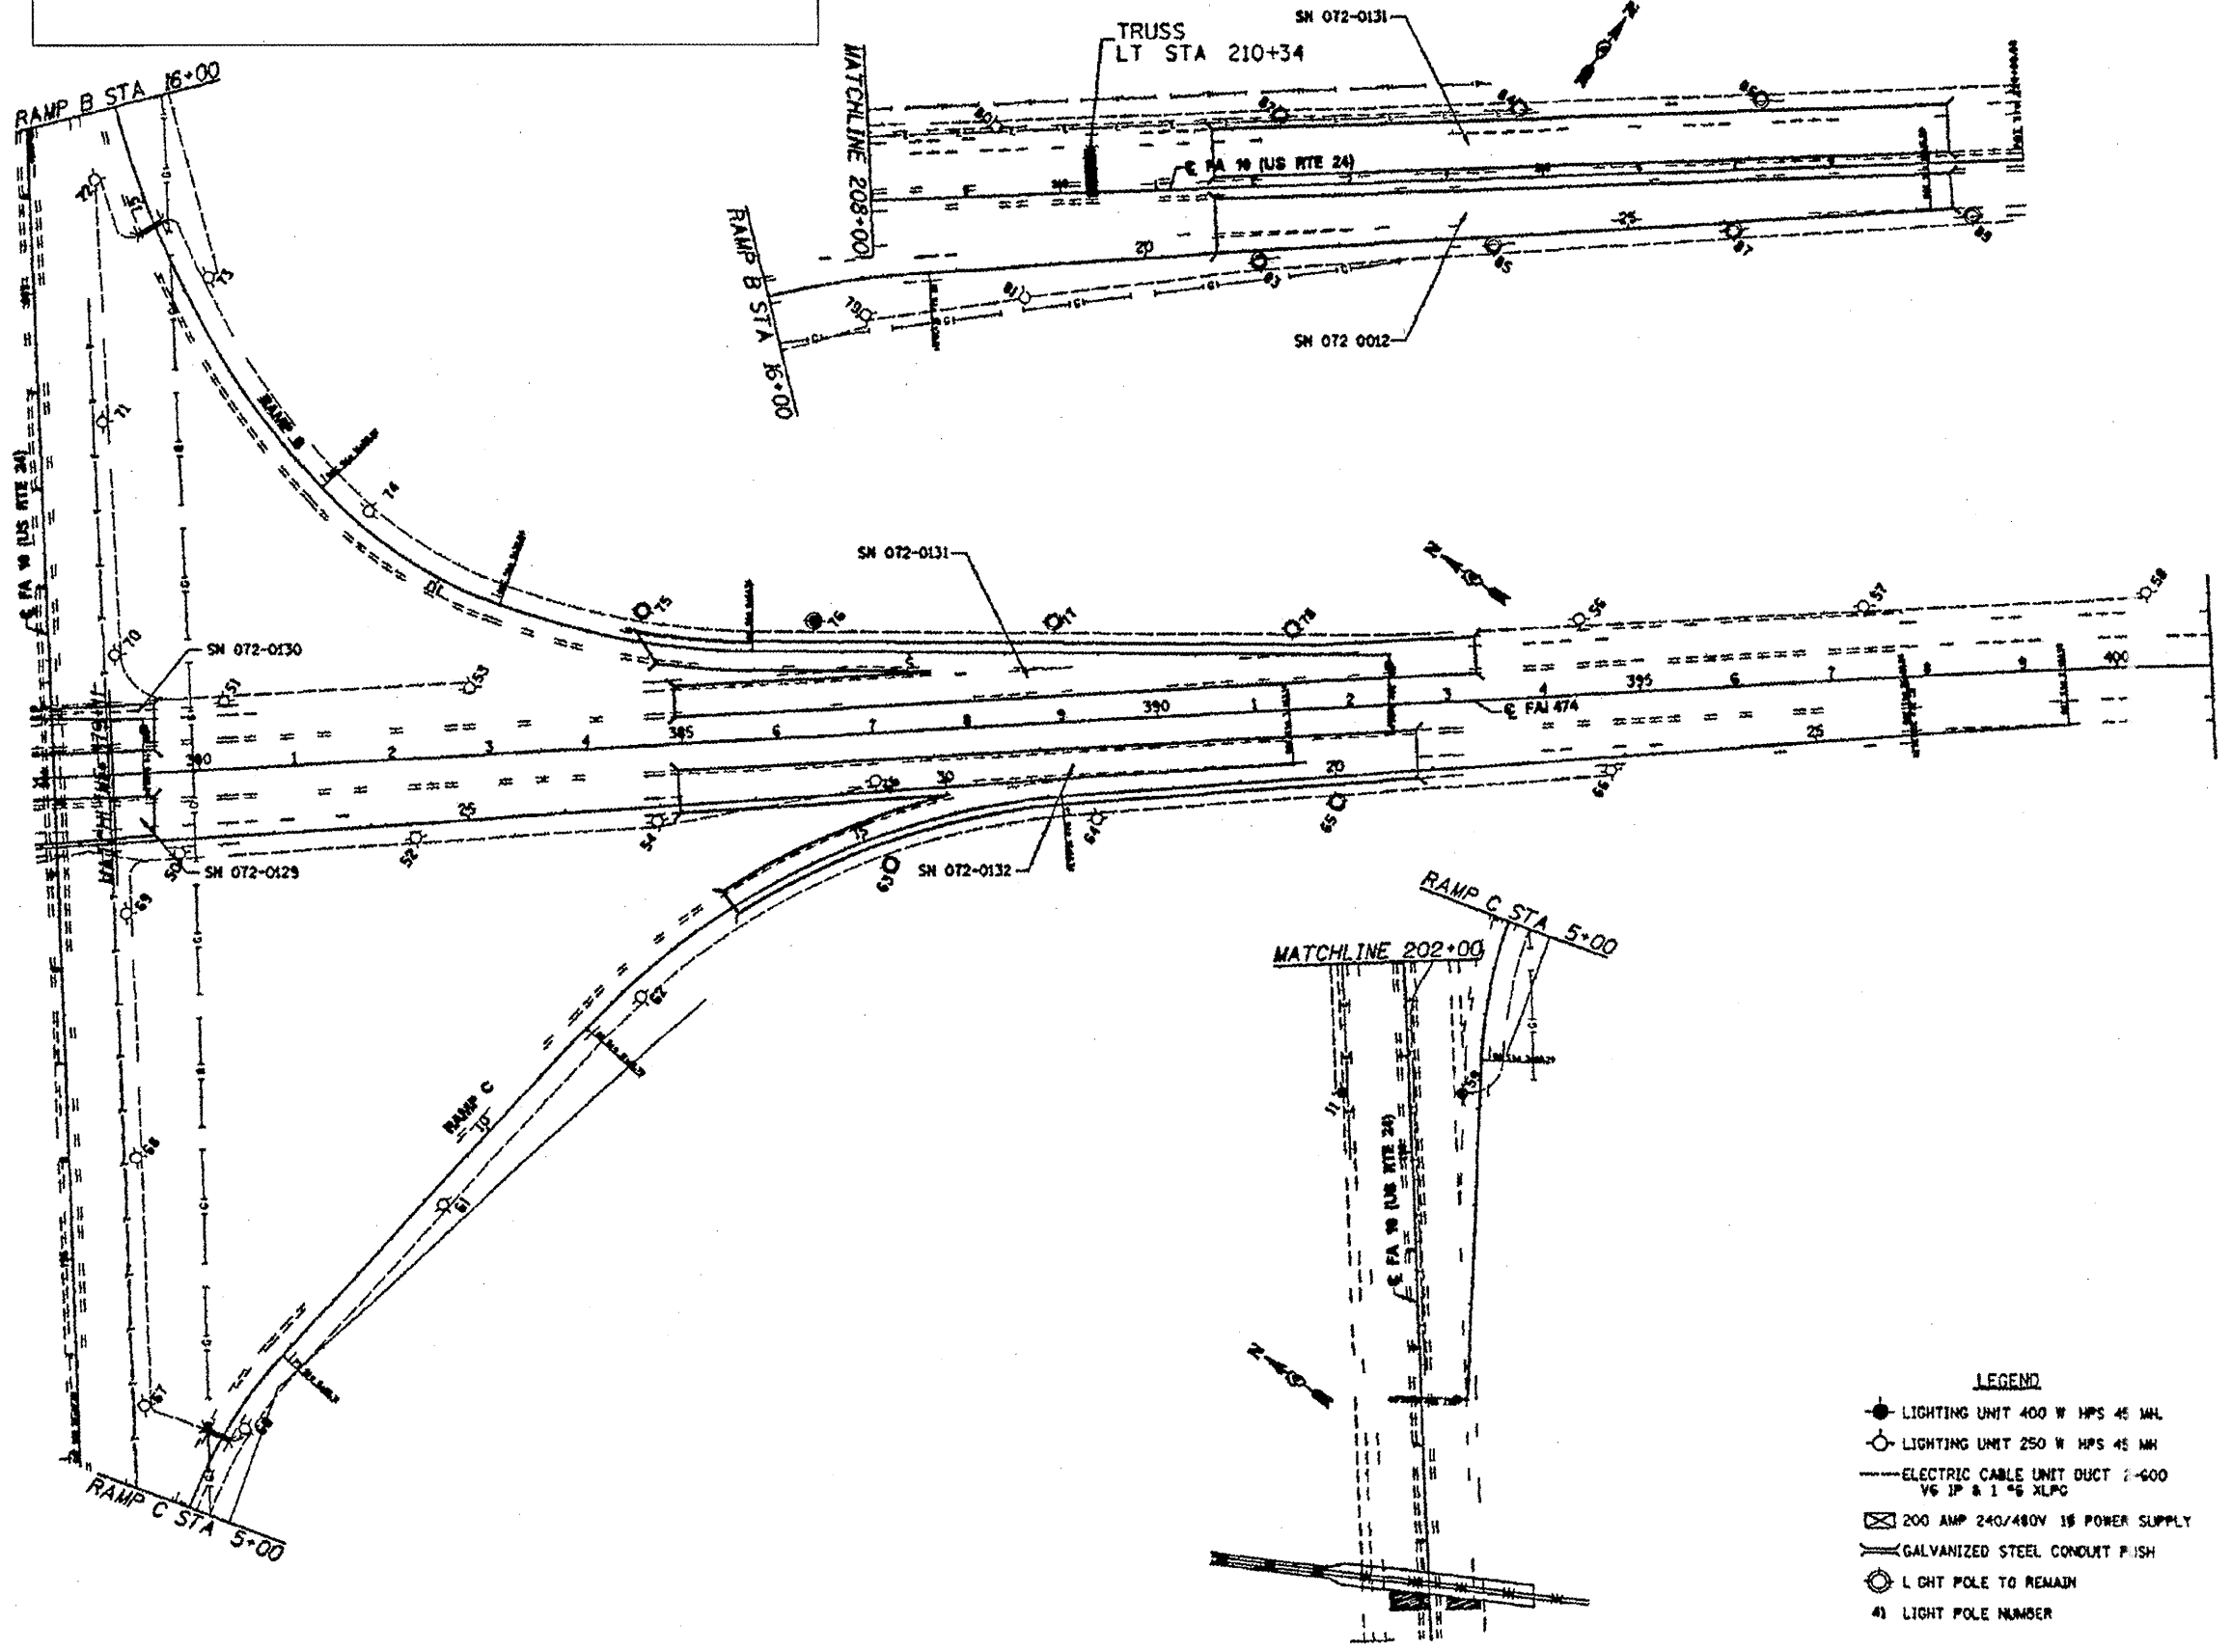

NOTE: LIGHTING UNIT IN BOLD PRINT REPRESENTS POLES TO BE LEFT IN PLACE.

- LEGEND**
- LIGHTING UNIT 400 W HPS 45 MH
 - LIGHTING UNIT 250 W HPS 45 MH
 - ELECTRIC CABLE UNIT DUCT 2-600 VG IP & 1-65 XLPC
 - ⊠ 200 AMP 240/480V 1Φ POWER SUPPLY
 - GALVANIZED STEEL CONDUIT FISH
 - LIGHT POLE TO REMAIN
 - ④ LIGHT POLE NUMBER

FILE NAME: 68869 - I-474 Snape Lammann Bridge CCT

USER NAME: nowa.de
 Surveillance - Final 2-7-11.dgn
 PLOT SCALE = 1/8" = 1'-0"
 PLOT DATE = 2/11/2011

DESIGNED	---	REVISED	-----
DRAWN	---	REVISED	-----
CHECKED	---	REVISED	-----
DATE	---	REVISED	-----

STATE OF ILLINOIS
 DEPARTMENT OF TRANSPORTATION

EXISTING LIGHTING PLANS I-474 @ US 24 BARTONVILLE
 FOR INFORMATION ONLY
 SCALE: TEMP LIGHTING SHEET 2 OF 6 STA. TO STA.

F.A.I. RTE.	SECTION	COUNTY	TOTAL SHEET NO.
474	(172,90)5B1-2	PEORIA/TAZEWELL	122 / 124
			CONTRACT NO. 68069
ILLINOIS FED. AID PROJECT			