


CONTRACT 76C50  
WORK BY OTHERS

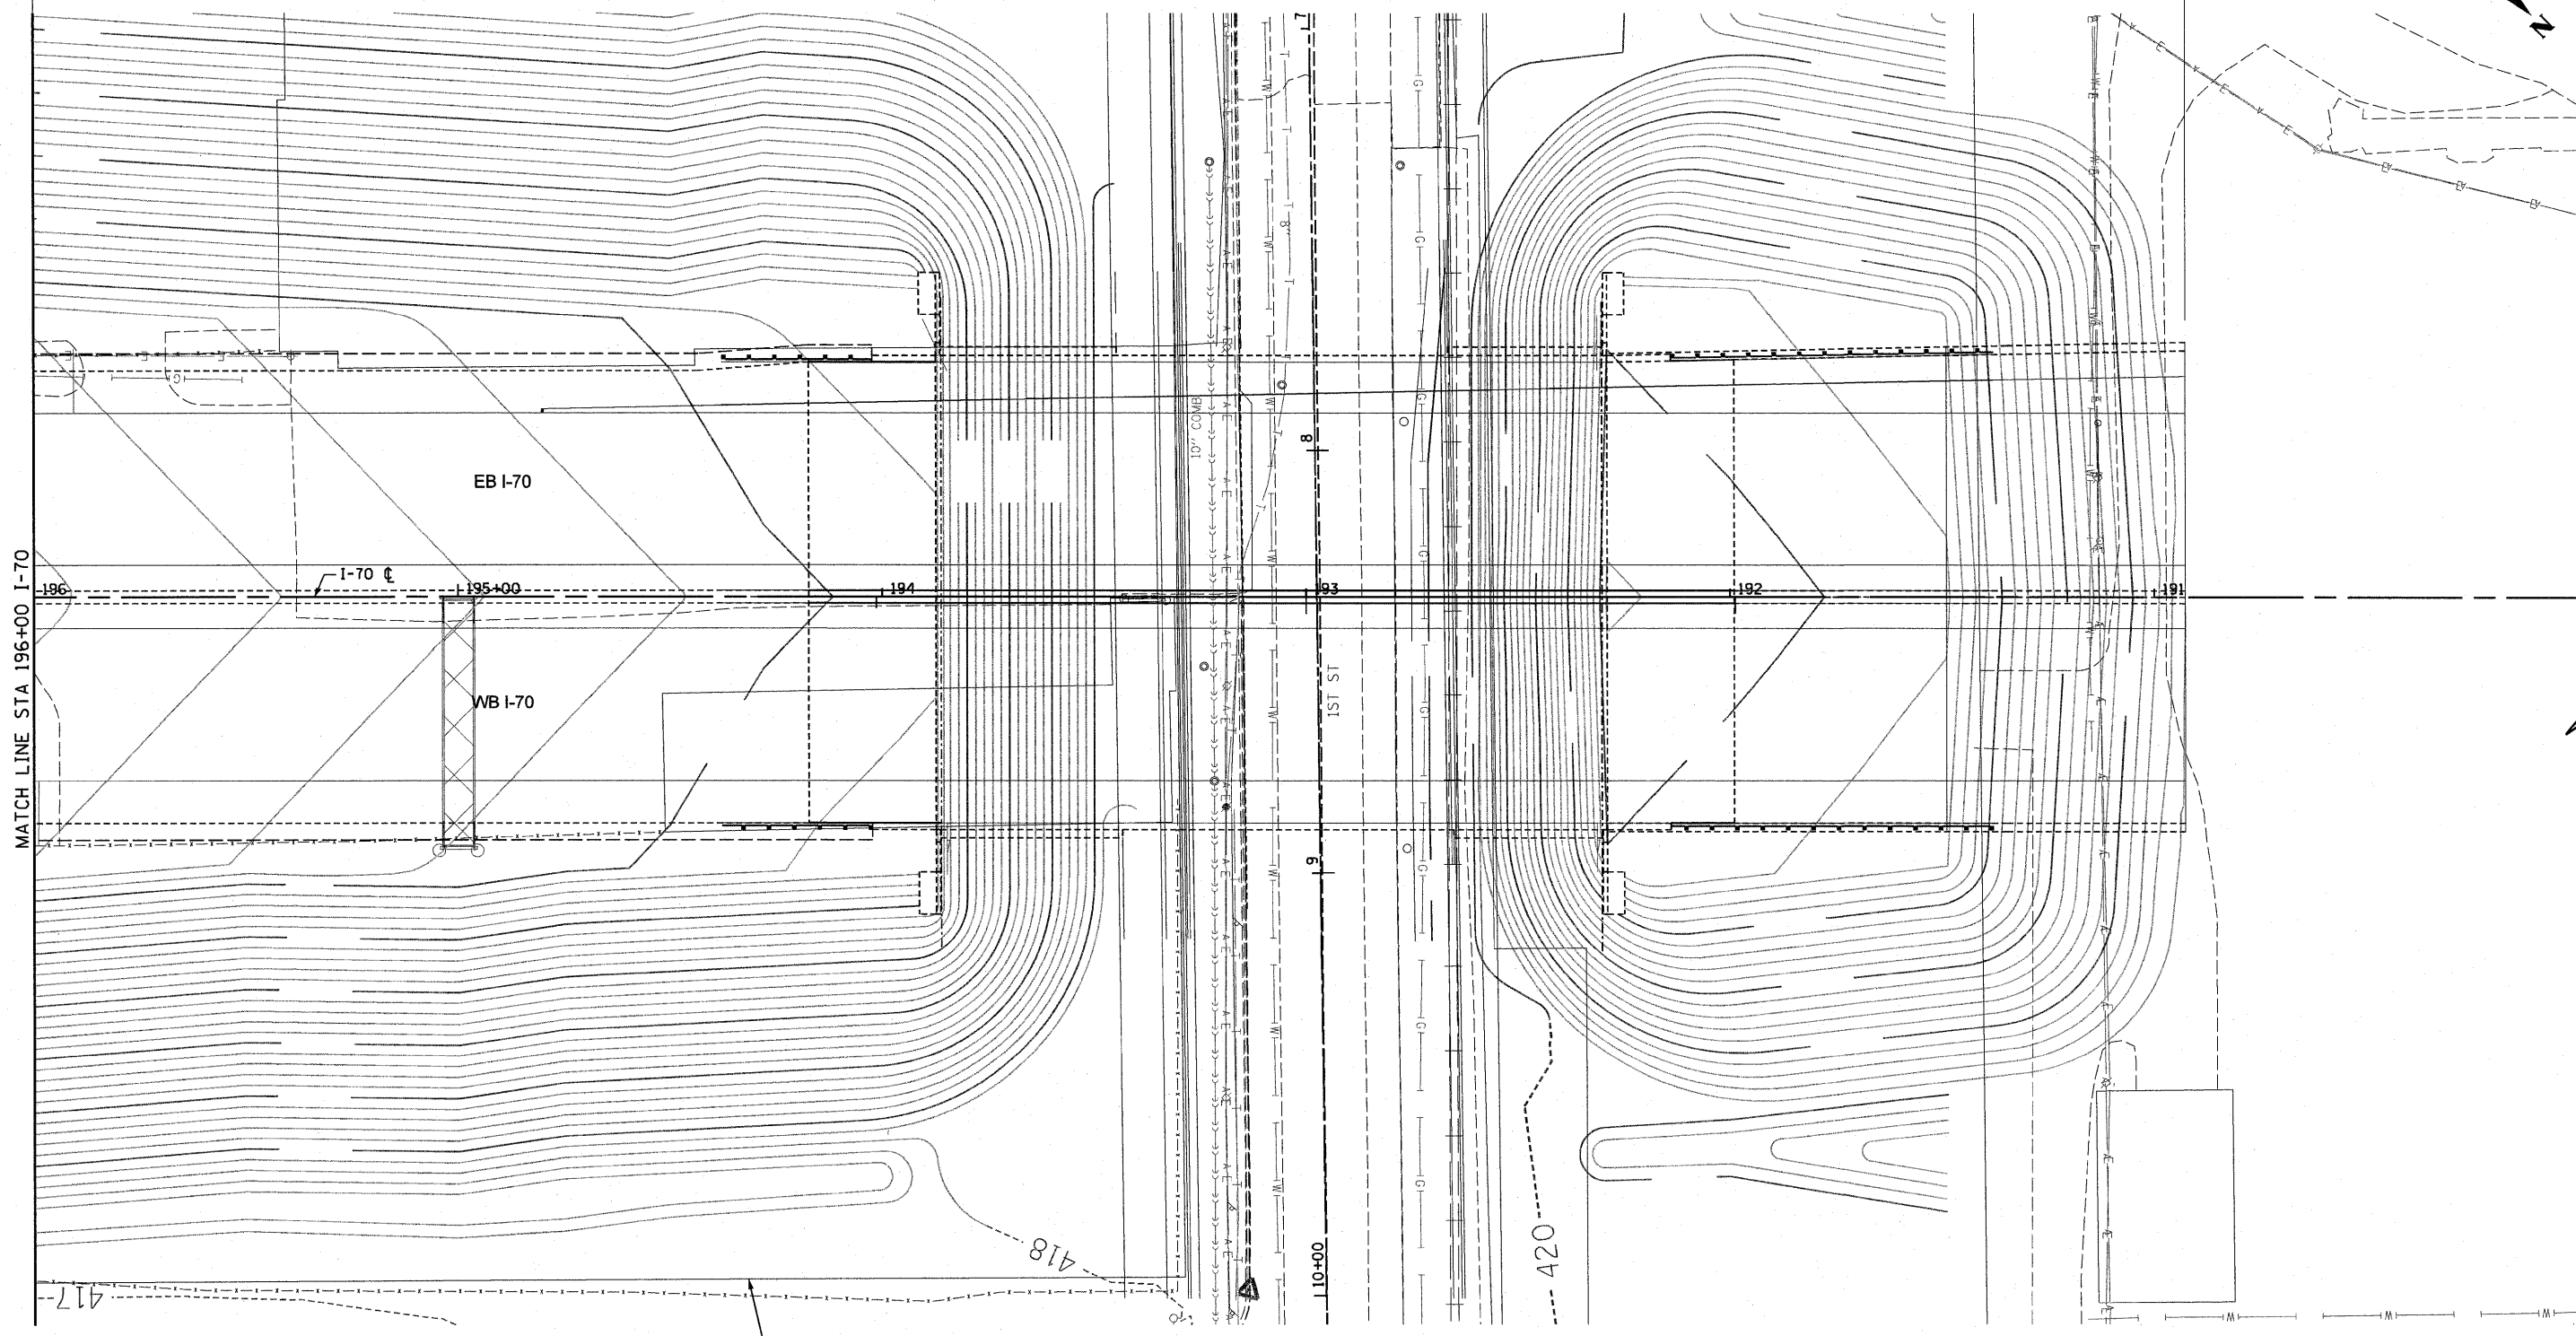

SHEET PROVIDED FOR  
INFORMATION ONLY

USER NAME = searab	DESIGNED - KLK	REVISED -
PLOT SCALE = 40.0000' / in.	DRAWN - KLK	REVISED -
PLOT DATE = #DATE#	CHECKED - EY	REVISED -
	DATE - 3-18-11	REVISED -

STATE OF ILLINOIS  
DEPARTMENT OF TRANSPORTATION

DRAINAGE & UTILITY PLAN  
RAMP 55S70W

SCALE: 1" = 20' SHEET NO. 6 OF 9 SHEETS STA. 196+00 TO STA. 190+00

F.A.I. RTE.	SECTION	COUNTY	TOTAL SHEETS	SHEET NO.
70	82-1-B-1	ST. CLAIR	319	63
FED. ROAD DIST. NO. ILLINOIS FED. AID PROJECT			CONTRACT NO. 76C75	