


DATE	BY

DATE	BY

- NOTES:**
- POWER POLES TO BE RELOCATED BY OTHERS.
 - GAS MAIN TO BE RELOCATED BY OTHERS.

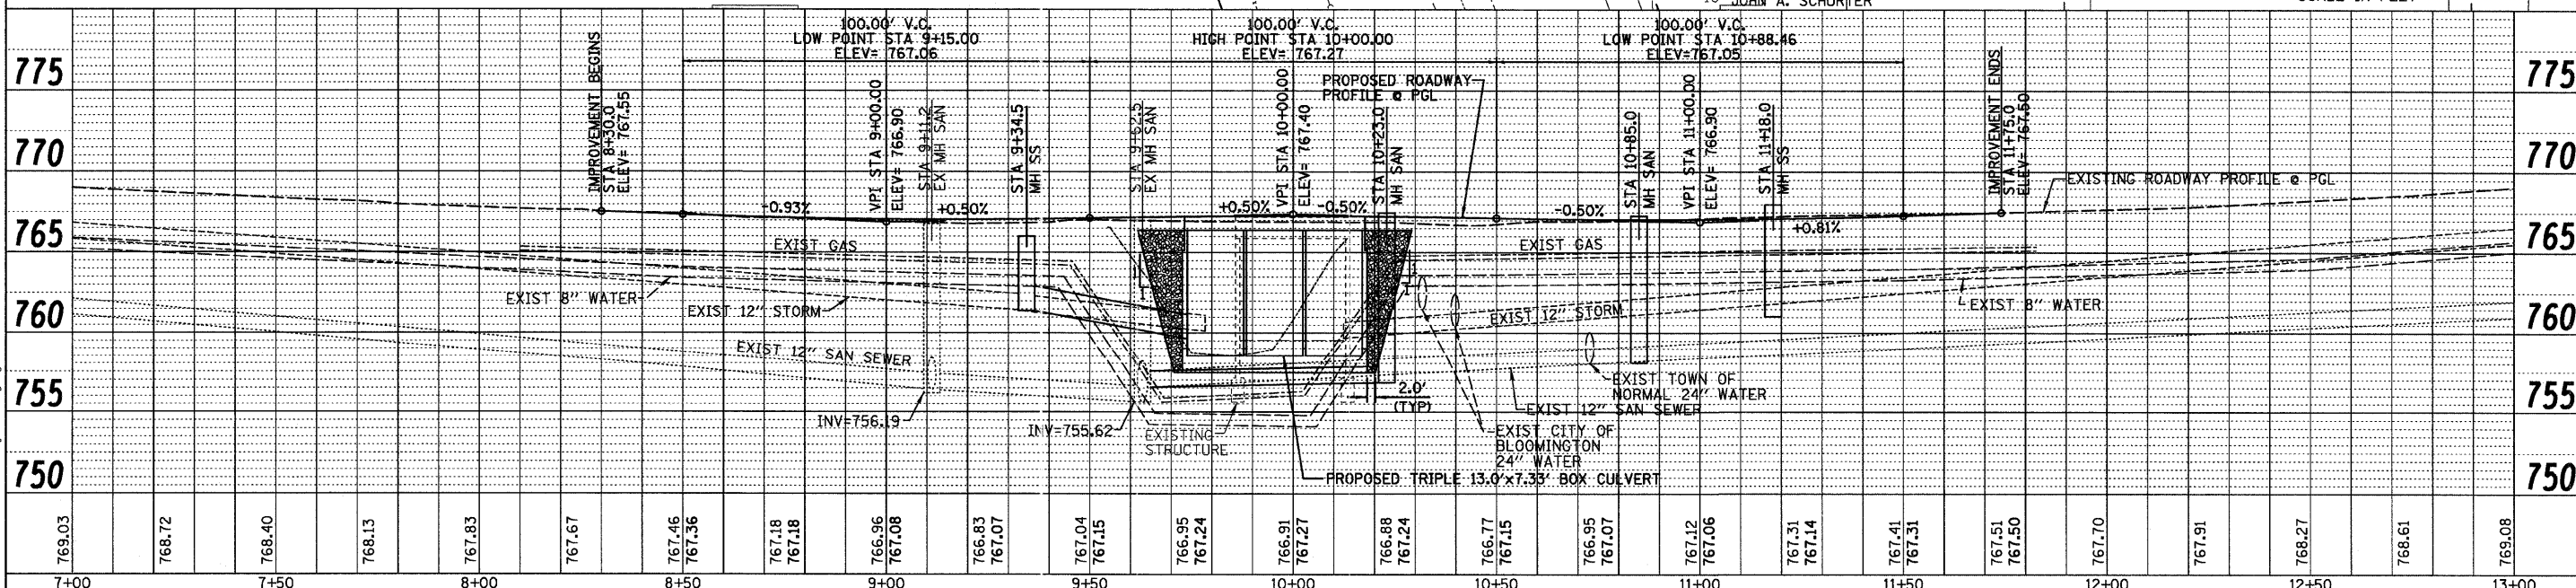

DESIGNED - BAB/JCZ
DRAWN - JTC/JWK
CHECKED - MSW
DATE - 02/25/11

TOWN OF NORMAL

PLAN AND PROFILE

BROADWAY AVENUE OVER SUGAR CREEK
SECTION 07-00233-00-BR
MCLEAN COUNTY

F.A.U.	SECTION	COUNTY	TOTAL SHEETS	SHEET NO.
	07-00233-00-BR	MCLEAN	40	9
S.N. 057-7841		CONTRACT NO. 91422		
FED. ROAD DIST. NO. 5 (ILLINOIS) FED. AID PROJECT				

FARNSWORTH GROUP, INC.

CONSULTING ENGINEERS - 2709 MCGRAW DRIVE BLOOMINGTON, ILLINOIS 61704 (309) 663-8435 / (309) 663-1571 FAX

24-8175