
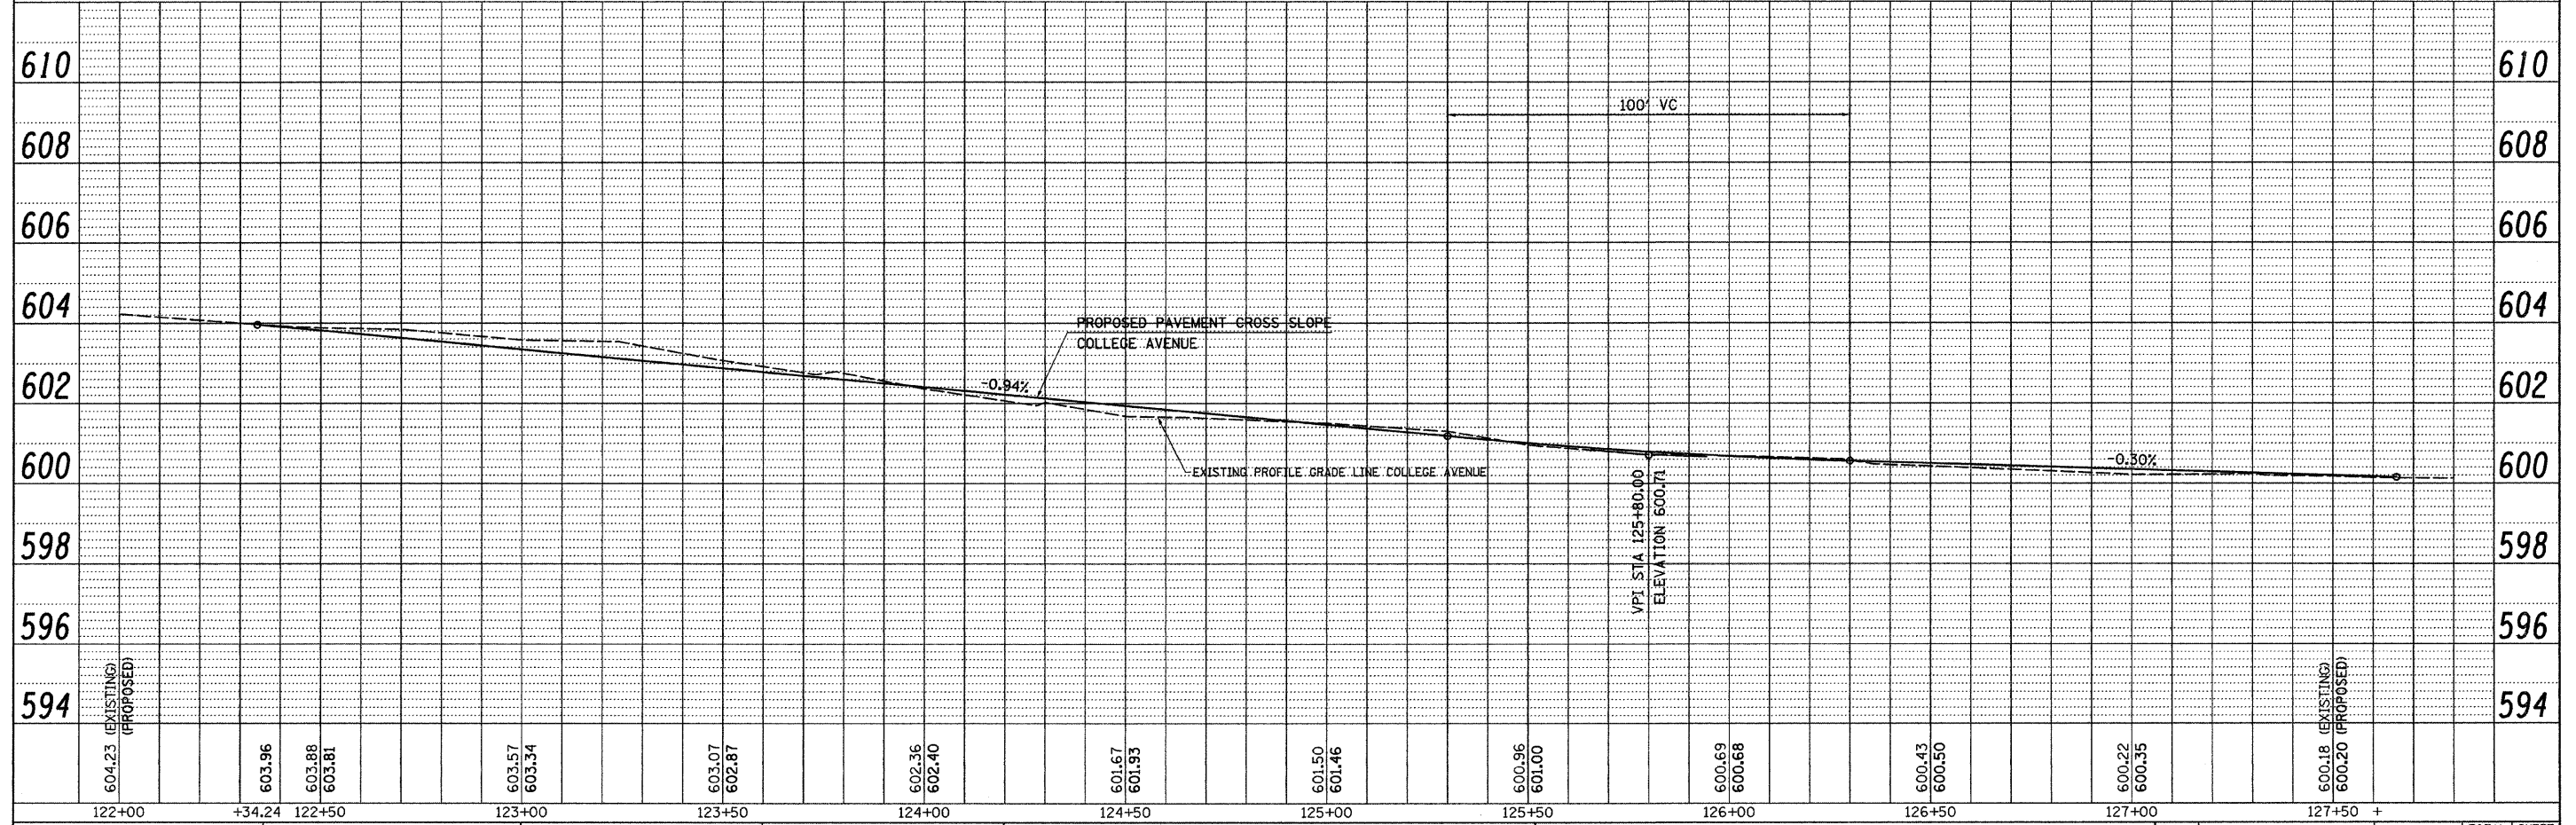


PLAN	SURVEYED	DATE
	PLOTTED	
	CHECKED	
	BY	
	NO.	
	ADD FILE NAME	

PROFILE	SURVEYED	DATE
	PLOTTED	
	CHECKED	
	BY	
	NO.	
	STRUCTURE NOTATION	

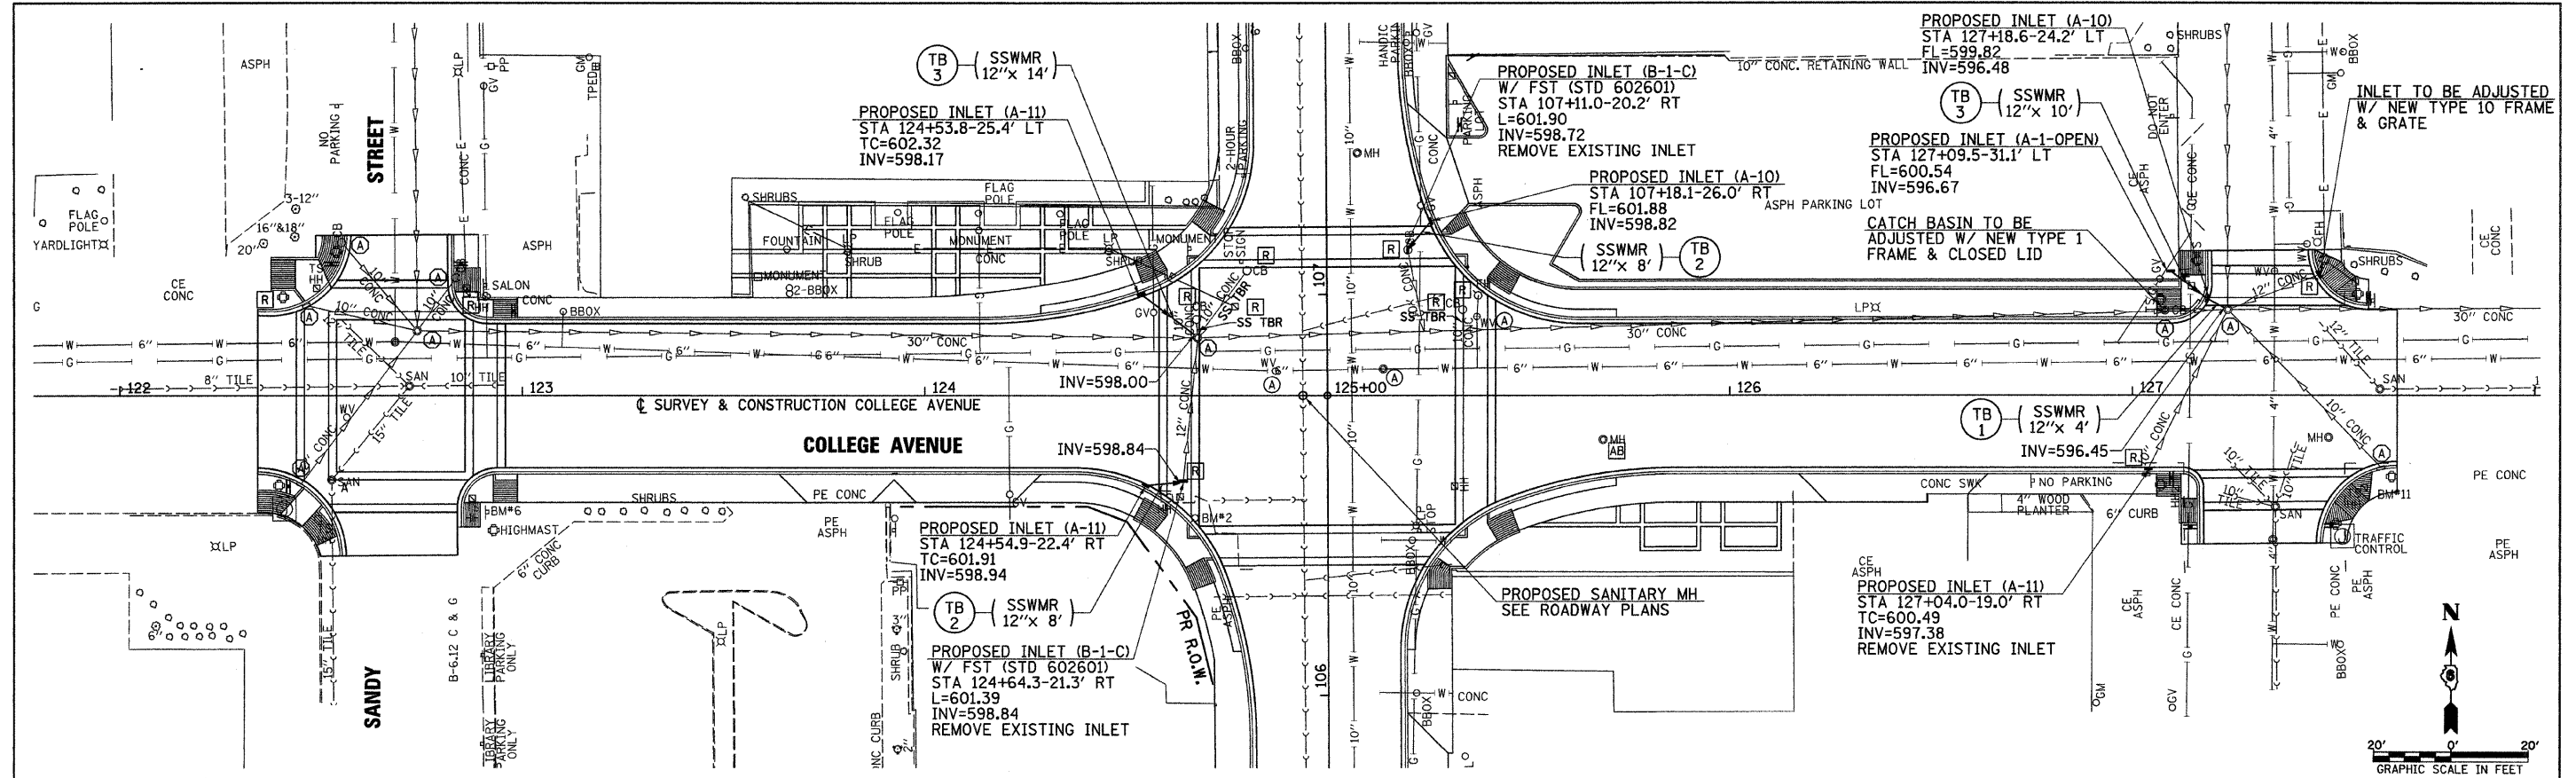

FILE NAME =	USER NAME = jolson	DESIGNED - JRB	REVISED -	STATE OF ILLINOIS DEPARTMENT OF TRANSPORTATION	CITY OF JACKSONVILLE DOWNTOWN STREETS RECONSTRUCTION COLLEGE AVENUE DRAINAGE PLAN & PROFILE SHEET	F.A. RTE.	SECTION	COUNTY	TOTAL SHEETS	SHEET NO.	
vs:\transportation\28993\COLLEGEDRAINPP.dgn	PLOT SCALE = 28.0000' / IN.	DRAWN - JMO	REVISED -			N/A	10-00121-01-PV	MORGAN	77	28	
PLOT DATE = 2/23/2011	DATE = 2/22/11	CHECKED - JRB	REVISED -			CONTRACT NO. 3547					
		DATE = 2/22/11	REVISED -			FED. ROAD DIST. NO. ILLINOIS FED. AID PROJECT					