
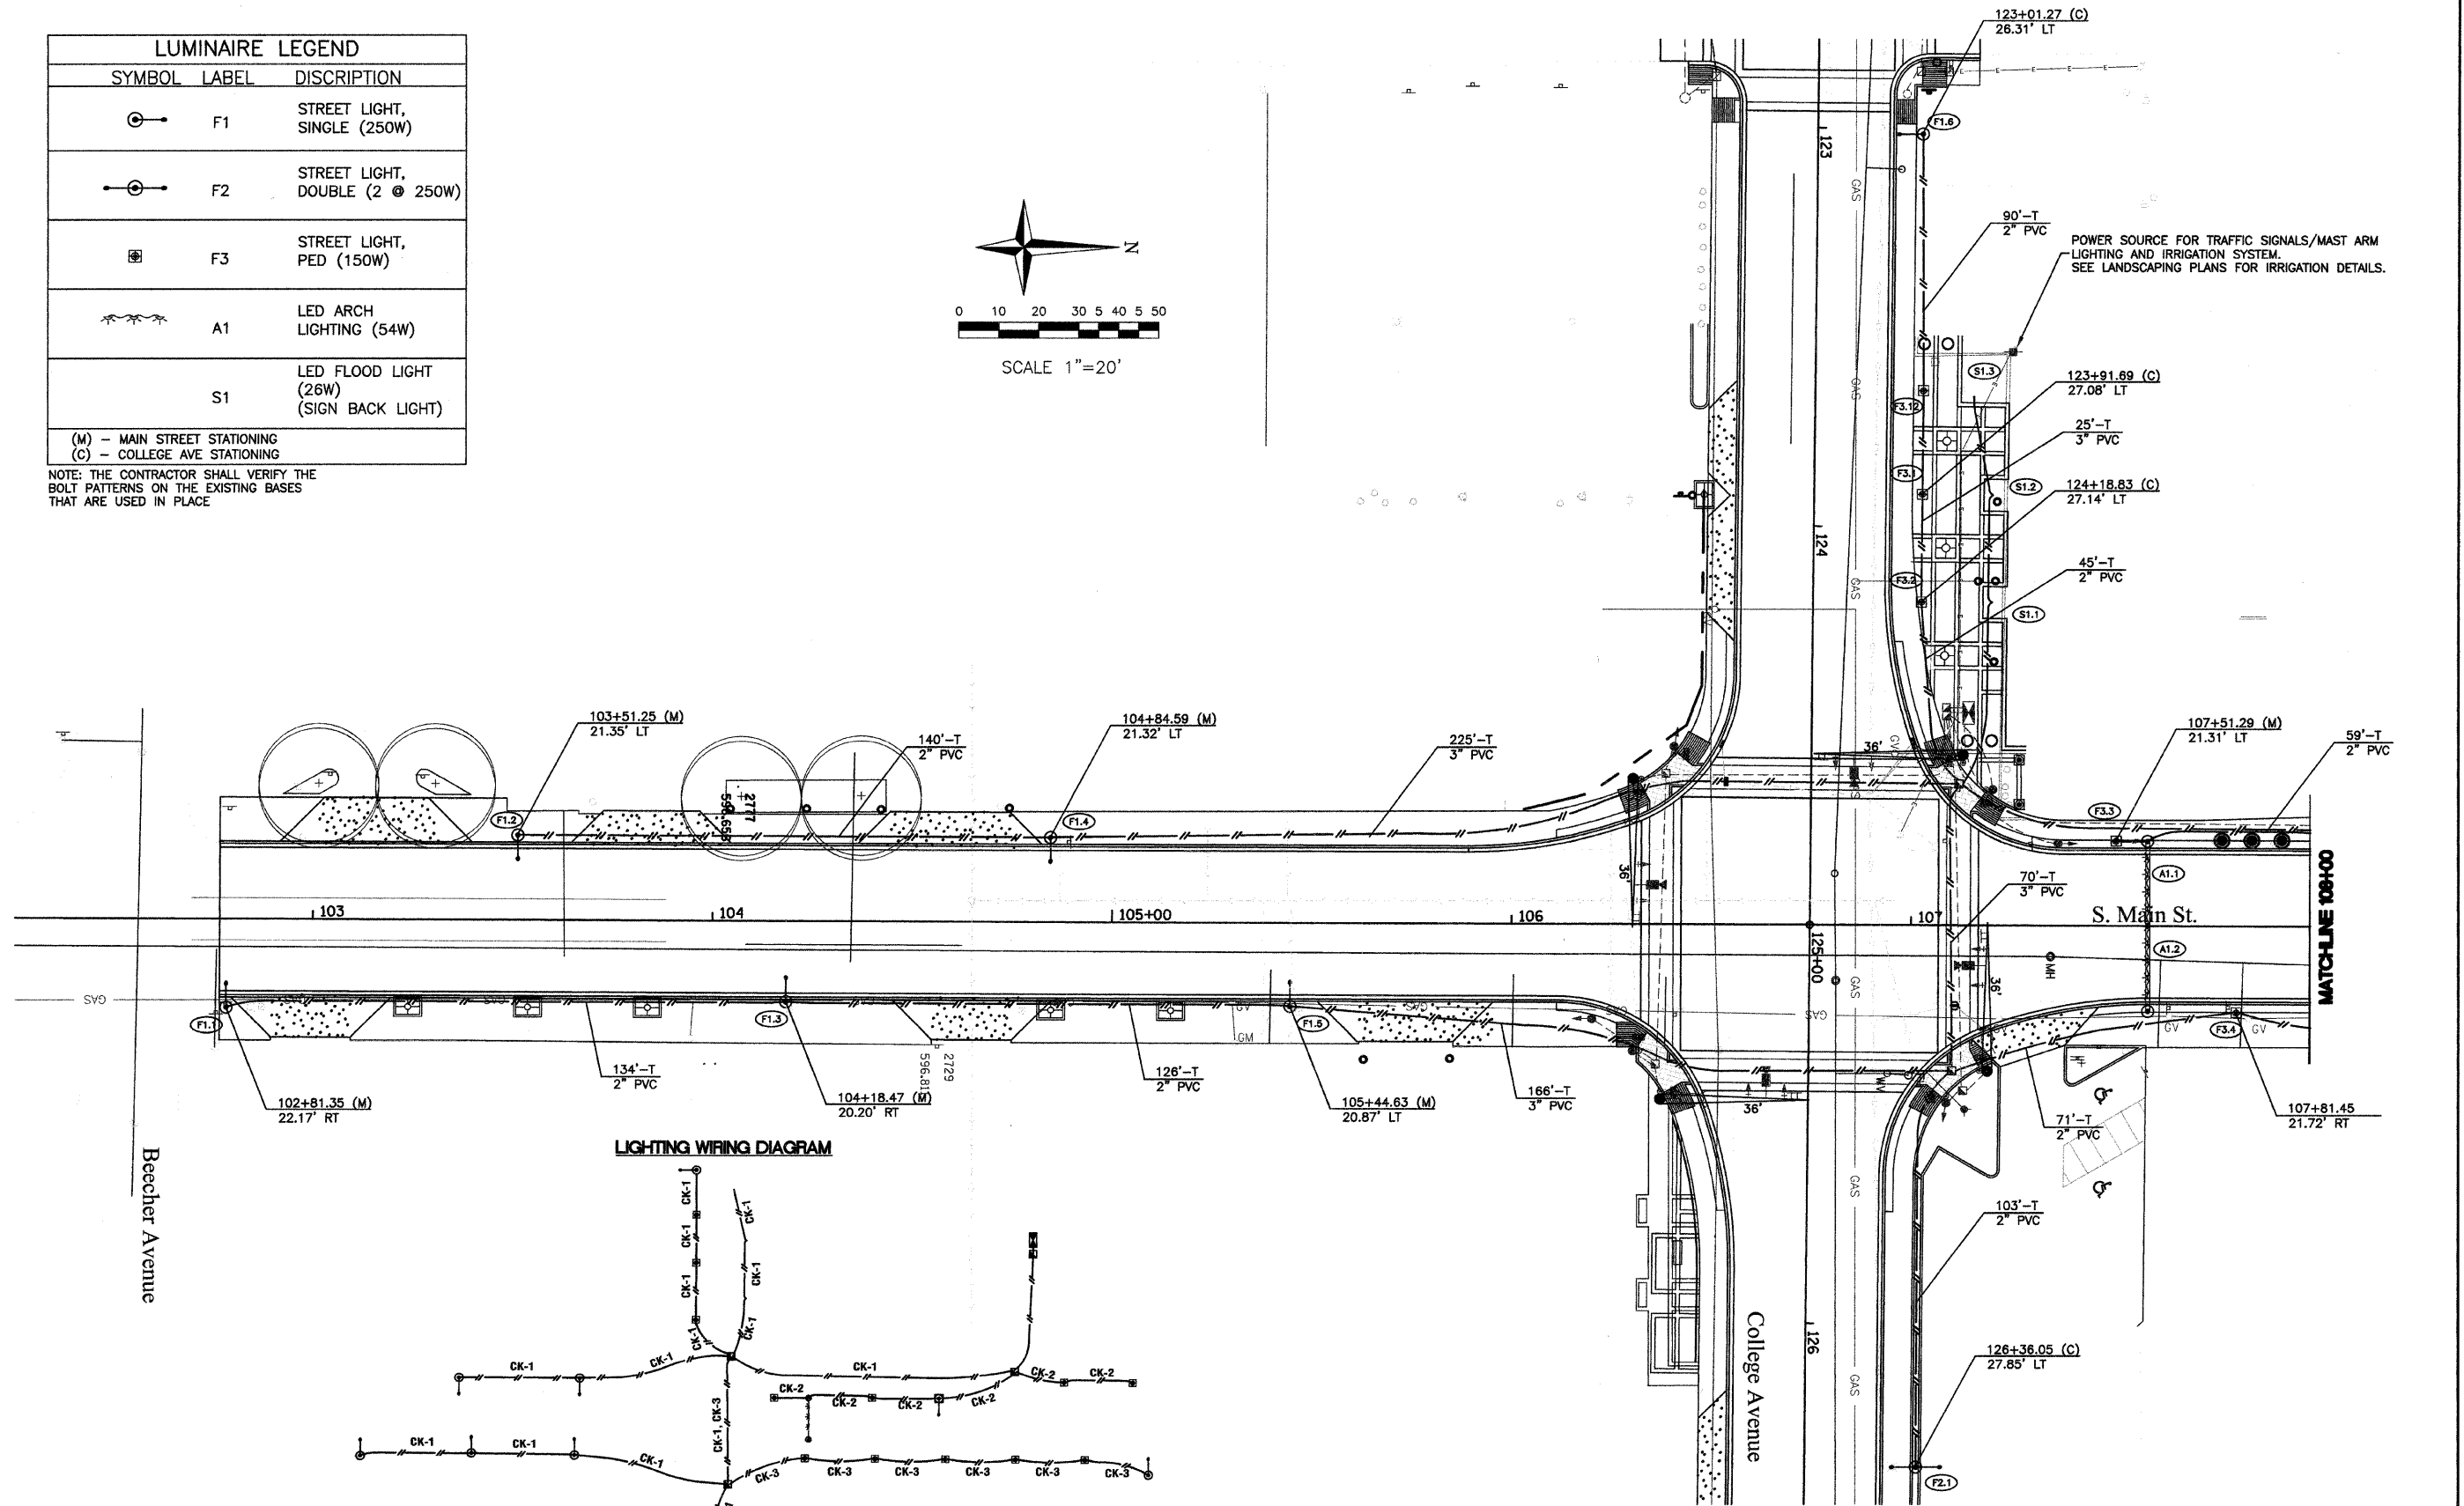



LUMINAIRE LEGEND		
SYMBOL	LABEL	DISCRIPTION
	F1	STREET LIGHT, SINGLE (250W)
	F2	STREET LIGHT, DOUBLE (2 @ 250W)
	F3	STREET LIGHT, PED (150W)
	A1	LED ARCH LIGHTING (54W)
	S1	LED FLOOD LIGHT (26W) (SIGN BACK LIGHT)

(M) - MAIN STREET STATIONING
(C) - COLLEGE AVE STATIONING

NOTE: THE CONTRACTOR SHALL VERIFY THE BOLT PATTERNS ON THE EXISTING BASES THAT ARE USED IN PLACE

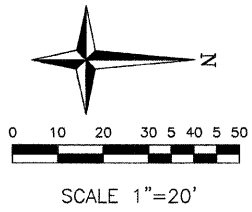

LIGHTING WIRING DIAGRAM

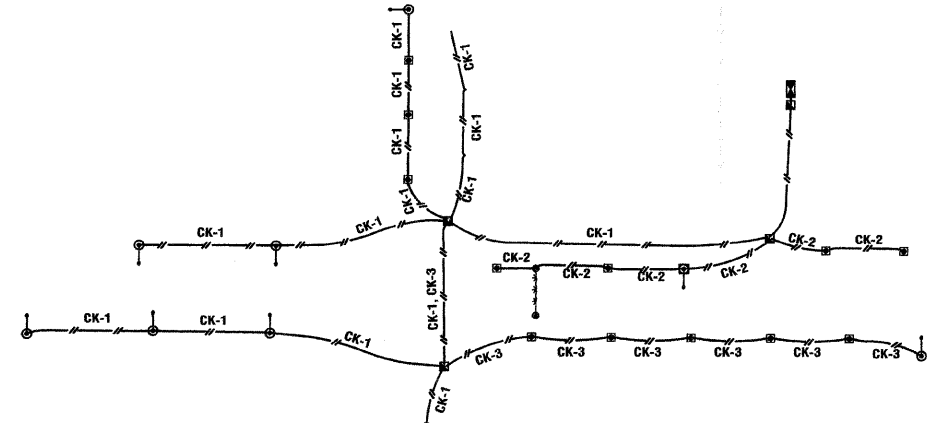

FILE NAME = #FILEL#	USER NAME = #USER#	DESIGNED - EF	REVISED -	STATE OF ILLINOIS DEPARTMENT OF TRANSPORTATION	CITY OF JACKSONVILLE DOWNTOWN STREETS CONSTRUCTION SOUTH MAIN ST & COLLEGE AVE LIGHTING PLAN			F.A. R.T.E. = N/A	SECTION = 10-00121-01-PV	COUNTY = MORGAN	TOTAL SHEETS = 77	SHEET NO. = 40
	PLOT SCALE = #SCALE#	DRAWN - MH	REVISED -		SCALE:	SHEET NO. OF SHEETS	STA. TO STA.	CONTRACT NO. 354				
	PLOT DATE = #DATE#	CHECKED - RS	REVISED -		ILLINOIS FED. AID PROJECT							
		DATE - 2/21/11	REVISED -									