
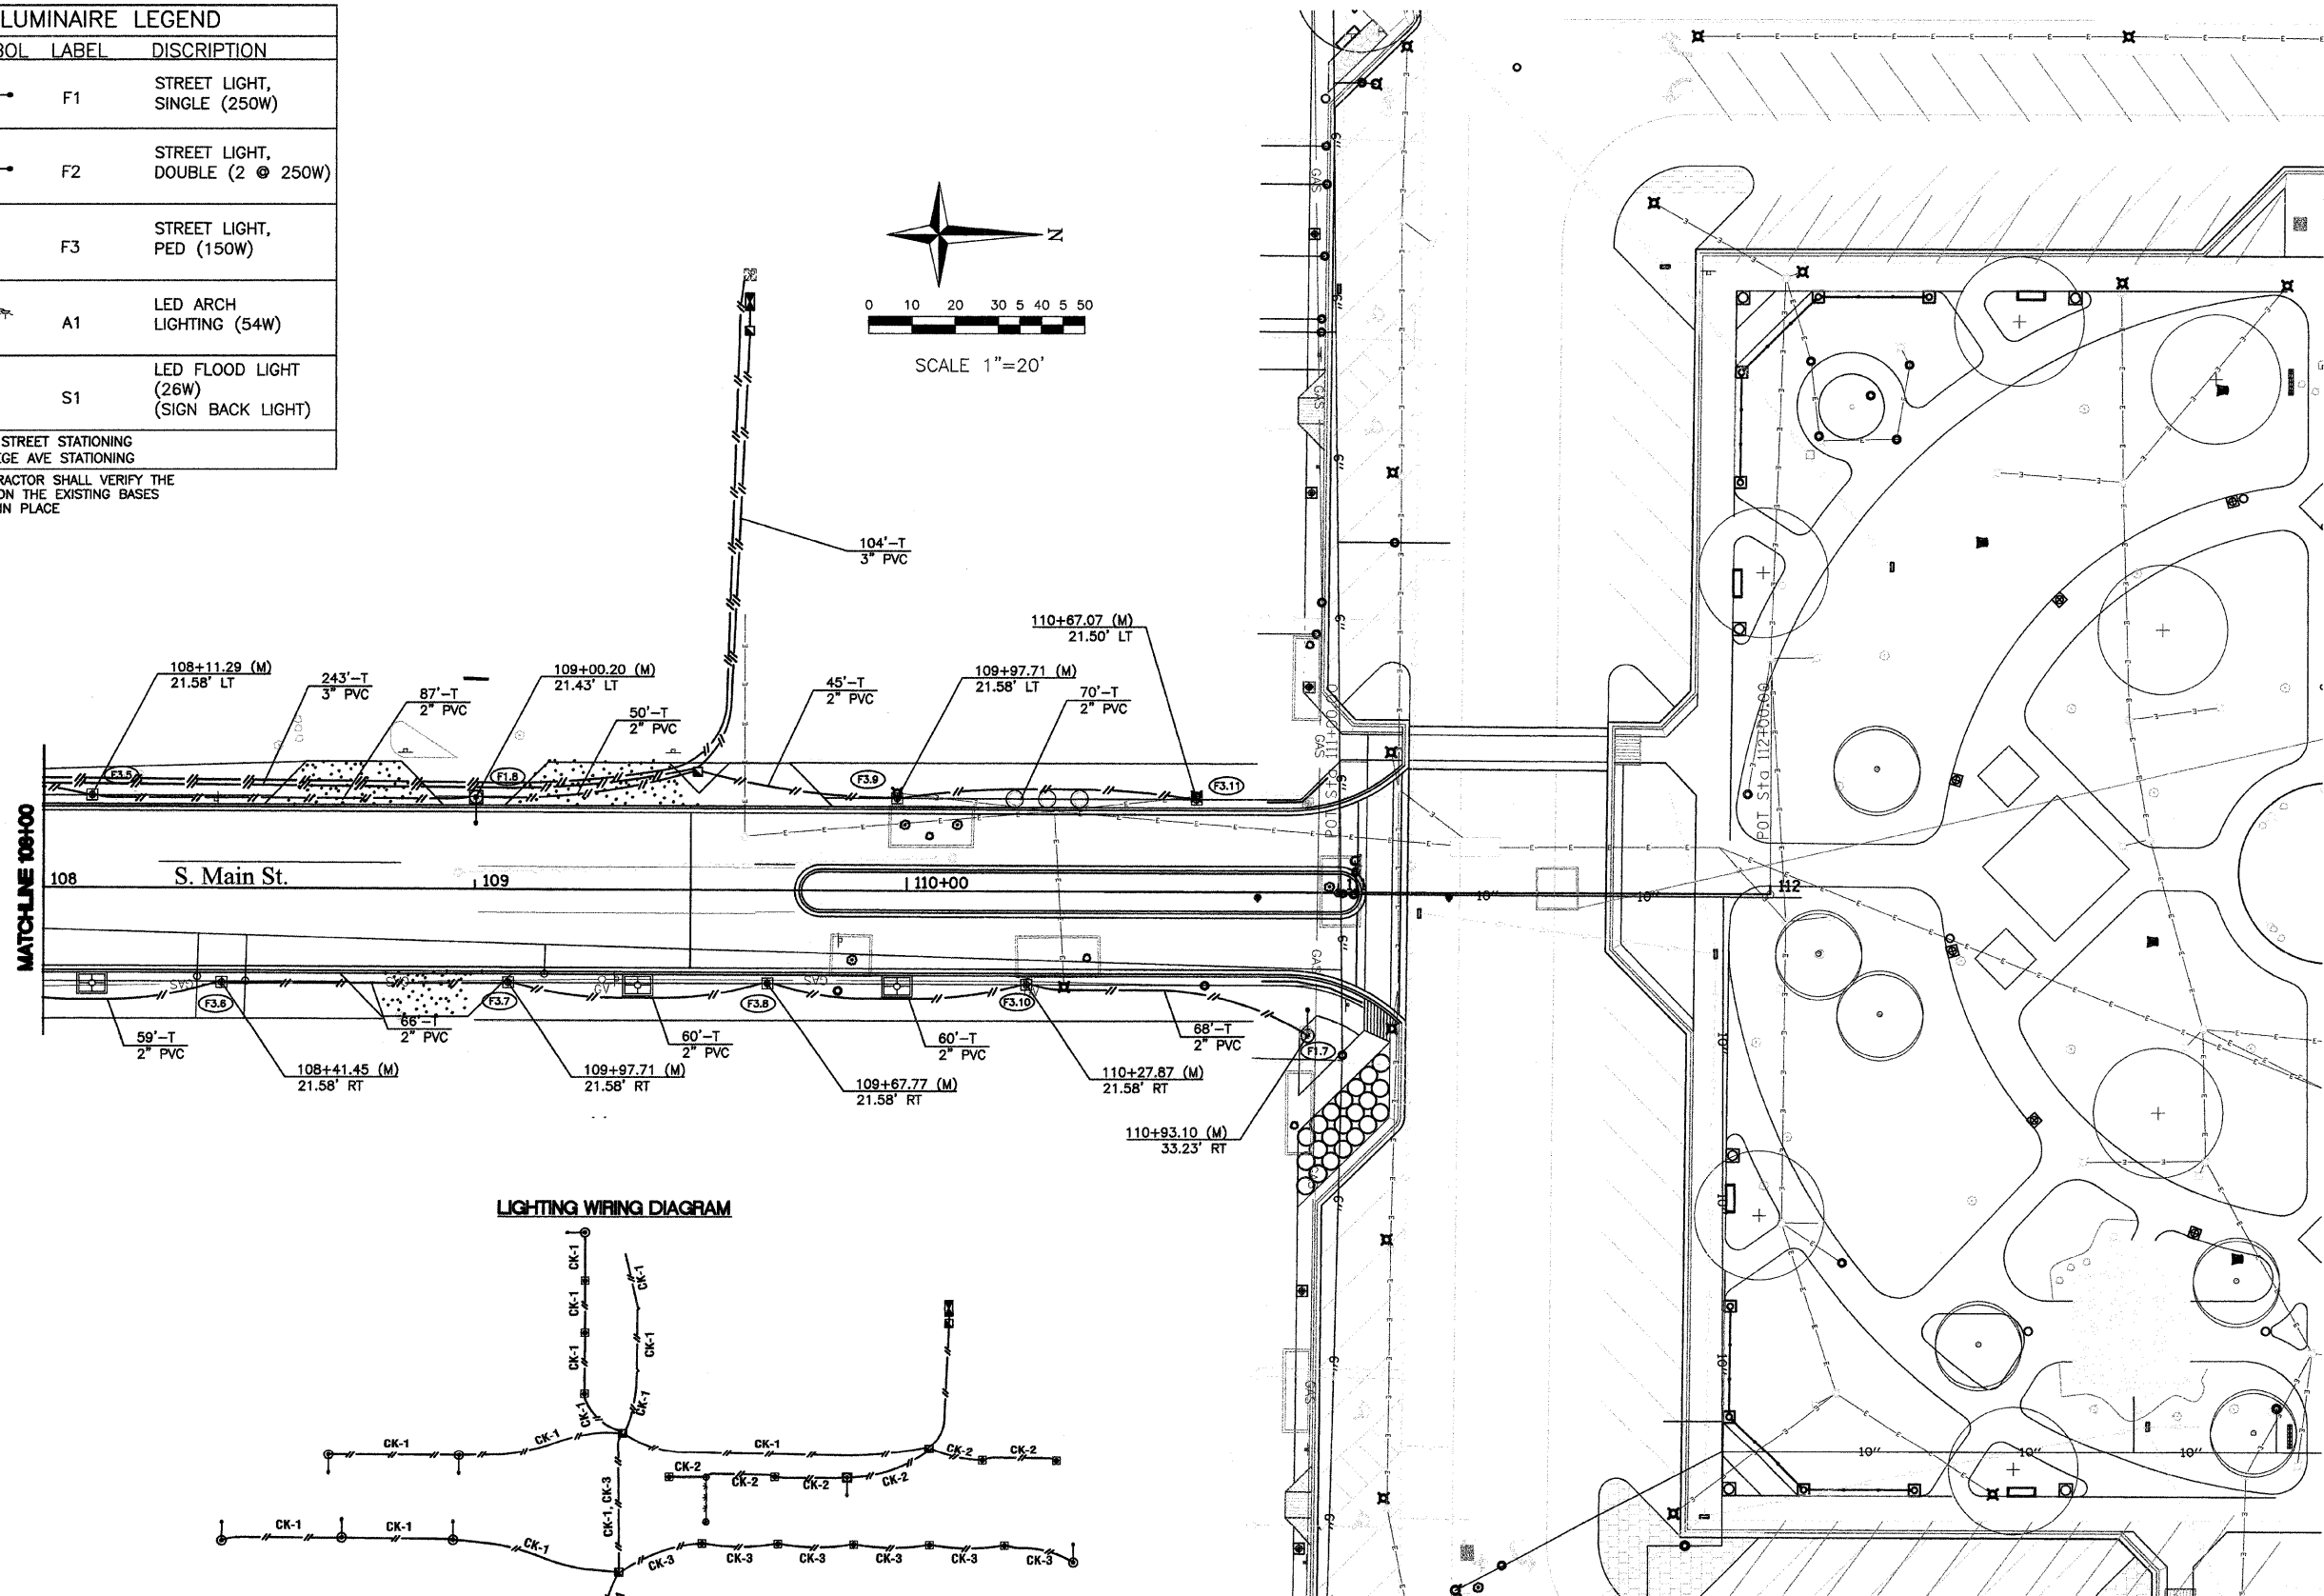


LUMINAIRE LEGEND		
SYMBOL	LABEL	DISCRIPTION
	F1	STREET LIGHT, SINGLE (250W)
	F2	STREET LIGHT, DOUBLE (2 @ 250W)
	F3	STREET LIGHT, PED (150W)
	A1	LED ARCH LIGHTING (54W)
	S1	LED FLOOD LIGHT (26W) (SIGN BACK LIGHT)
(M) - MAIN STREET STATIONING (C) - COLLEGE AVE STATIONING		

NOTE: THE CONTRACTOR SHALL VERIFY THE BOLT PATTERNS ON THE EXISTING BASES THAT ARE USED IN PLACE.

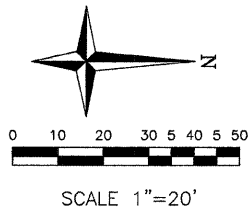

FILE NAME =
#FILEL#

USER NAME = #USER#
PLOT SCALE = #SCALE#
PLOT DATE = #DATE#

DESIGNED - EF
DRAWN - MH
CHECKED - RS
DATE - 2/21/11

REVISED -
REVISED -
REVISED -
REVISED -

**STATE OF ILLINOIS
DEPARTMENT OF TRANSPORTATION**

**CITY OF JACKSONVILLE DOWNTOWN STREETS CONSTRUCTION
SOUTH MAIN LIGHTING PLAN**

SCALE: SHEET NO. OF SHEETS STA. TO STA.

F.A. RTE.	SECTION	COUNTY	TOTAL SHEETS	SHEET NO.
N/A	10-00121-01-PV	MORGAN	77	41
CONTRACT NO. 9354				
ILLINOIS FED. AID PROJECT				