
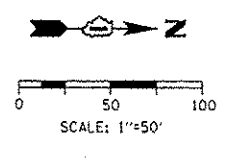


MATCH LINE STA 1803+50  
SEE SHT NO. 221

**EXISTING**

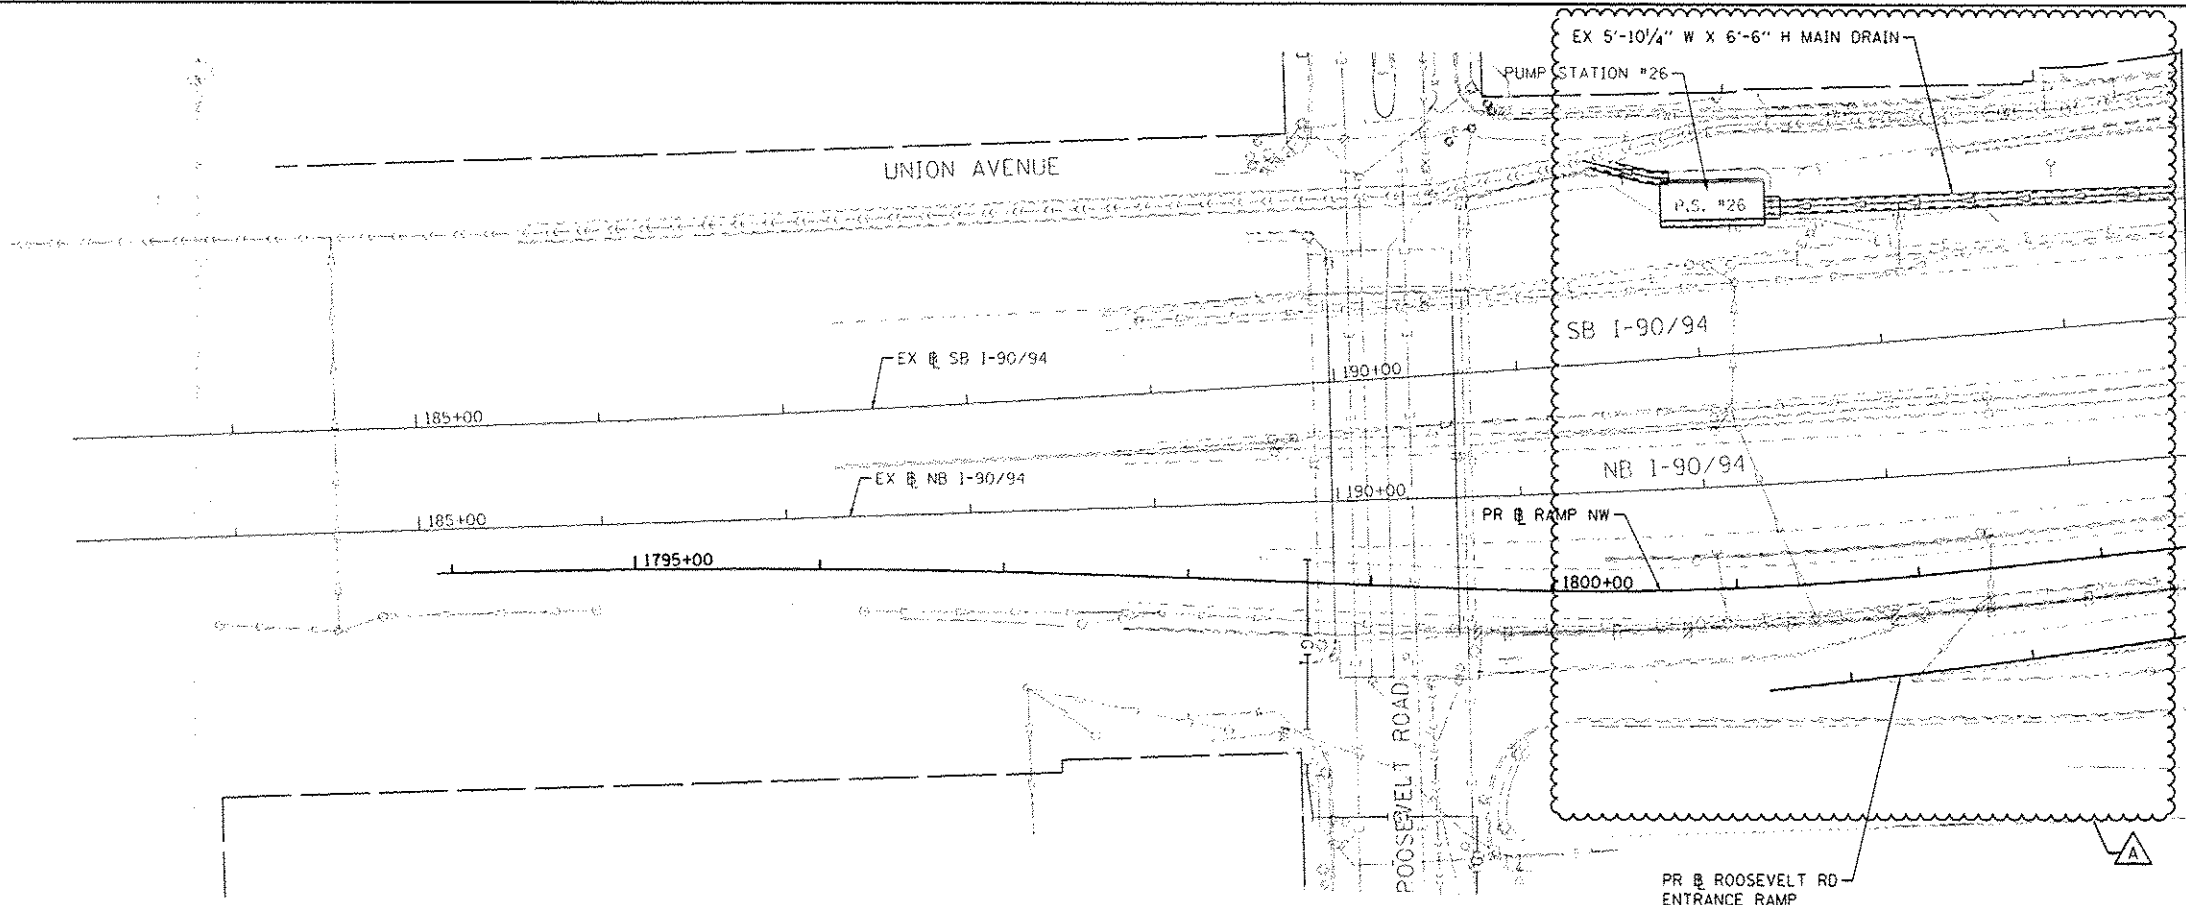

MATCH LINE STA 1803+50  
SEE SHT NO. 221

**PROPOSED**

FILE PATH: c:\p1\388291\project\assessmen\map\_data\p1\52020\Documents\101\Drainage\Transportation\62289438\_Civil\Drawings\Sheet\60W28.dwg  
 303 EAST WACKER DRIVE, SUITE 1400  
 CHICAGO, IL 60601-5076  
 PHONE: (312) 373-1700 FAX: (312) 373-4400



DESIGNED - DMS/AFC	REVISED - A 5/27/2014
DRAWN - DMS/AFC	REVISED -
CHECKED - EEE	REVISED -
DATE - 4/28/2014	REVISED -

USER NAME - schmanski	
PLDT SCALE - 1/8"=1'-0"	
PLDT DATE - 5/22/2014	

STATE OF ILLINOIS  
DEPARTMENT OF TRANSPORTATION

DRAINAGE AND UTILITY PLAN  
RAMP NW

SCALE: 1" = 50' SHEET 1 OF 6 SHEETS STA. 1802+75 TO STA. 1803+50

F.A.J. RTE.	SECTION	COUNTY	TOTAL SHEETS	SHEET NO.
90/94/290	2013-010R	COOK	747	220
CONTRACT NO. 60W28				
ILLINOIS FED. AID PROJECT				