 
 



 
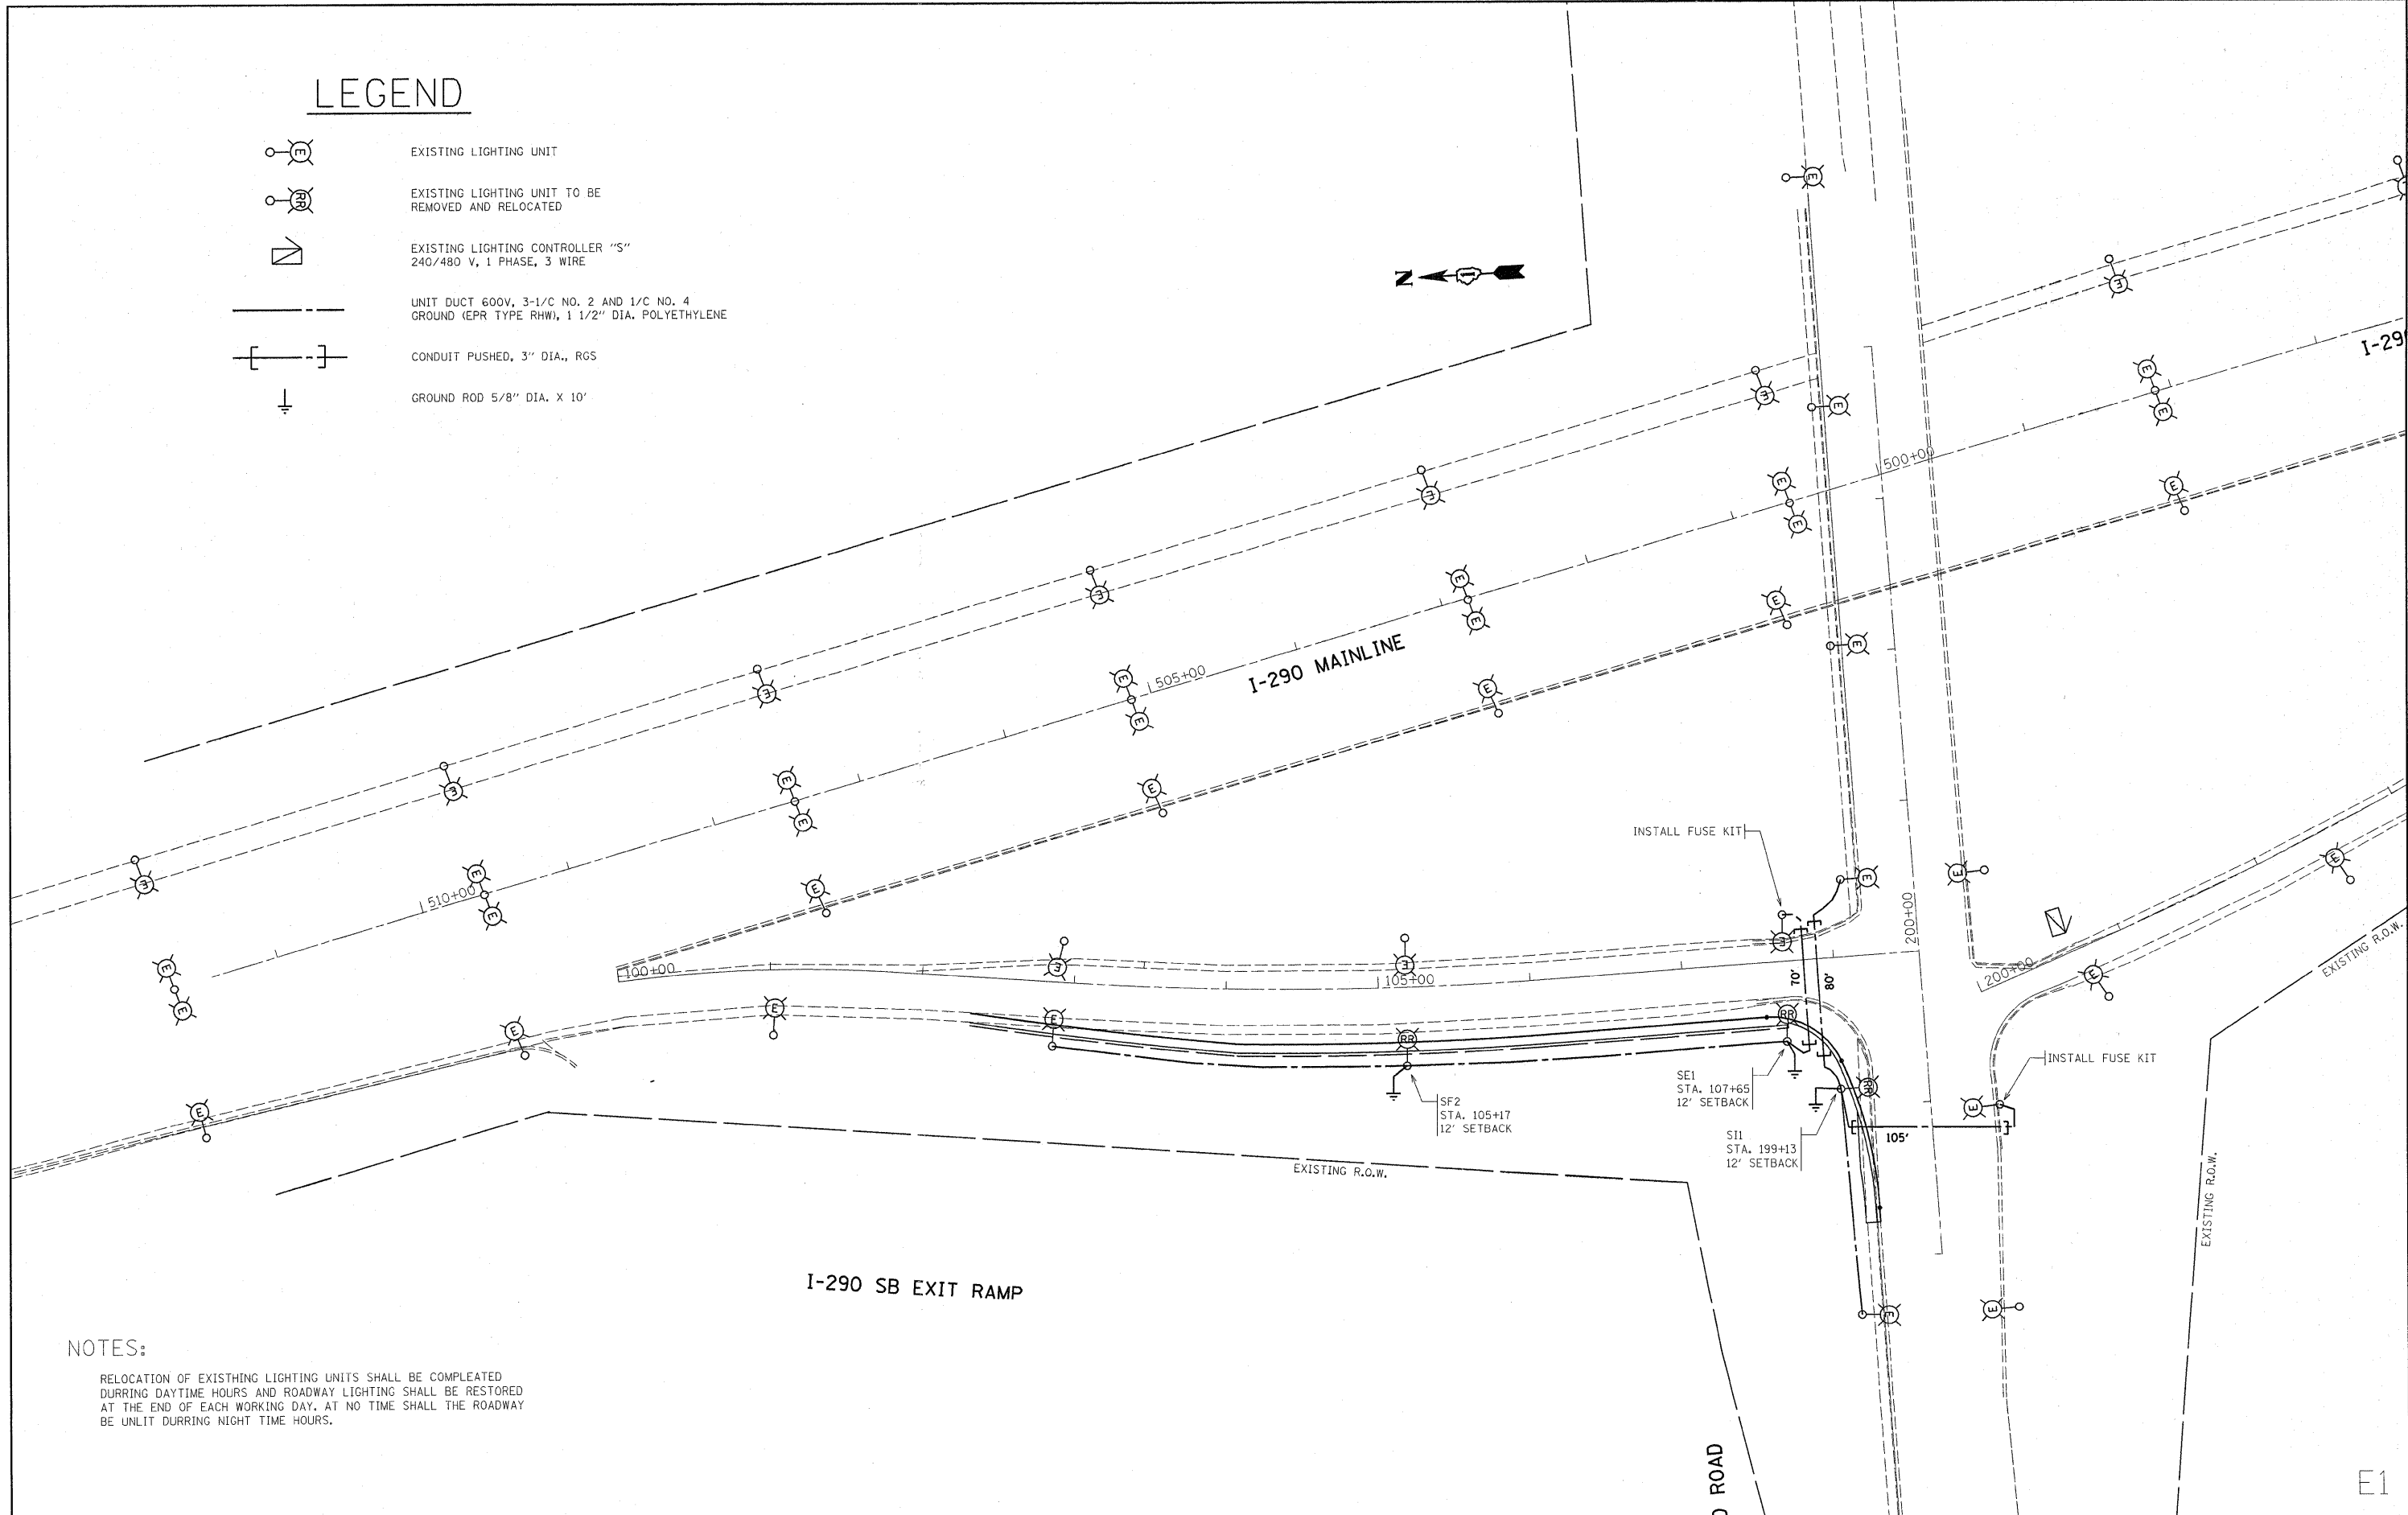


# LEGEND

-  EXISTING LIGHTING UNIT
-  EXISTING LIGHTING UNIT TO BE REMOVED AND RELOCATED
-  EXISTING LIGHTING CONTROLLER "S"  
240/480 V, 1 PHASE, 3 WIRE
-  UNIT DUCT 600V, 3-1/2" NO. 2 AND 1/2" NO. 4  
GROUND (EPR TYPE RHW), 1 1/2" DIA. POLYETHYLENE
-  CONDUIT PUSHED, 3" DIA., RGS
-  GROUND ROD 5/8" DIA. X 10'



## NOTES:

RELOCATION OF EXISTING LIGHTING UNITS SHALL BE COMPLETED DURING DAYTIME HOURS AND ROADWAY LIGHTING SHALL BE RESTORED AT THE END OF EACH WORKING DAY. AT NO TIME SHALL THE ROADWAY BE UNLIT DURING NIGHT TIME HOURS.

FILE NAME =	USER NAME = kellers	DESIGNED -	REVISED -
cs:\pw_work\pwidot\kellers\10189143\141023-light.dgn		DRAWN - MP	REVISED -
PLOT SCALE = 50.0000' / IN.		CHECKED -	REVISED -
PLOT DATE = 5/7/2010		DATE -	REVISED -

**STATE OF ILLINOIS  
DEPARTMENT OF TRANSPORTATION**

### I-290 AND BIESTERFIELD ROAD LIGHTING PLANS

SCALE: 1" = 50'    SHEET NO. 1 OF 2 SHEETS    STA.    TO STA.

F.A.I. RTE.	SECTION	COUNTY	TOTAL SHEETS	SHEET NO.
290	0101-311 HBK-1	COOK	44	25
ILLINOIS FED. AID PROJECT			CONTRACT NO. 60J32	

E1