



TYPICAL SPLICE DETAIL

N.T.S.

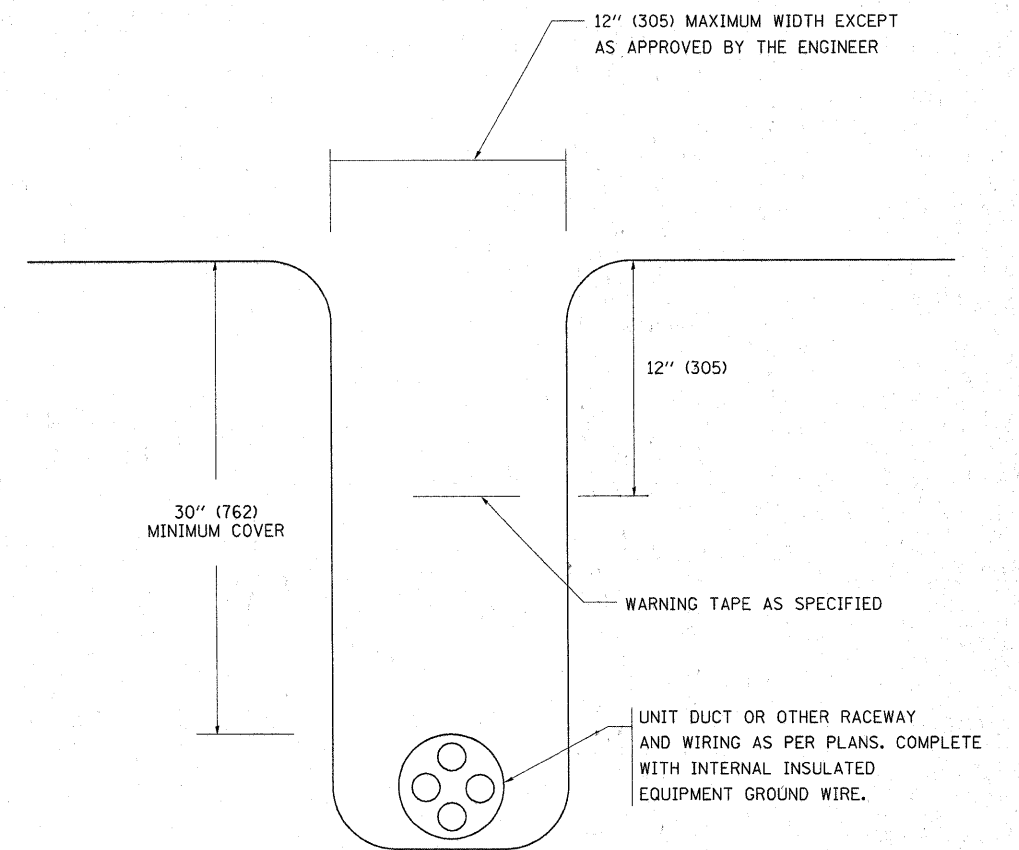

TYPICAL WIRING IN TRENCH DETAIL

N.T.S.

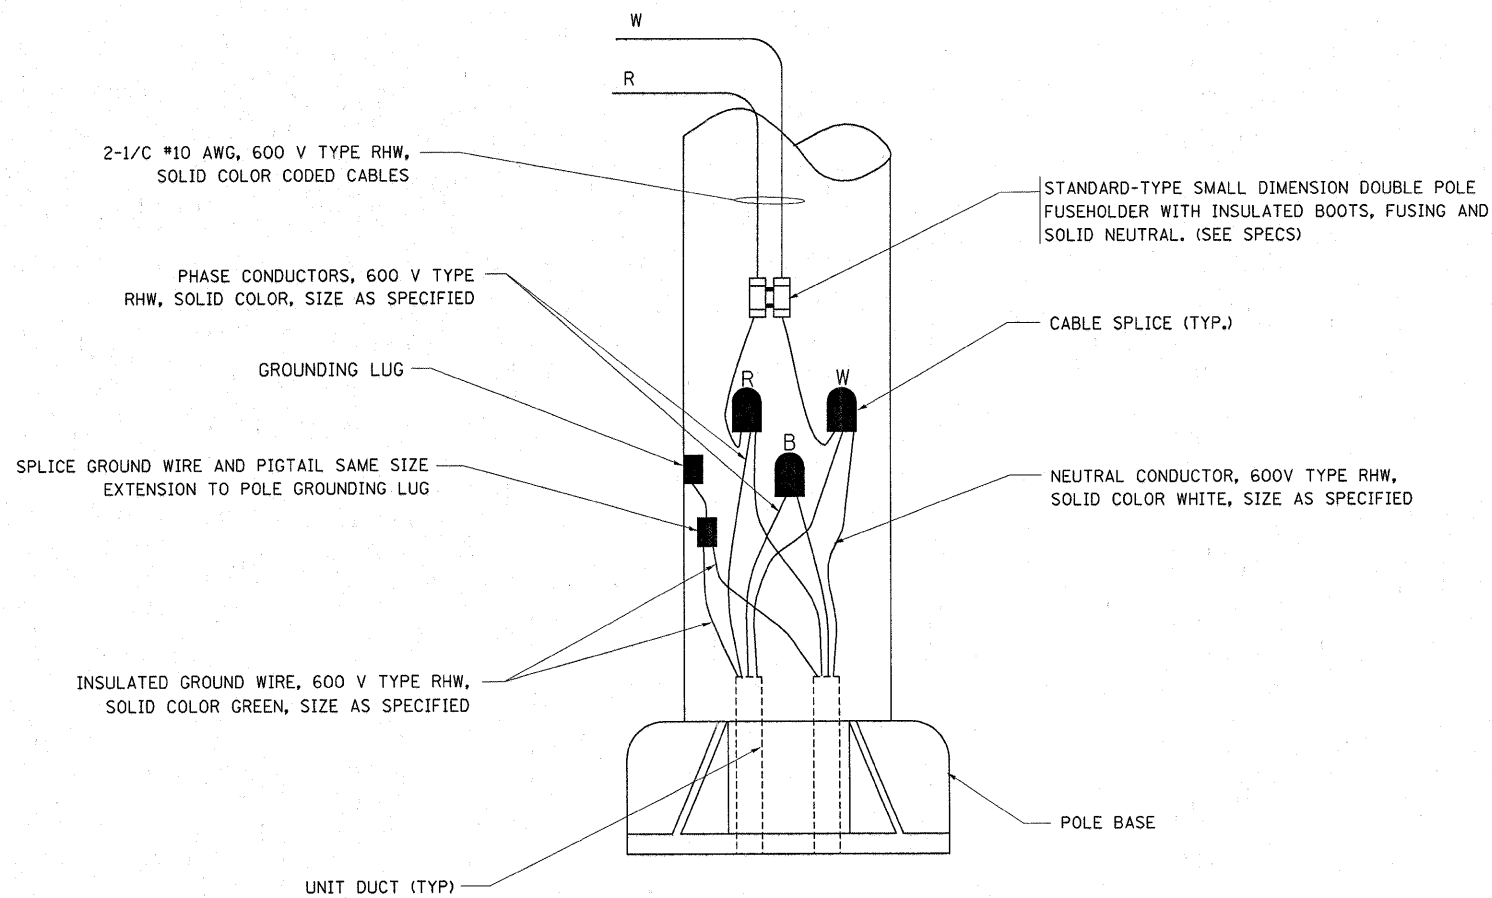

POLE WIRING DETAIL

N.T.S.

FILE NAME =	USER NAME = kellers	DESIGNED -	REVISED - 08-08-03	STATE OF ILLINOIS DEPARTMENT OF TRANSPORTATION	MISC. ELECTRICAL DETAILS SHEET A				F.A.I. RTE.	SECTION	COUNTY	TOTAL SHEETS	SHEET NO.
c:\pw_work\PWEDDT\KELLERS\0155790\Dist	td.dgn	DRAWN -	REVISED -		290	0101-311 HBK-1	COOK	44	29				
PLOT SCALE = 50,0000 / IN.		CHECKED -	REVISED -		BE-702		CONTRACT NO. 60J32						
PLOT DATE = 4/1/2010		DATE -	REVISED -		SCALE: NONE	SHEET NO. 1 OF 1 SHEETS	STA.	TO STA.	FED. ROAD DIST. NO. 1 ILLINOIS FED. AID PROJECT				