


IDOT SAINT CHARLES MAINTENANCE YARD

PROP PRECAST REINFORCED CONC FES 36"
PROP GRATING FOR CONC FES 36"
INV = 730.8

STONE RIPRAP, CLASS B4 (15 SOYD)
FILTER FABRIC (15 SOYD)

MAN TA 6 DIA TIF OL
STA 17+27, 3.61' LT
RIM = 735.40
INV E = 731.6
INV W = 731.6

BUILDING

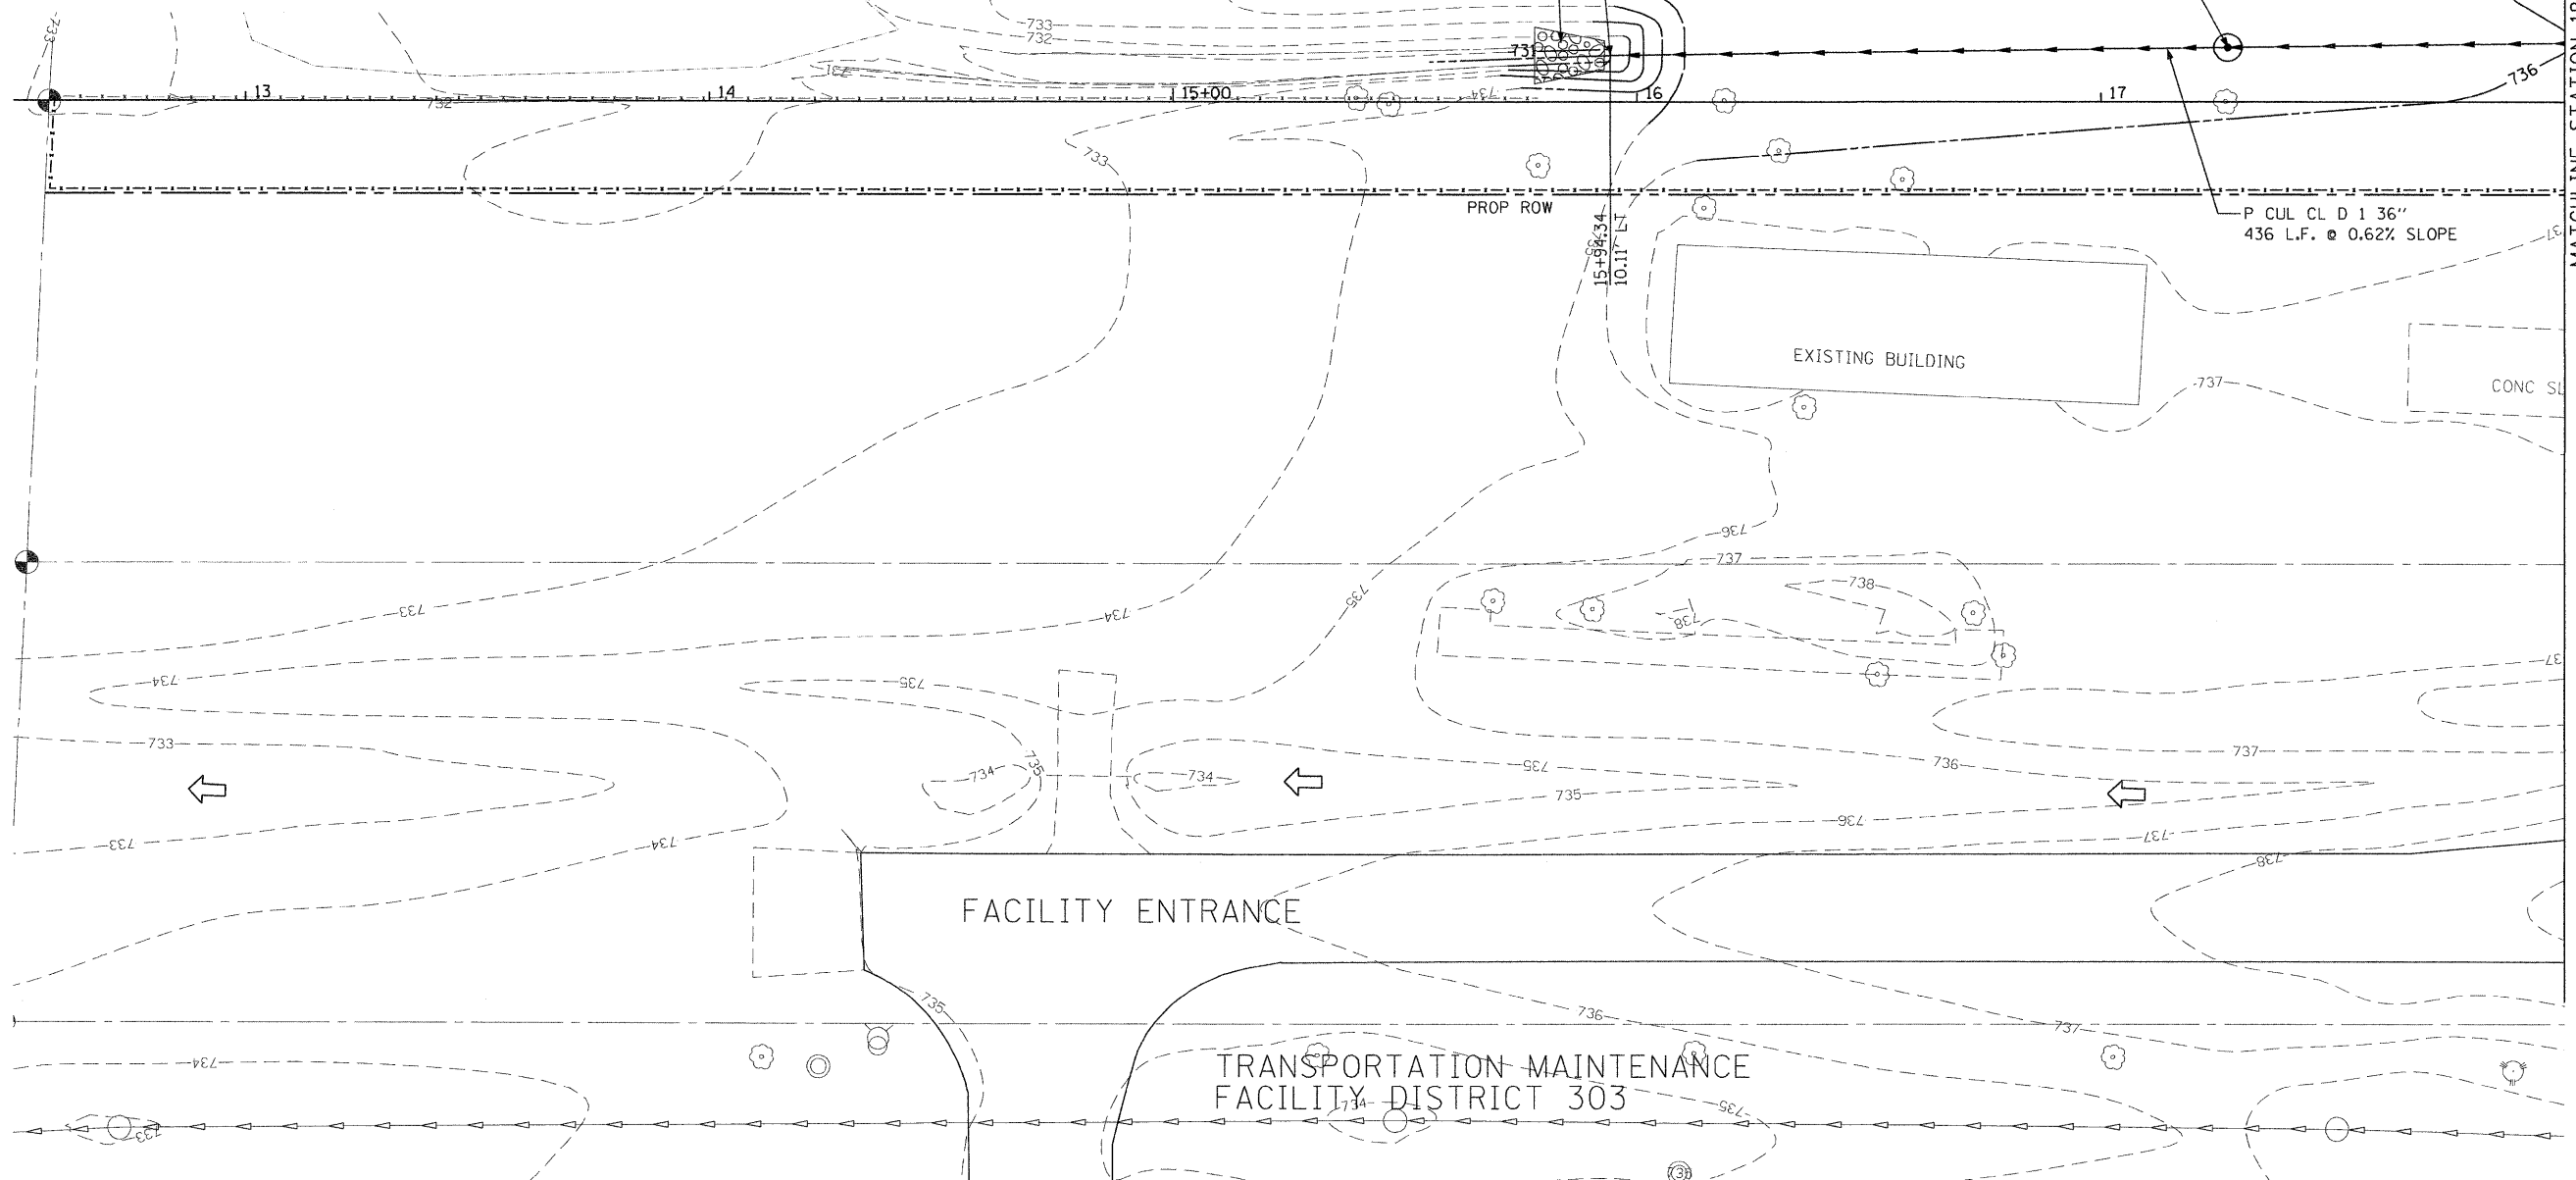

MATCHLINE STATION 18+00

FILE NAME = F:\2009\ME09006-Var\or-Phil\CADD\W013-IL38\Shs\DI60K16-shs-drain-01-28.dgn
USER NAME = Millennium Professional Services



200 22ND Street, Suite 216, Lombard, IL 60148
630.705.0110 voice, 630.839.2566 fax
WWW.MPS-IL.COM

MILLENNIA PROFESSIONAL SERVICES

DESIGNED - CJD	REVISED -
DRAWN - CJD	REVISED -
CHECKED - TVN	REVISED -
DATE - 5/18/2010	REVISED -

**STATE OF ILLINOIS
DEPARTMENT OF TRANSPORTATION**

**ILLINOIS ROUTE 38
AT PECK ROAD**

DRAINAGE PLAN

SCALE: 1"=20' SHEET NO. OF SHEETS STA. 12+50 TO STA. 18+00

F.A.P. RTE.	SECTION	COUNTY	TOTAL SHEETS	SHEET NO.
347	4 R-T	KANE	20	10
CONTRACT NO. 60K16				

DRN-01

F:\2009\ME09006-Var\or-Phil\CADD\W013-IL38\Shs\DI60K16-shs-drain-01-28.dgn