
 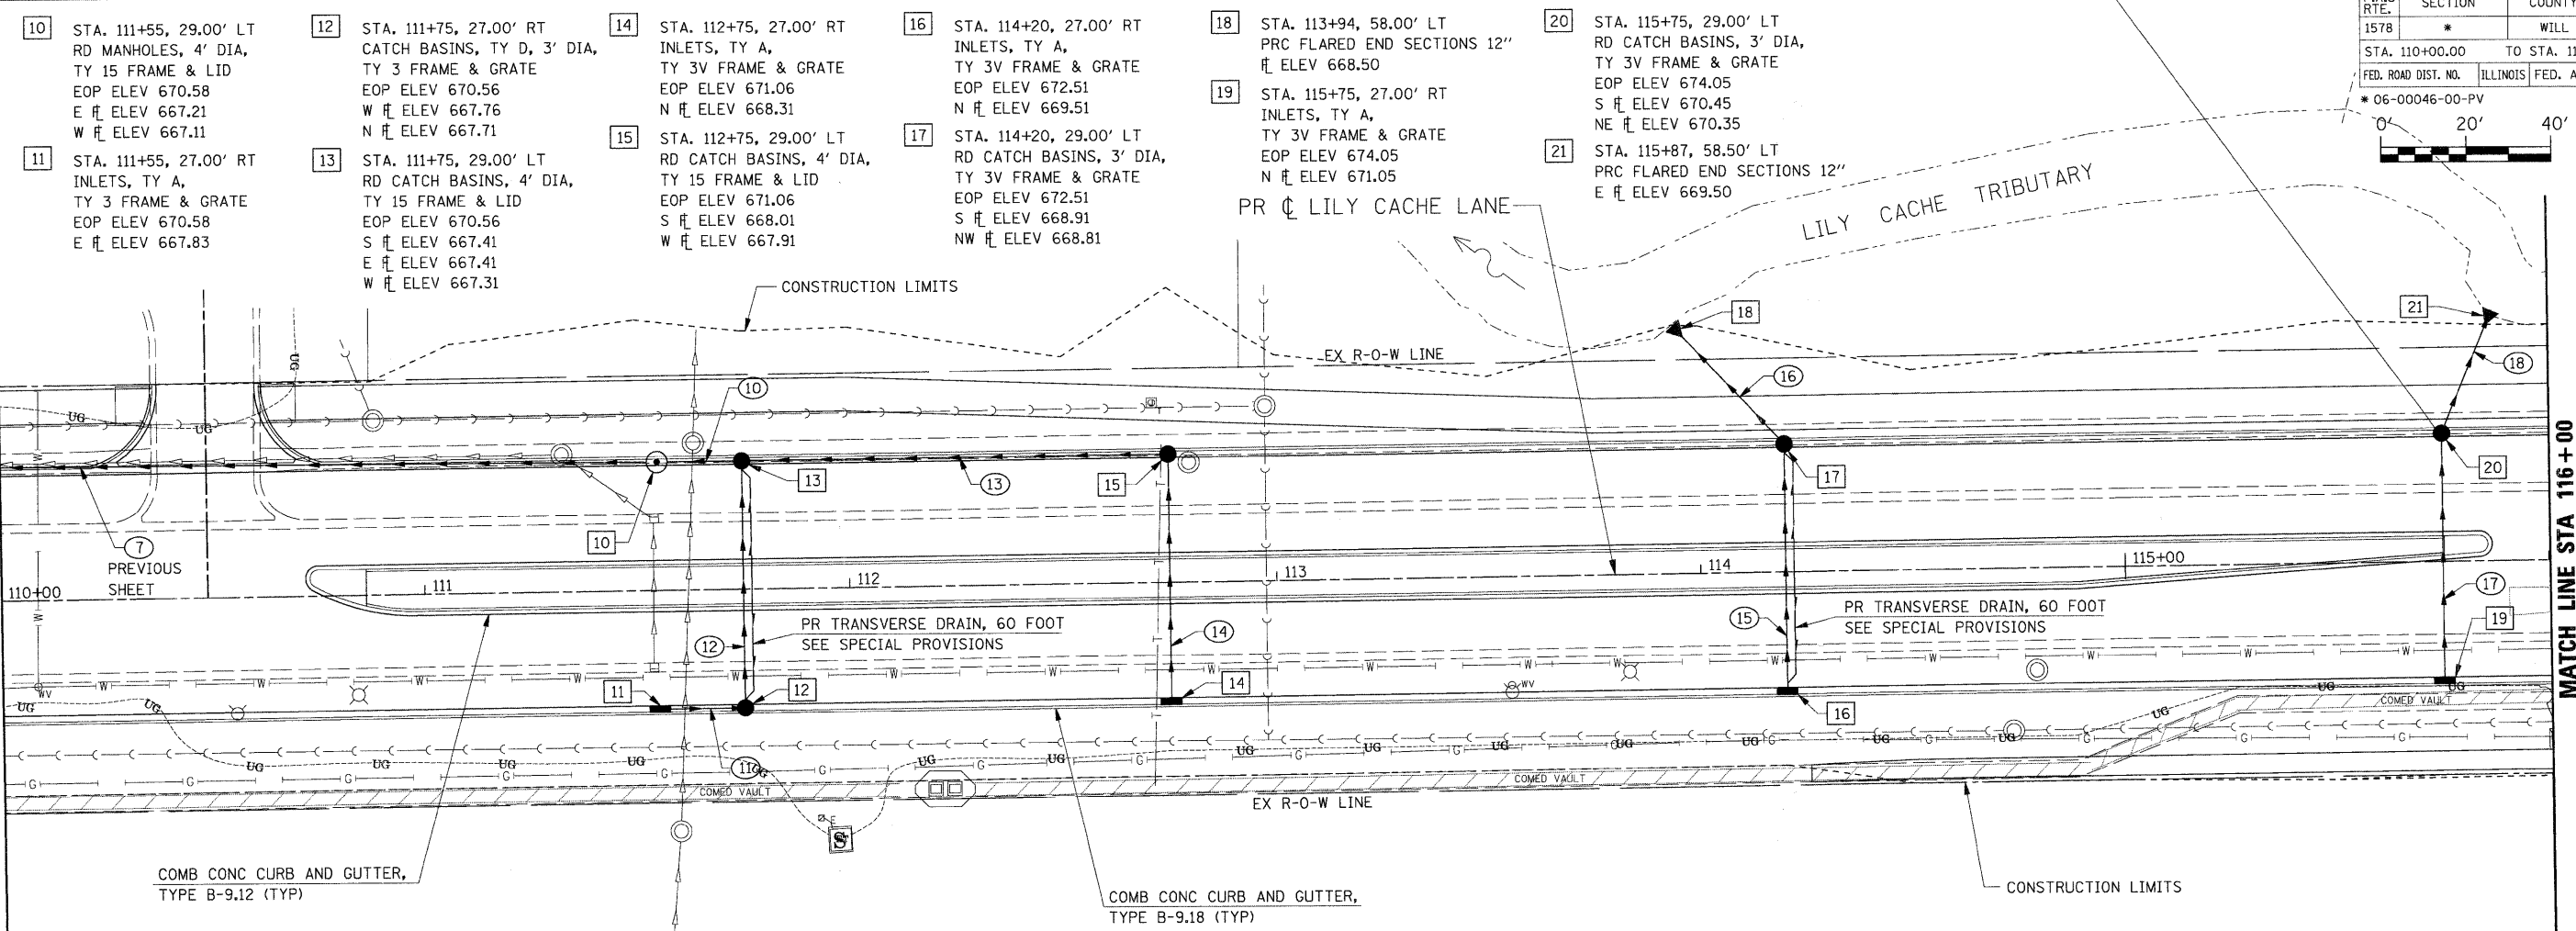
 


F.A.U. RTE.	SECTION	COUNTY	TOTAL SHEETS	SHEET NO.
1578	*	WILL	155	90

STA. 110+00.00 TO STA. 116+00.00

FED. ROAD DIST. NO. ILLINOIS FED. AID PROJECT


\* 06-00046-00-PV



- ⑩ STORM SEWERS, CL A, TY 1 15" 20' @ 0.50%
- ⑪ STORM SEWERS, CL A, TY 1 12" 20' @ 0.35%
- ⑫ STORM SEWERS, CL A, TY 1 12" 60' @ 0.50%
- ⑬ STORM SEWERS, CL A, TY 1 15" 100' @ 0.50%
- ⑭ STORM SEWERS, CL A, TY 1 12" 60' @ 0.50%
- ⑮ STORM SEWERS, CL A, TY 1 12" 60' @ 1.00%
- ⑯ STORM SEWERS, CL A, TY 1 12" 39' @ 0.80%
- ⑰ STORM SEWERS, CL A, TY 1 12" 60' @ 1.00%
- ⑱ STORM SEWERS, CL A, TY 1 12" 32' @ 2.66%

**LEGEND**

- ① STORM SEWER STRUCTURE
- ① STORM SEWER PIPE

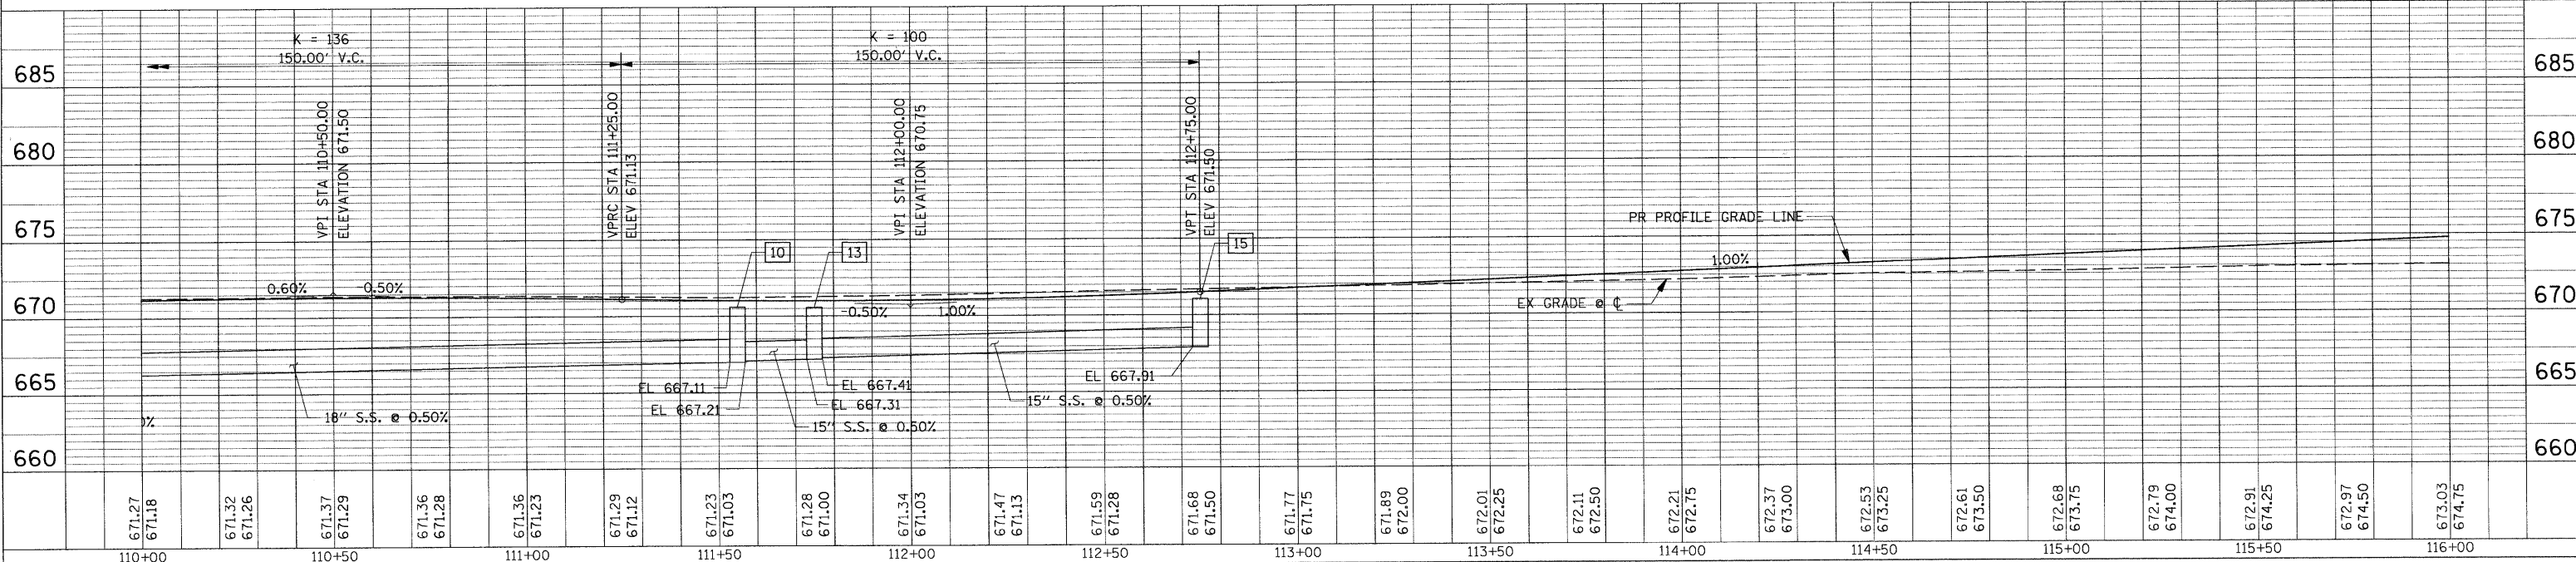

DRAINAGE & UTILITY PLAN STA 110+00 TO STA 116+00

NOTE BOOK ALIGNMENT CHECKED BY: DATE: FILE NAME: NO.:

NOTE BOOK GRADES CHECKED BY: DATE: FILE NAME: NO.:

PLOT DATE: #DATE# FILE NAME: #FILE# PLOT SCALE: #SCALE# USER NAME: #USER#

#FILES#