


F.A.U. RTE.	SECTION	COUNTY	TOTAL SHEETS	SHEET NO.
1578	*	WILL	155	93

STA. 127+60.00 TO STA. 133+35.00
 FED. ROAD DIST. NO. ILLINOIS FED. AID PROJECT
 * 06-00046-00-PV

NOTE BOOK ALIGNMENT CHECKED
 NO. _____
 FILE NAME _____
 USER NAME _____


NOTE BOOK GRADES CHECKED
 NO. _____
 FILE NAME _____
 USER NAME _____

PLOT DATE = #DATE#
 FILE NAME = #FILE#
 PLOT SCALE = #SCALE#
 USER NAME = #USER#

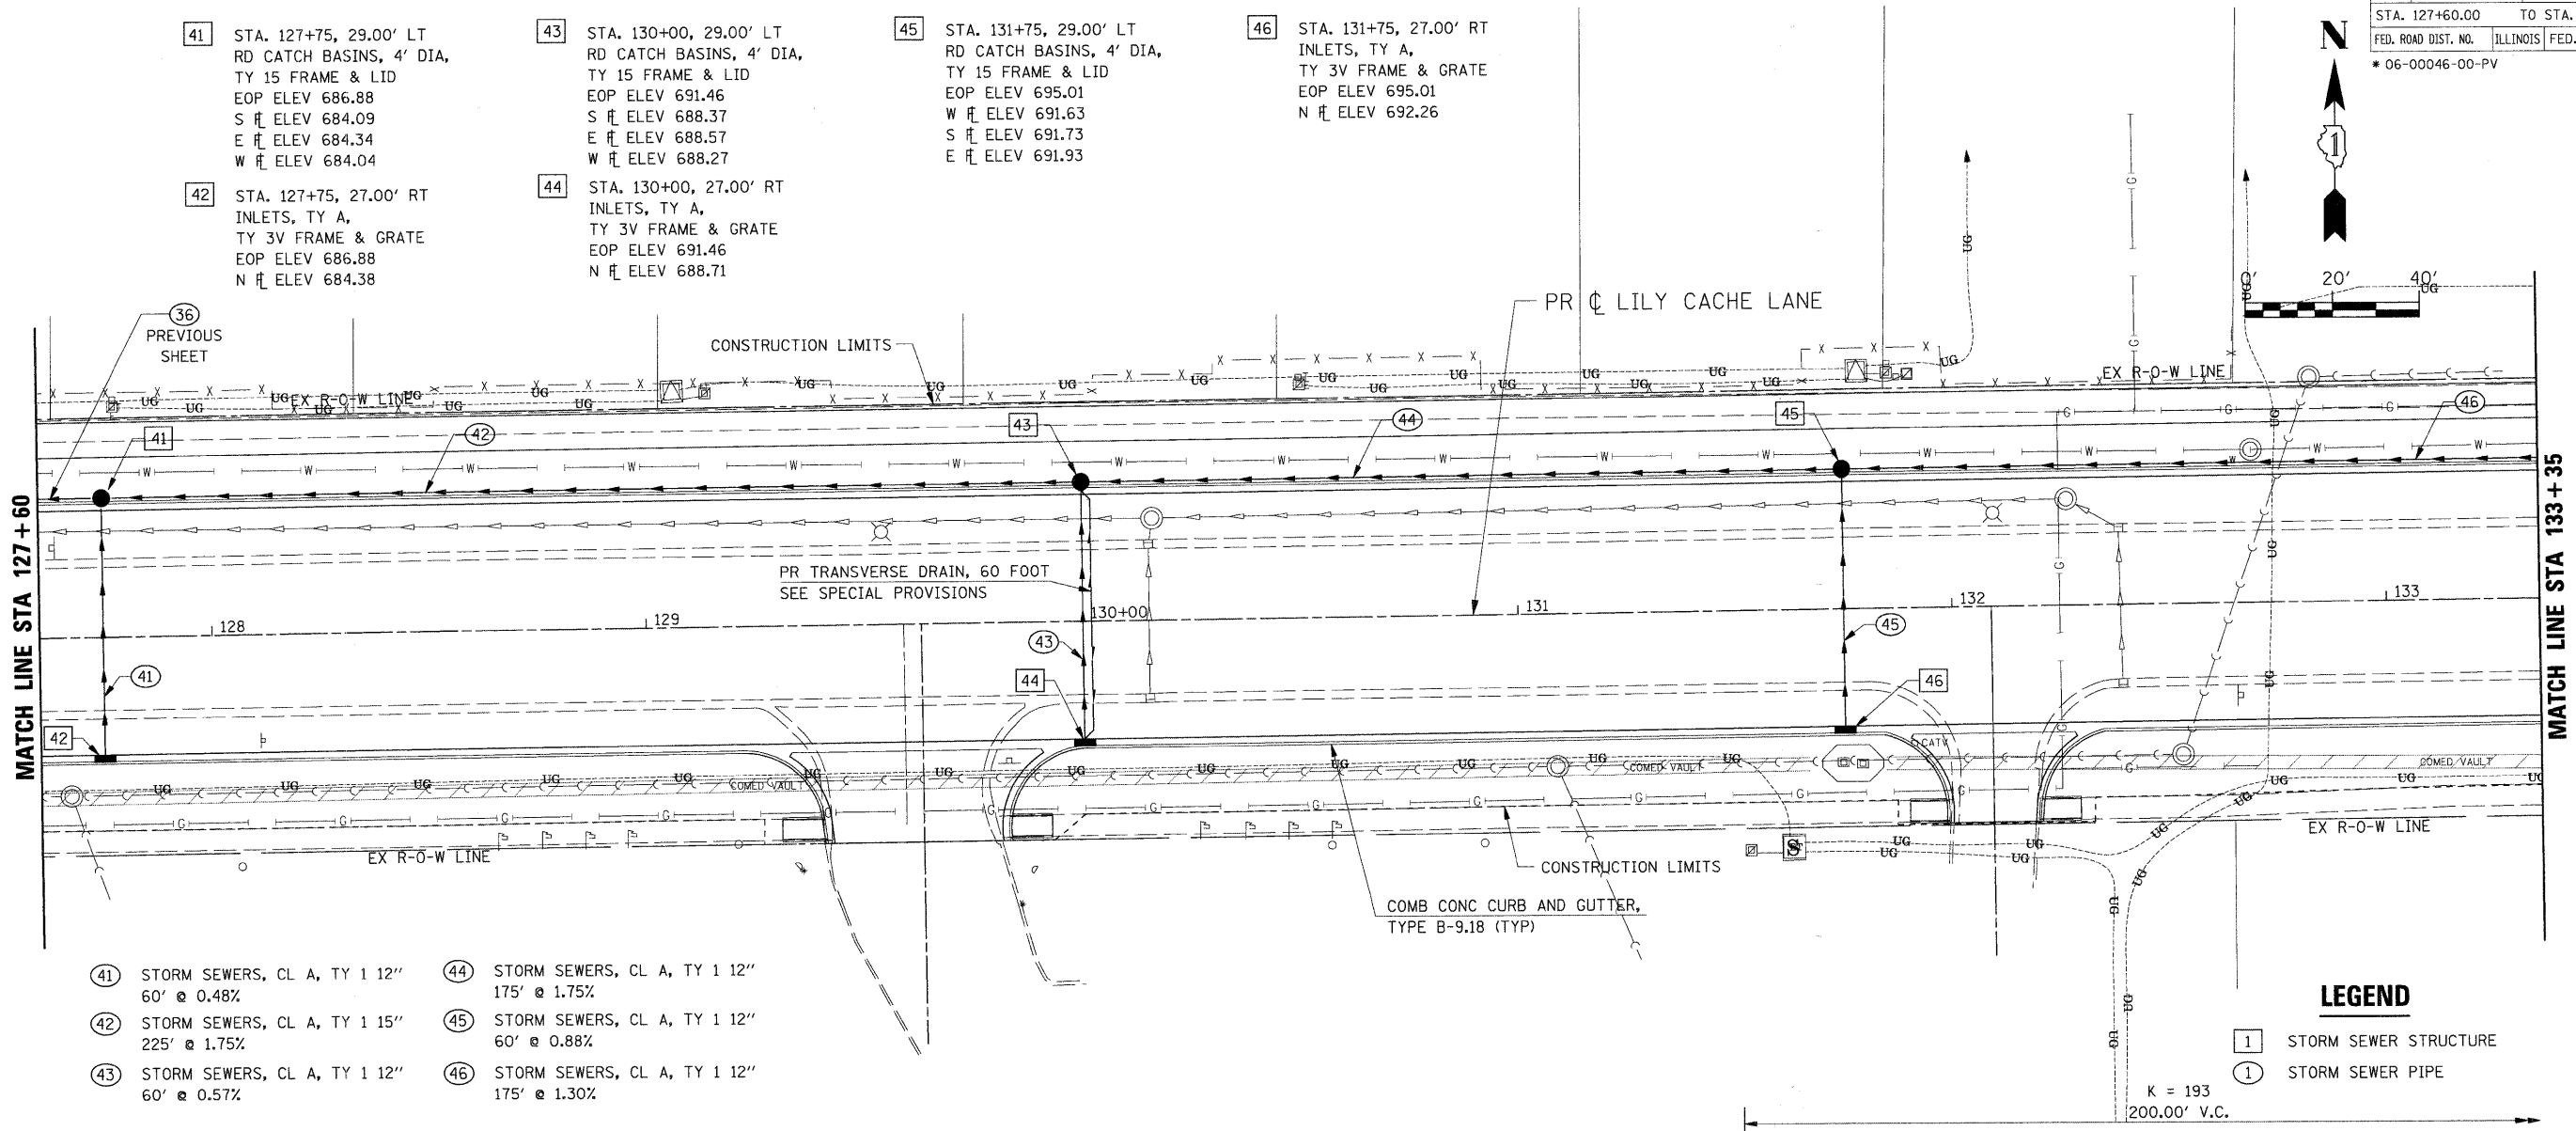

- | | |
|---|---|
| 41 STORM SEWERS, CL A, TY 1 12"
60' @ 0.48% | 44 STORM SEWERS, CL A, TY 1 12"
175' @ 1.75% |
| 42 STORM SEWERS, CL A, TY 1 15"
225' @ 1.75% | 45 STORM SEWERS, CL A, TY 1 12"
60' @ 0.88% |
| 43 STORM SEWERS, CL A, TY 1 12"
60' @ 0.57% | 46 STORM SEWERS, CL A, TY 1 12"
175' @ 1.30% |

- LEGEND**
- 1 STORM SEWER STRUCTURE
 - 1 STORM SEWER PIPE

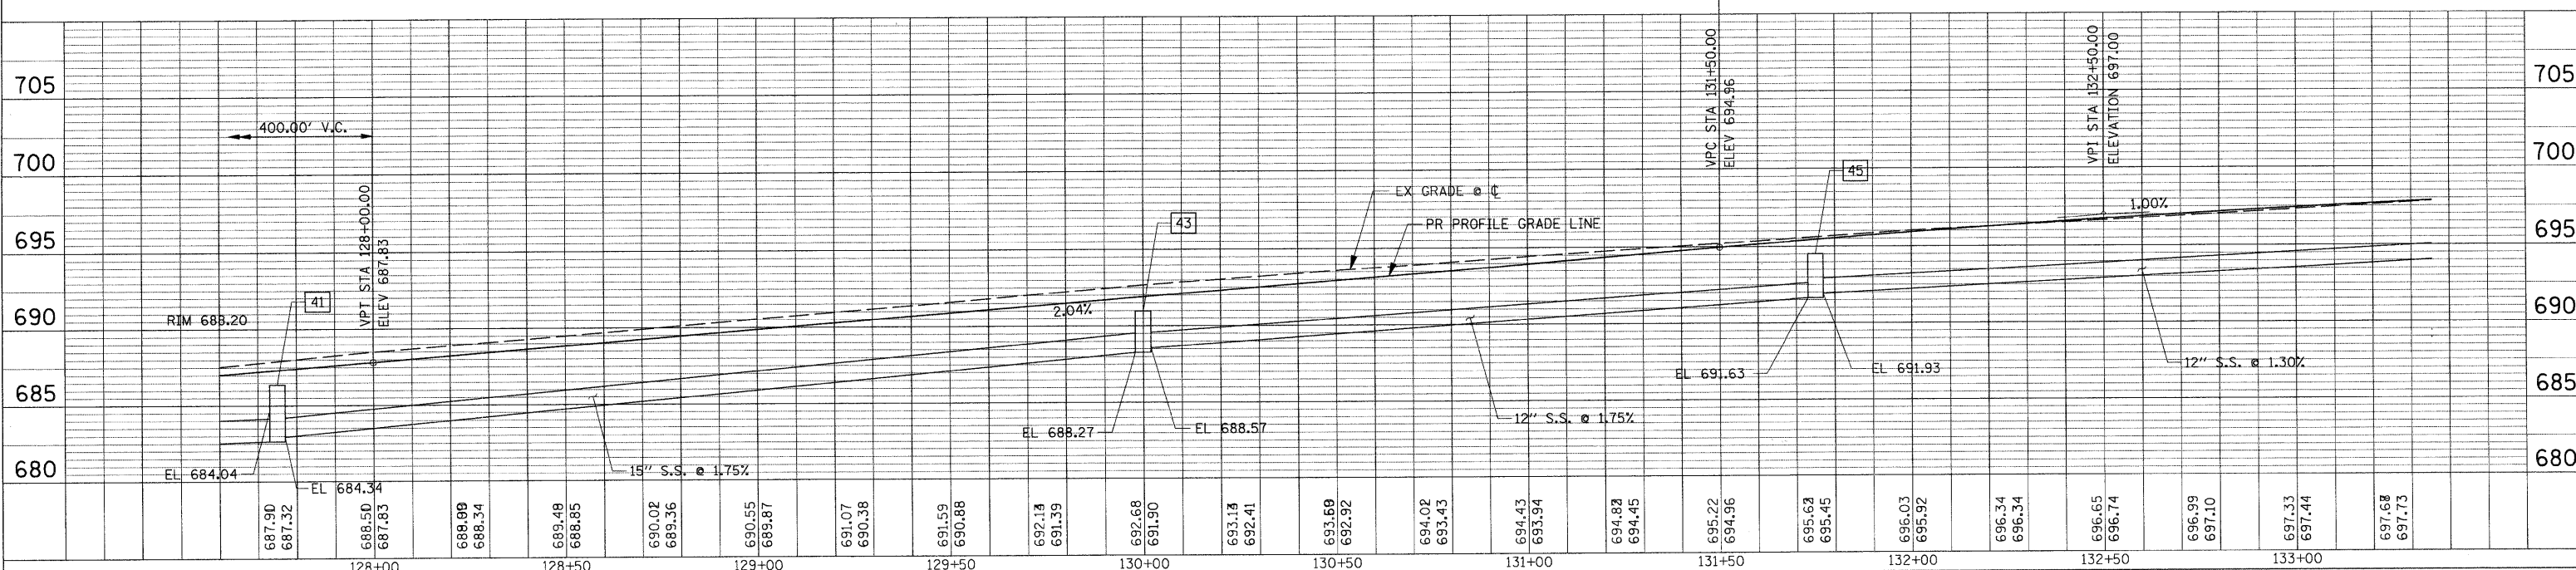

DRAINAGE & UTILITY PLAN STA 127+60 TO STA 133+35