 





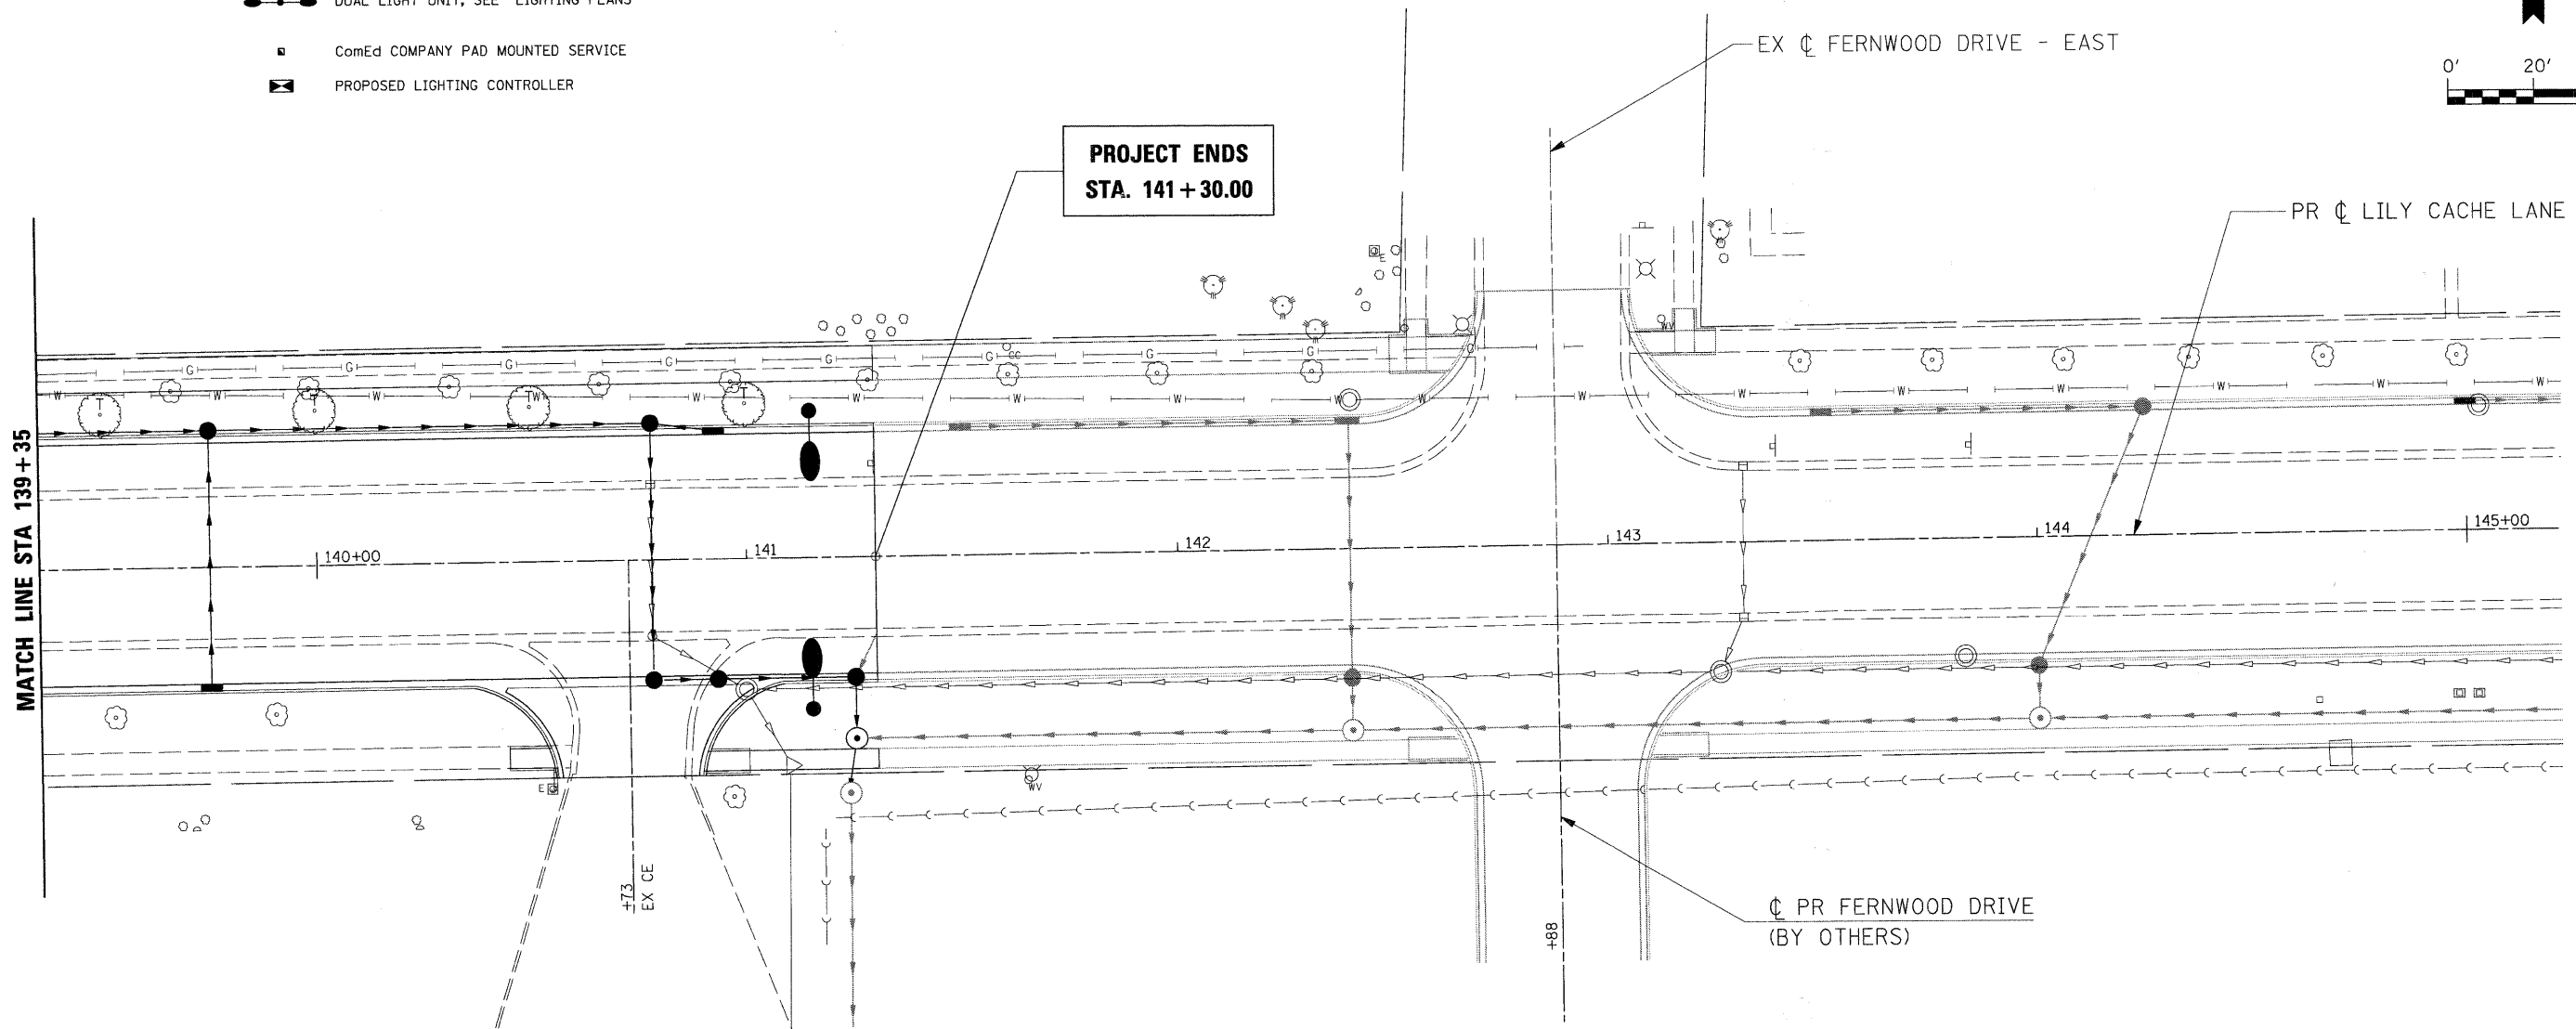
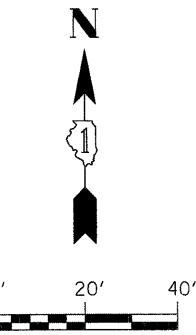


F.A.U. R.T.E.	SECTION	COUNTY	TOTAL SHEETS	SHEET NO.
1578	*	WILL	155	118
STA.		TO STA.		
FED. ROAD DIST. NO.		ILLINOIS	FED. AID PROJECT	

* 06-00046-00-PV

LANDSCAPING LEGEND

-  INDICATES PROPOSED SODDING AREAS
-  PROPOSED TREES
SEE "GENERAL NOTES FOR TREE PLANTING AND LANDSCAPING"
FOR APPROVED TREES AND INSTRUCTIONS.
-  LIGHT UNIT, SEE "LIGHTING PLANS"
-  DUAL LIGHT UNIT, SEE "LIGHTING PLANS"
-  ComEd COMPANY PAD MOUNTED SERVICE
-  PROPOSED LIGHTING CONTROLLER



REVISIONS	
NAME	DATE

ILLINOIS DEPARTMENT OF TRANSPORTATION

LANDSCAPING PLAN

STA 139+35 TO STA 145+10

SCALE: 1" = 20'

DATE: APRIL 9, 2009

DRAWN BY: JEB

CHECKED BY: CMS

PLOT DATE = 4/13/2009
 FILE NAME = G:\S\65924\CAD\6024.LL07.SHT
 PLOT SCALE = 28.2951 / IN.
 USER NAME = IE Consultants

6024.LL07.SHT