
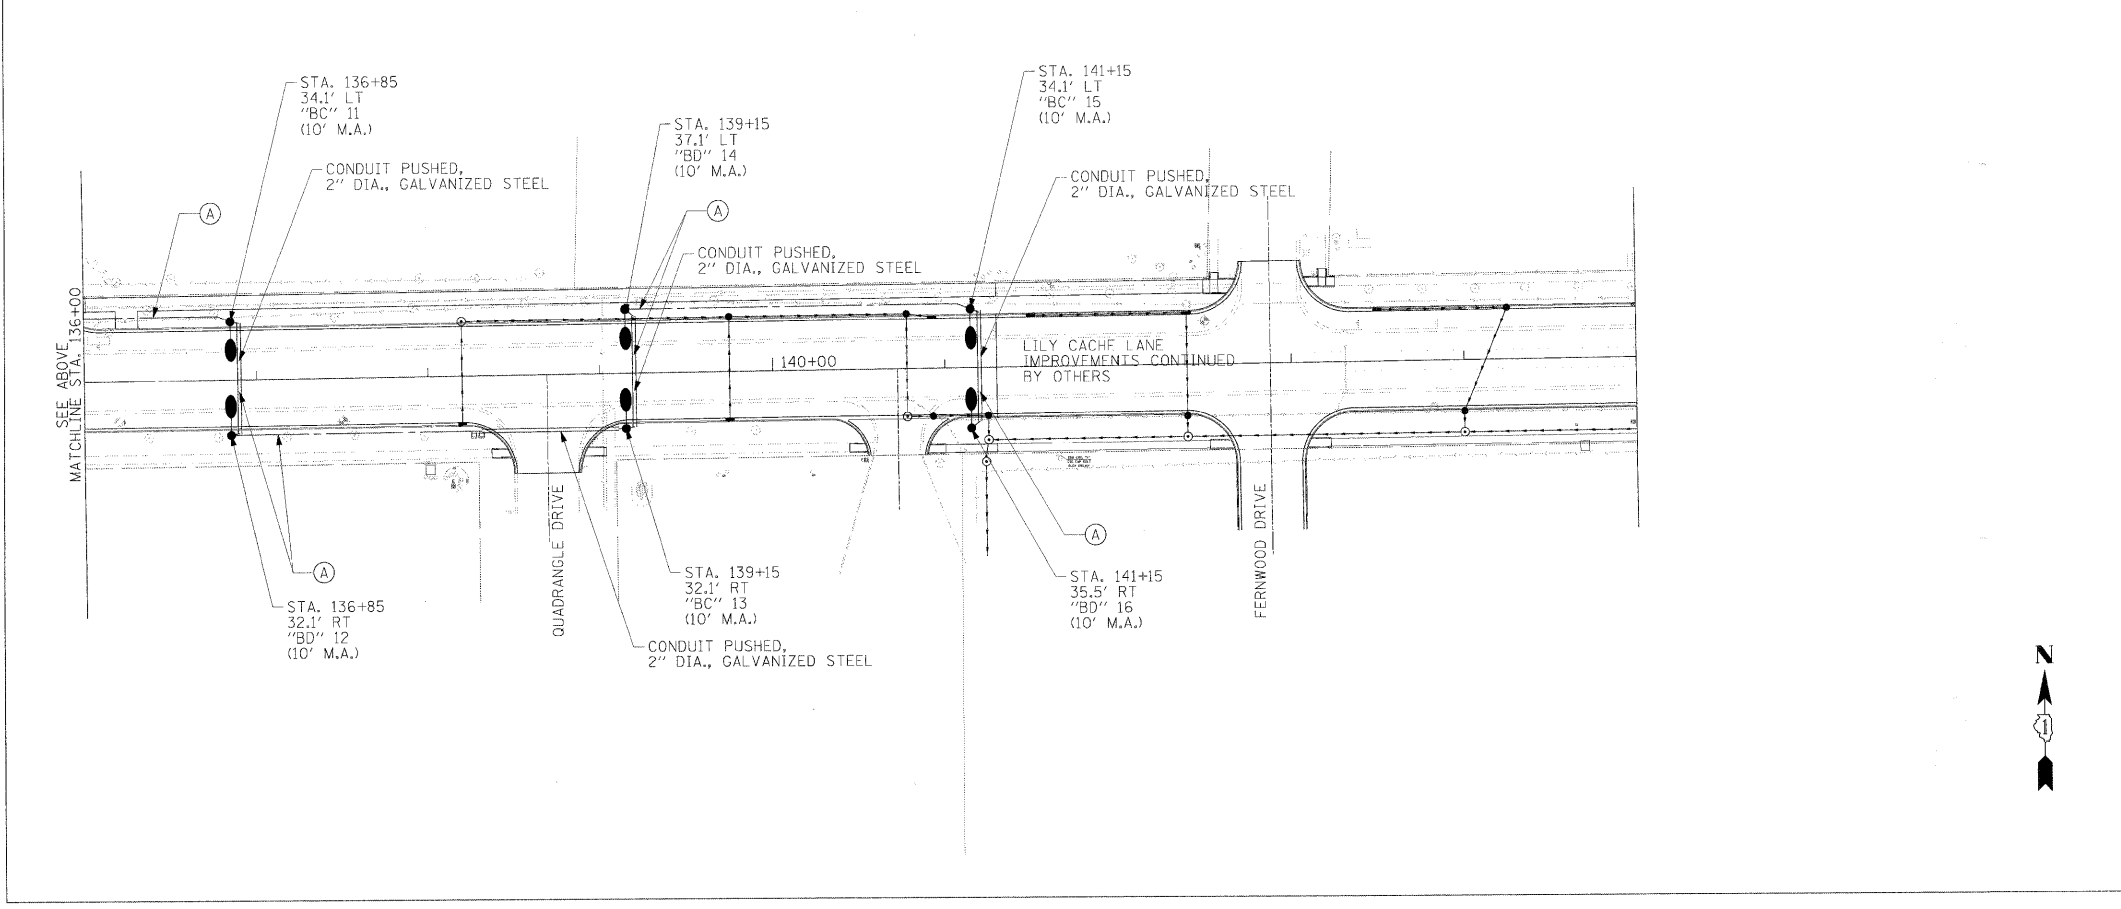


F.A.U. RTE.	SECTION	COUNTY	TOTAL SHEETS	SHEET NO.
157B	*	WILL	155	124

STA. TO STA.

FED. ROAD DIST. NO. ILLINOIS FED. AID PROJECT

* 06-0046-00-PF

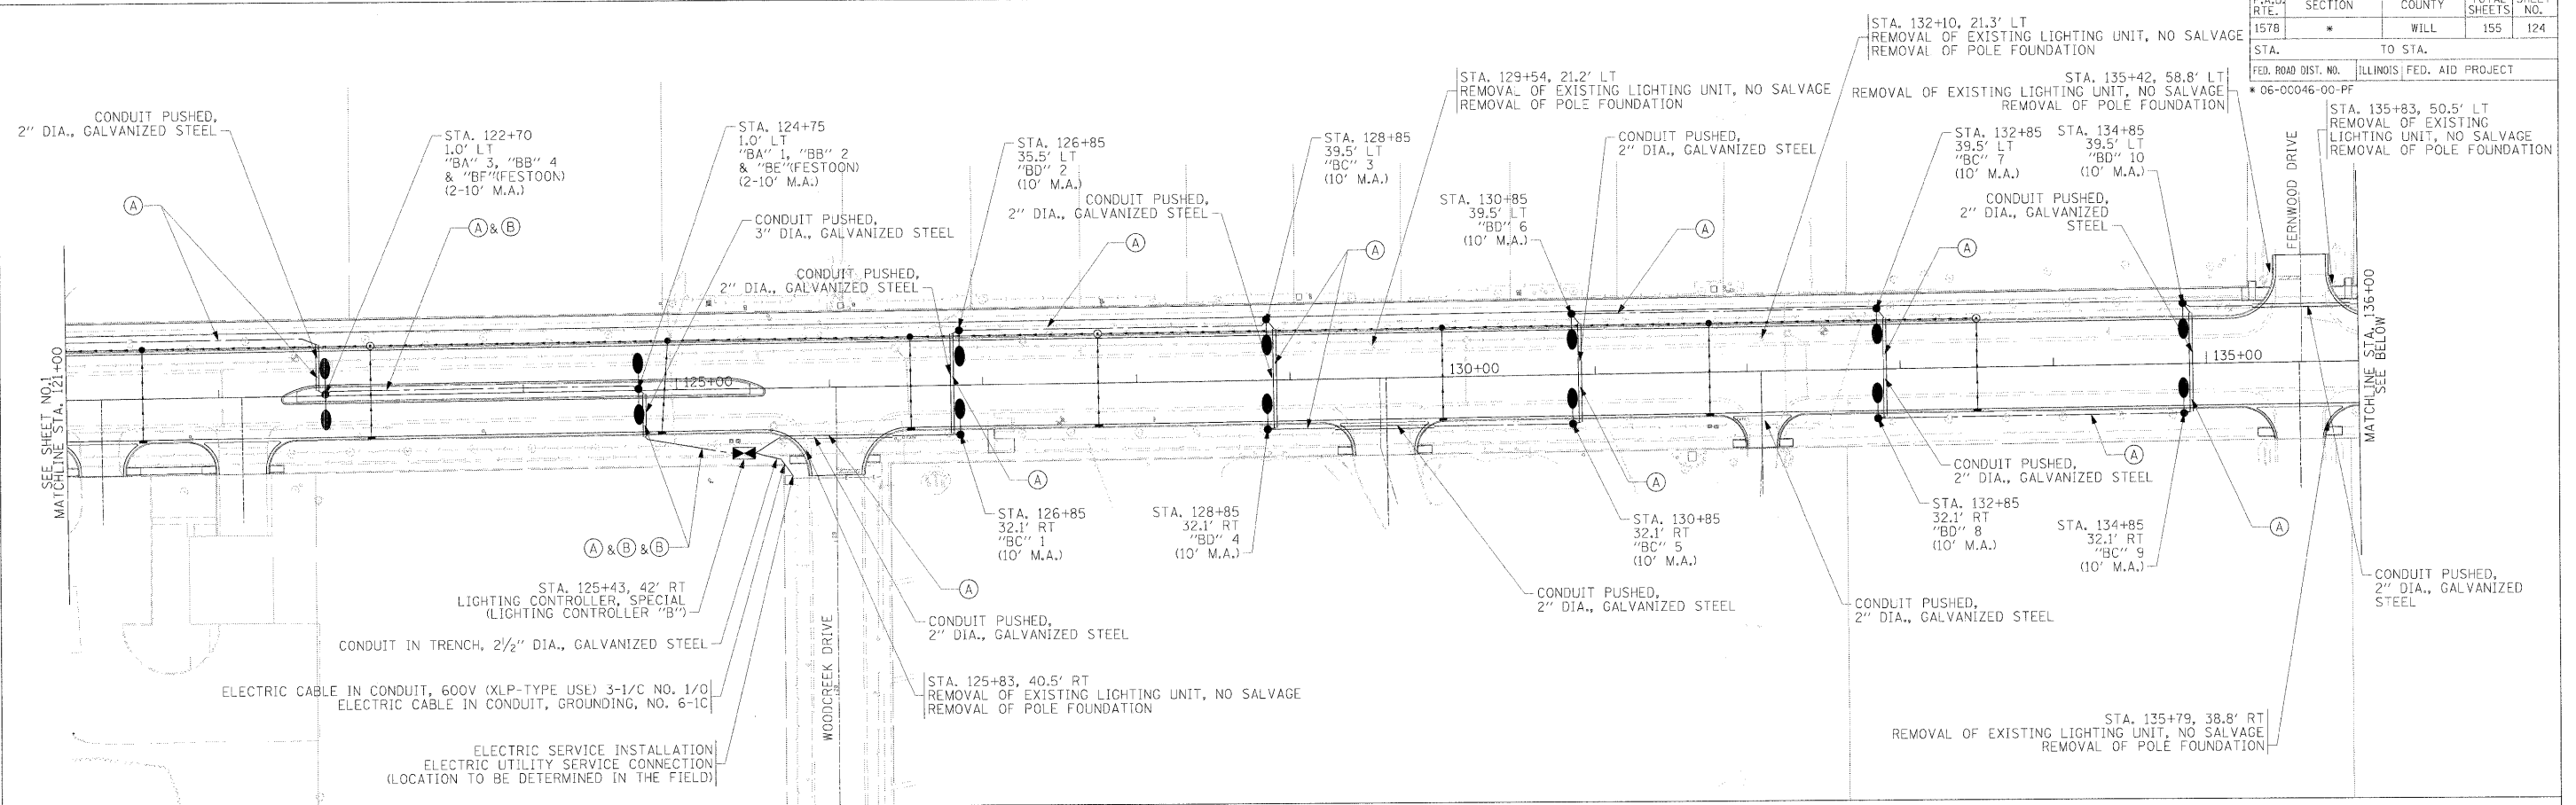

LIGHTING LEGEND

LIGHT POLE AND LUMINAIRE, TYPE A

 
LIGHT POLE AND LUMINAIRE, TYPE B

LIGHTING CONTROLLER

UNIT DUCT IN TRENCH

UNIT DUCT IN CONDUIT (PUSHED)

- UNIT DUCT LEGEND**
- (A) UNIT DUCT, 600V, 3-1C NO. 8, 1/C NO. 8 GROUND, (XLP-TYPE USE), 1" DIA. POLYETHYLENE
 - (B) UNIT DUCT, 600V, 2-1C NO. 6, 1/C NO. 6 GROUND, (XLP-TYPE USE), 1" DIA. POLYETHYLENE
 - (C) UNIT DUCT, 600V, 2-1C NO. 4, 1/C NO. 4 GROUND, (XLP-TYPE USE), 1" DIA. POLYETHYLENE



REVISIONS	
NAME	DATE

ILLINOIS DEPARTMENT OF TRANSPORTATION

LIGHTING PLAN

STA. 121+00 TO STA. 145+00

SCALE: 1"=50'

DATE: 03/31/2009

DRAWN BY: NMR

CHECKED BY: DJL

PLOT DATE = 4/9/2009
 FILE NAME = \\s1\proj\1025\veh\deliverables\1025LL_102.dgn
 PLOT SCALE = 1/8"=1'-0" / IN.
 USER NAME = MUSER9