
 
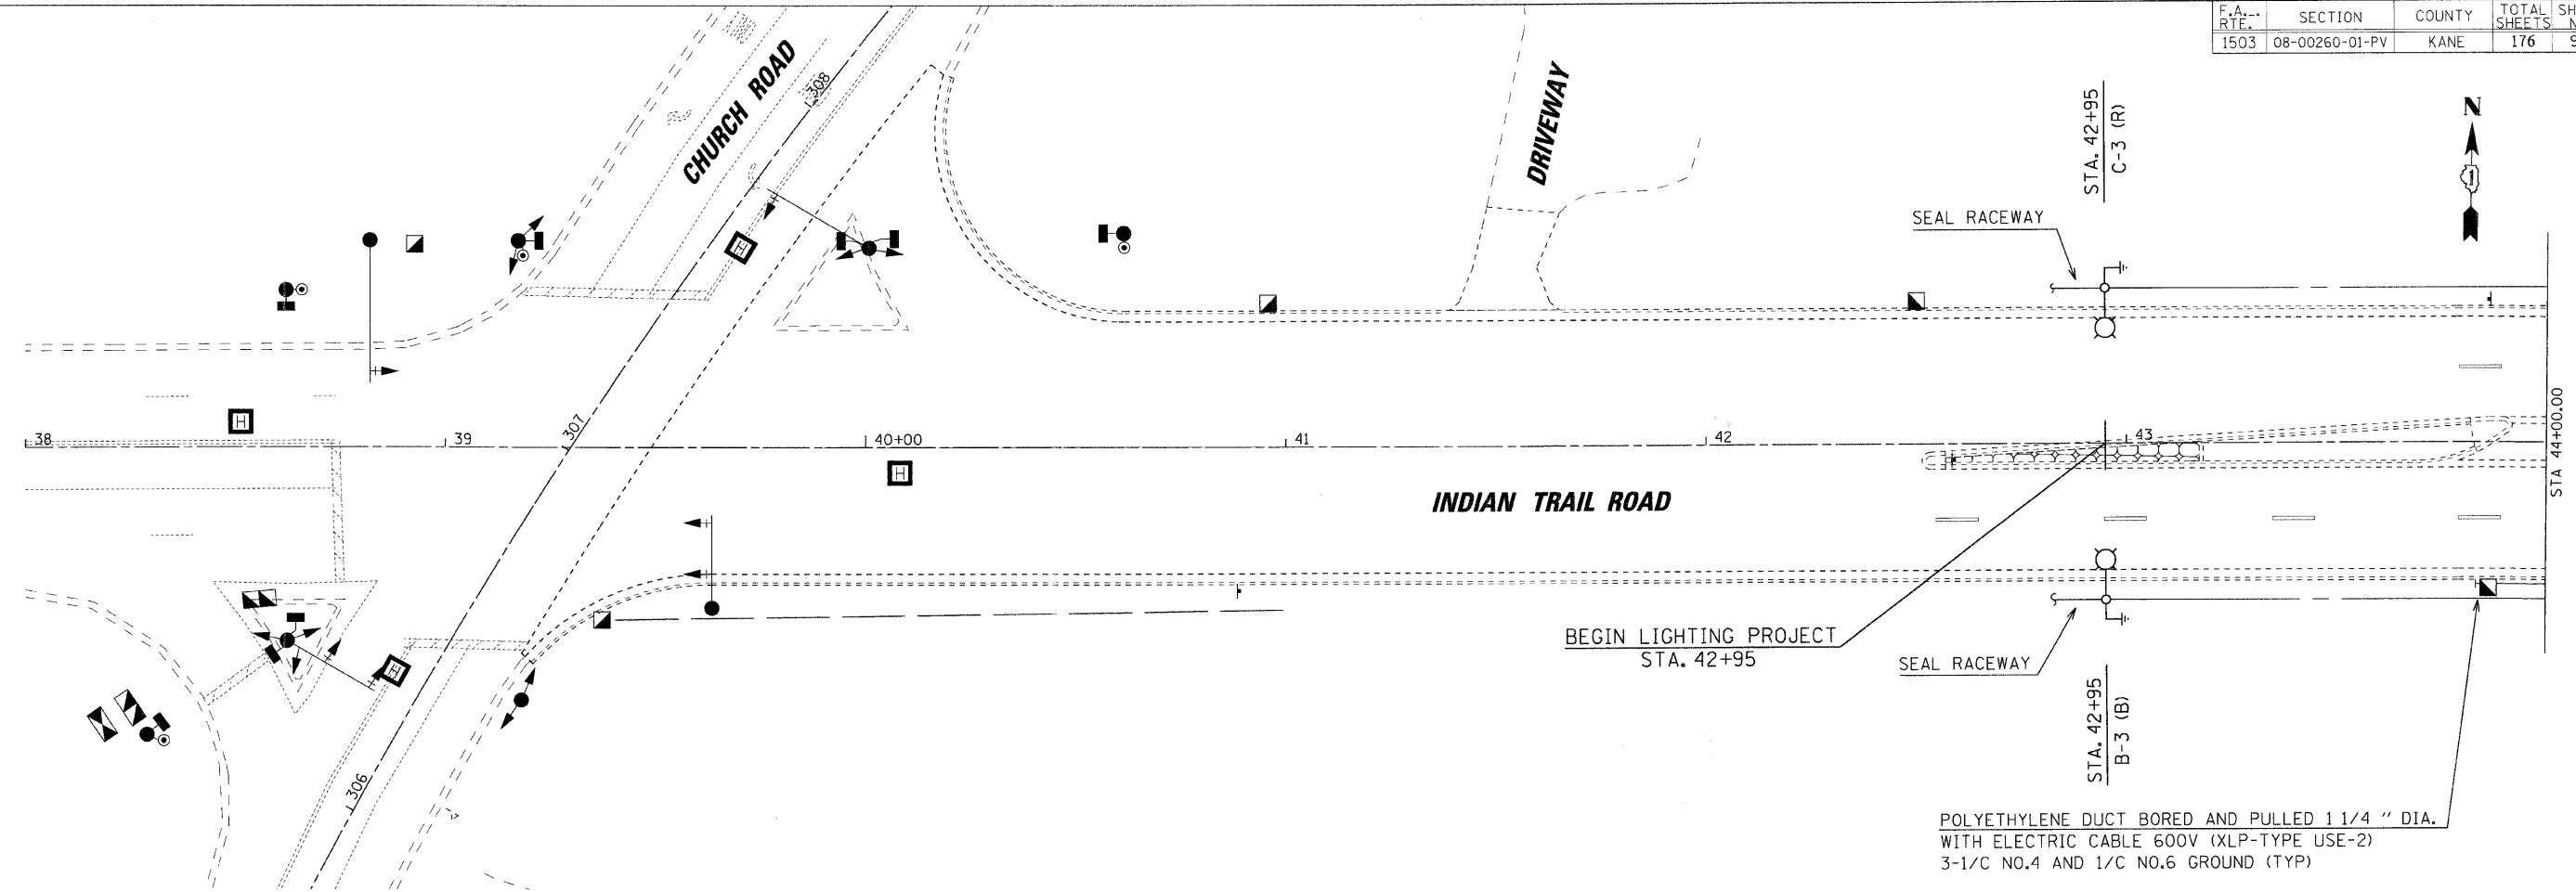


F.A. RTE.	SECTION	COUNTY	TOTAL SHEETS	SHEET NO.
1503	08-00260-01-PV	KANE	176	97



POLYETHYLENE DUCT BORED AND PULLED 1 1/4 " DIA.
WITH ELECTRIC CABLE 600V (XLP-TYPE USE-2)
3-1/C NO.4 AND 1/C NO.6 GROUND (TYP)

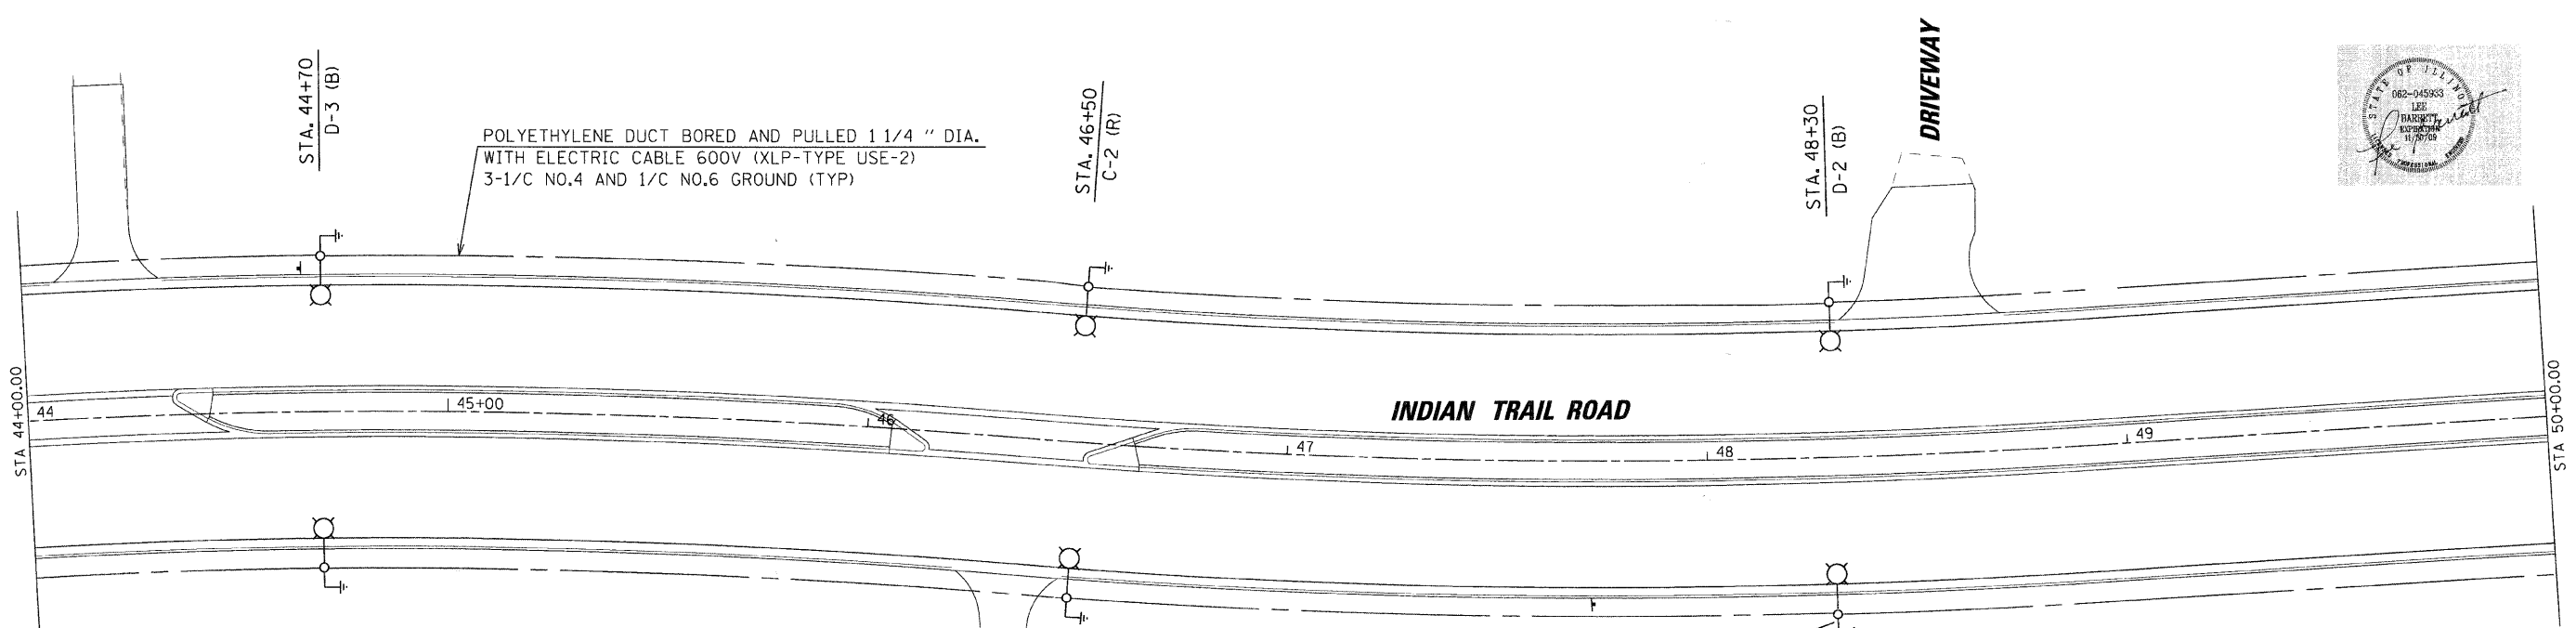

POLYETHYLENE DUCT BORED AND PULLED 1 1/4 " DIA.
WITH ELECTRIC CABLE 600V (XLP-TYPE USE-2)
3-1/C NO.4 AND 1/C NO.6 GROUND (TYP)



SDATES \$FILES



REVISED 06-30-08

Sunjoy Inc.
Area Lighting
212 TIMBERCREST DRIVE
SCHAUMBURG, ILLINOIS
60193-1572

REVISIONS	
NAME	DATE

ILLINOIS DEPARTMENT OF TRANSPORTATION
CITY OF AURORA, KANE COUNTY
INDIAN TRAIL ROAD
PROPOSED LIGHTING PLAN
STA. 42+95 TO STA. 50+00

VERT. 1"=20'
SCALE: HORIZ.
DATE 06-03-08

DRAWN BY HKD
CHECKED BY JS