


CHRISTOPHER B. BURKE ENGINEERING LTD.
 318 ALANA DRIVE
 New Lenox, Illinois 60451 (815) 463-9050


FEDERAL AID DESIGN ENGINEER: MELCHOR MANGOBA
 201 W. CENTER COURT
 SCHAMBURG, ILLINOIS 60196-1096
 (847) 705-4408

LEGEND:

	AGGREGATE SHOULDER, TYPE B, 8"
	PCC SIDEWALK, 5 INCH SUBBASE GRANULAR MATERIAL, TYPE B, 4"
	MANHOLE TO BE ADJUSTED
	INLET FILTER
	TREE ROOT PRUNING
	EROSION CONTROL PERIMETER BARRIER

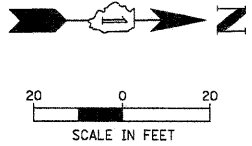

NOTE: STATION AND OFFSETS FOR SIDEWALK ARE SHOWN IN THE CROSS SECTIONS. THE OFFSETS FROM THE BASELINE ARE SHOWN AT THE FRONT EDGE OF THE SIDEWALK.

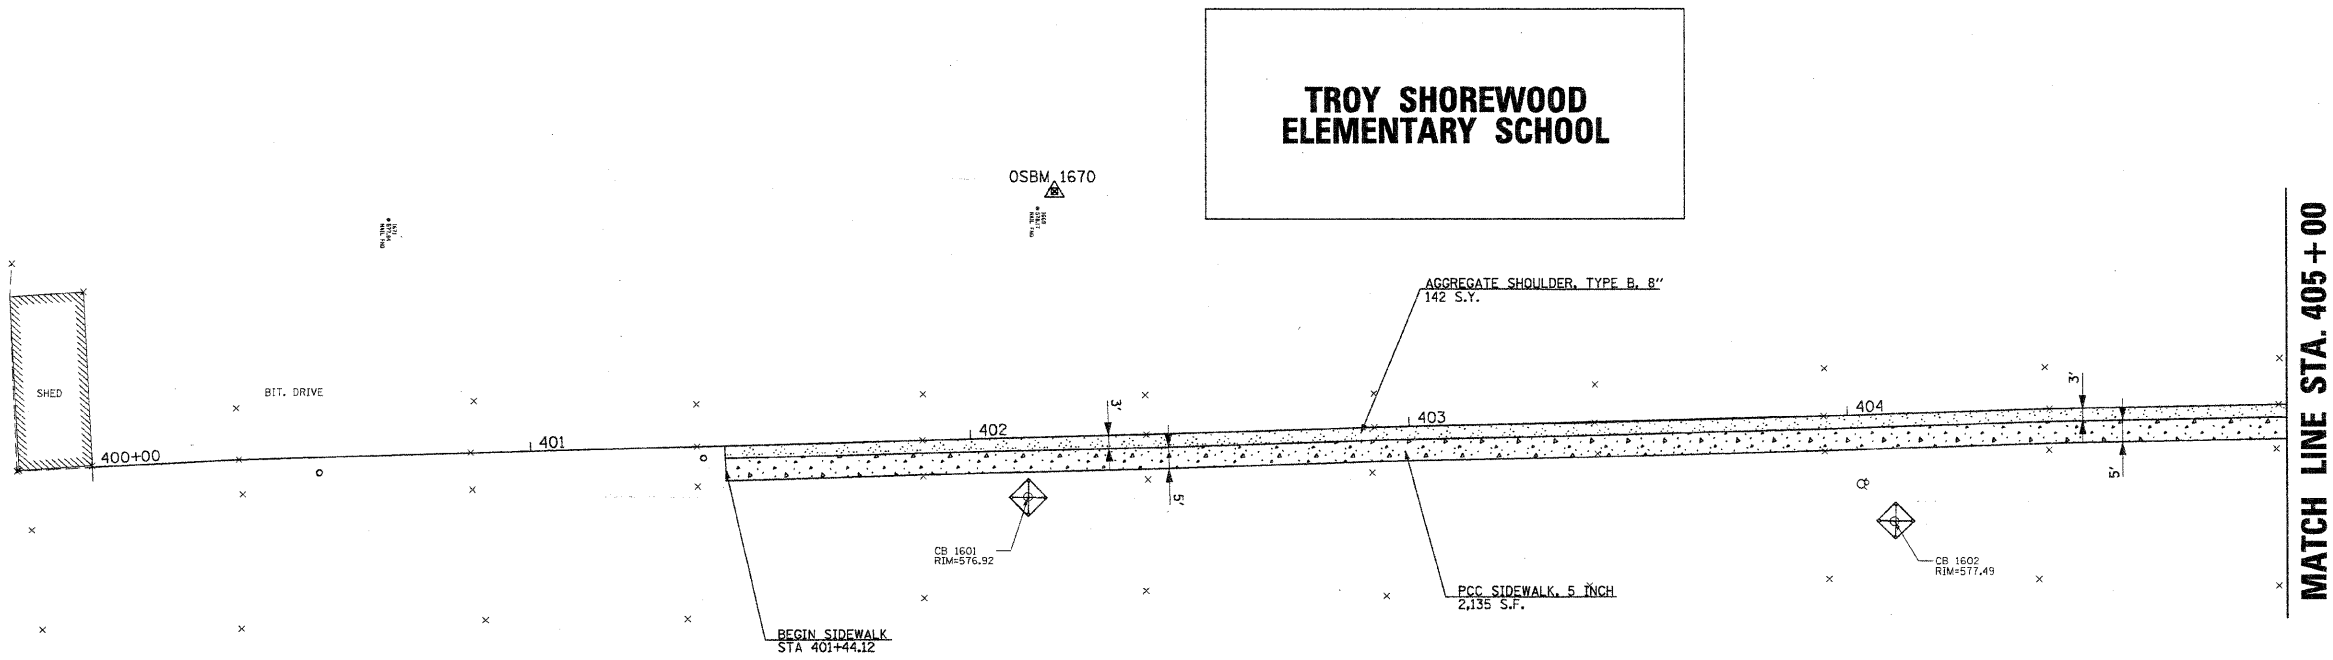

**TROY SHOREWOOD
 ELEMENTARY SCHOOL**

MATCH LINE STA. 405+00

FILE NAME = N:\Shorewood\870021\870021\2008\VC08-08	USER NAME = JDRALLE	DESIGNED CAA	REVISED 5/15/09	STATE OF ILLINOIS DEPARTMENT OF TRANSPORTATION	PROPOSED IMPROVEMENTS TROY SHOREWOOD ELEMENTARY SCHOOL	F.A. RTE.	SECTION	COUNTY	TOTAL SHEETS	SHEET NO.
		DRAWN CAA	REVISED -			08-00024-00-SW	WILL	37	15	
		CHECKED KRC	REVISED -			STA. 400+00 TO STA. 405+00		CONTRACT NO. 63200		
		DATE 5/15/09	REVISED -			ILLINOIS FED. AID PROJECT				