


CHRISTOPHER B. BURKE ENGINEERING LTD.
 318 ALANA DRIVE
 New Lenox, Illinois 60451 (815) 463-9050

FEDERAL AID DESIGN ENGINEER: MELCHOR MANGOBA
 201 W. CENTER COURT
 SCHAUMBURG, ILLINOIS 60196-1096
 (847) 703-4408

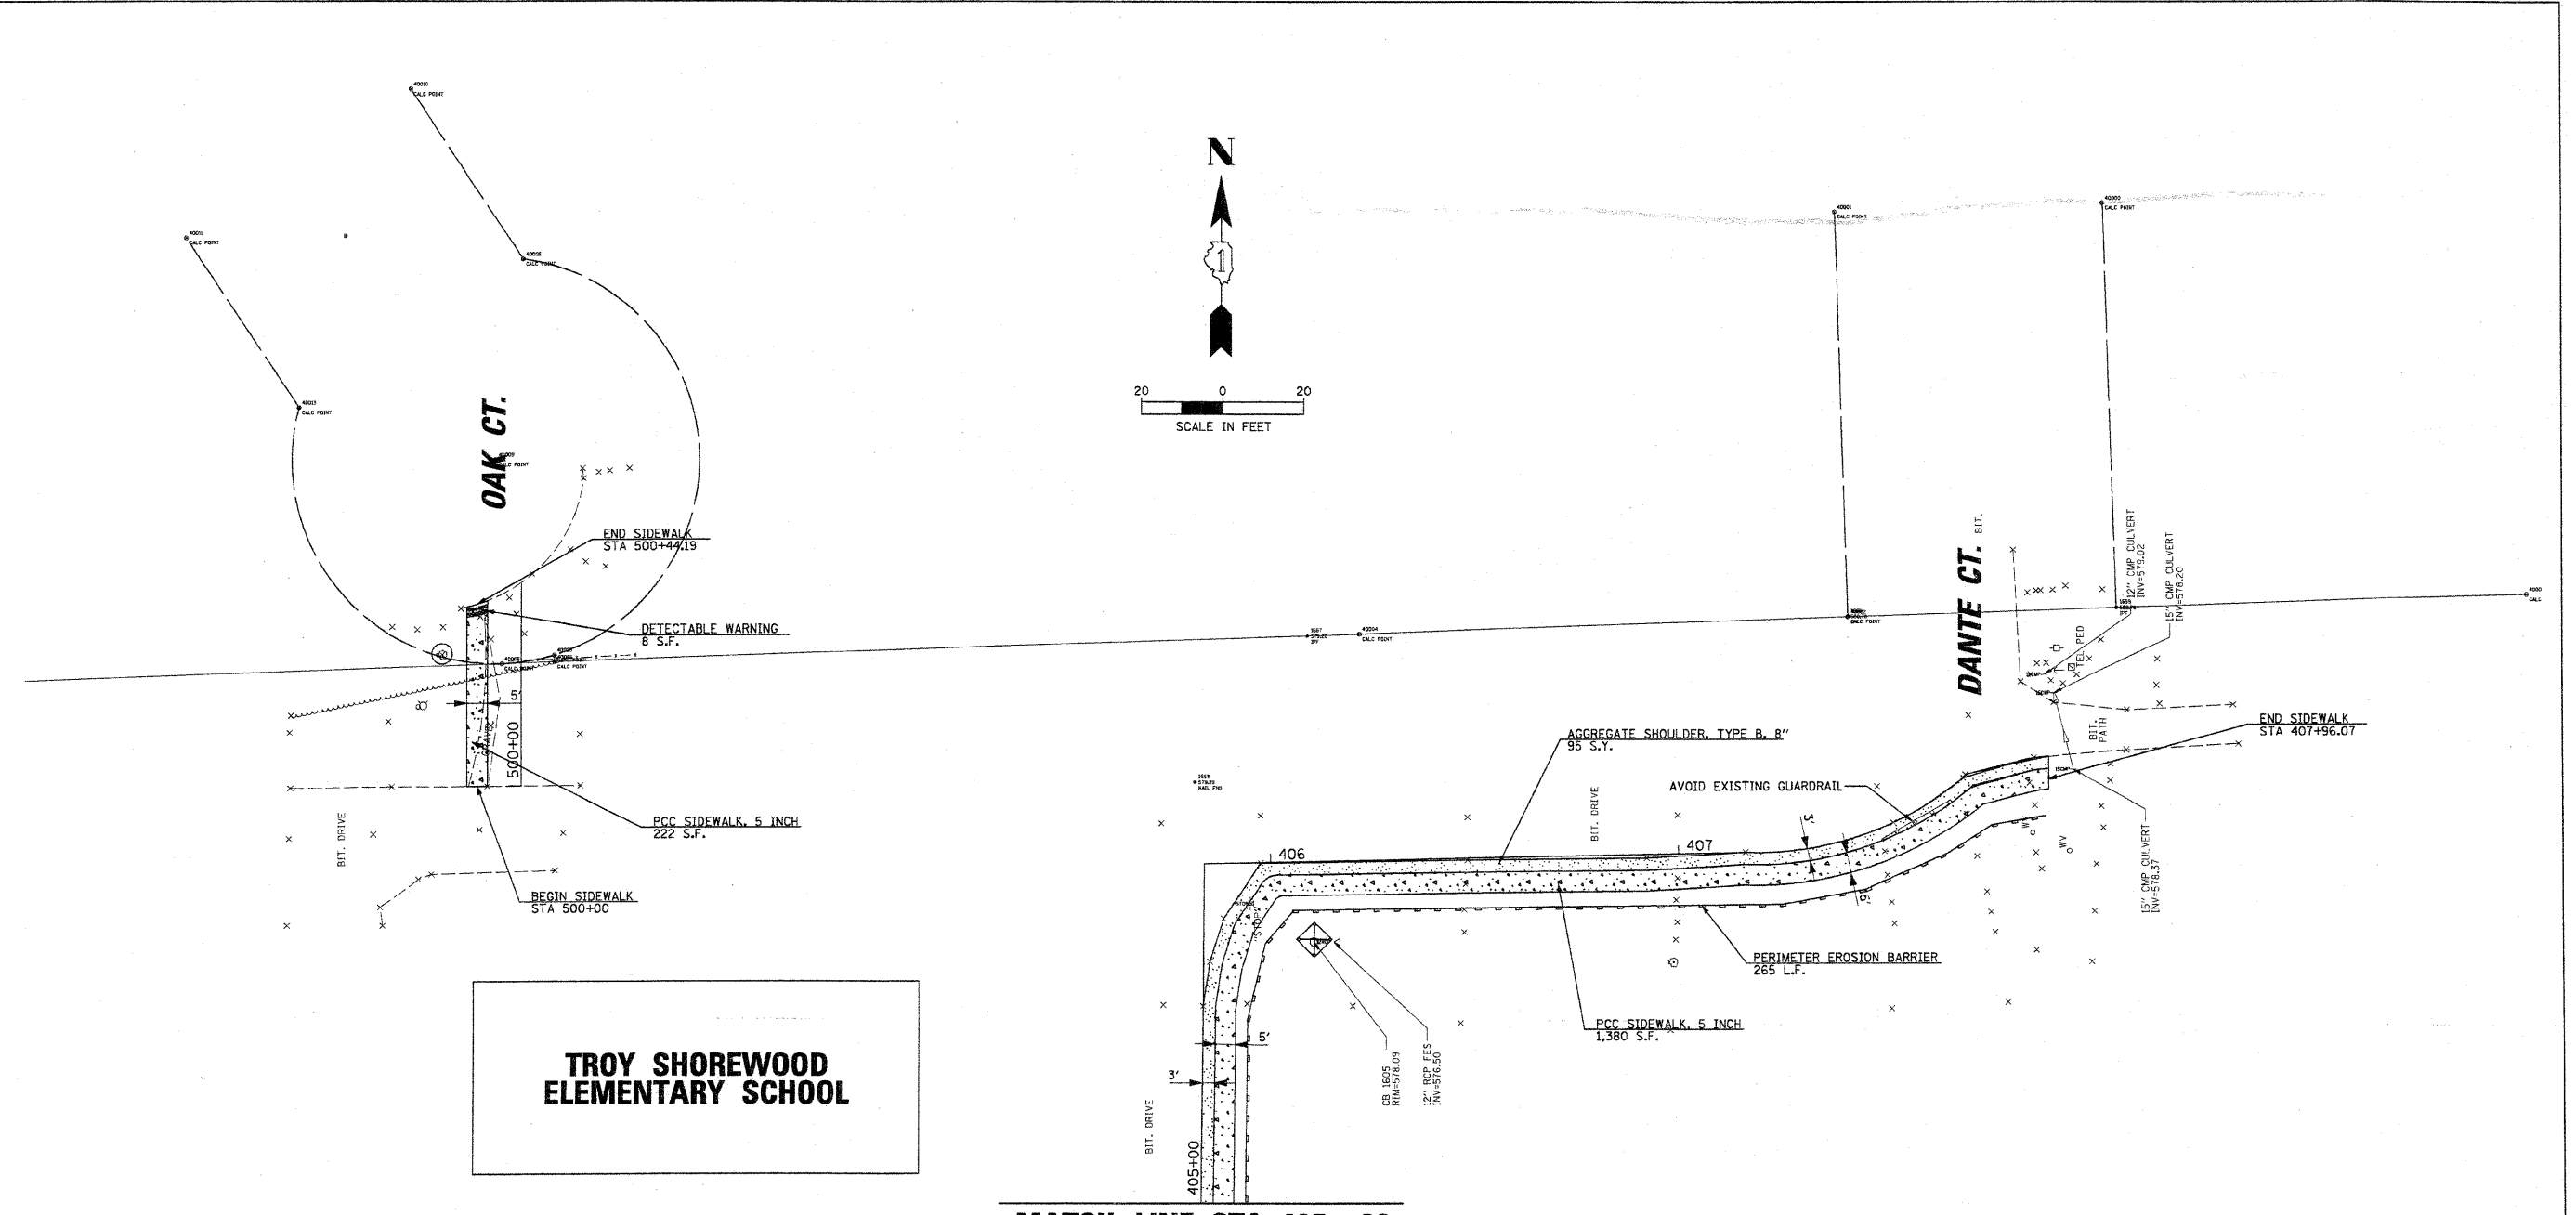

**TROY SHOREWOOD
 ELEMENTARY SCHOOL**

MATCH LINE STA. 405 + 00

LEGEND:

	AGGREGATE SHOULDER, TYPE B, 8"
	PCC SIDEWALK, 5 INCH SUBBASE GRANULAR MATERIAL, TYPE B, 4"
	MANHOLE TO BE ADJUSTED
	INLET FILTER
	TREE ROOT PRUNING
	EROSION CONTROL PERIMETER BARRIER

NOTE: STATION AND OFFSETS FOR SIDEWALK ARE SHOWN IN THE CROSS SECTIONS. THE OFFSETS FROM THE BASELINE ARE SHOWN AT THE FRONT EDGE OF THE SIDEWALK.

FILE NAME = N:\Shorewood\072008\072008\1\2008\1\08-08	USER NAME = JDRALLE	DESIGNED CAA	REVISED 5/15/09	STATE OF ILLINOIS DEPARTMENT OF TRANSPORTATION	PROPOSED IMPROVEMENTS TROY SHOREWOOD ELEMENTARY SCHOOL (DANTE COURT AND OAK COURT)		F.A. RTE.	SECTION	COUNTY	TOTAL SHEETS	SHEET NO.
	CVI\INPL-7_C08-05.dgn	DRAWN CAA	REVISED -		SCALE: 20	08-00024-00-SW	WILL	37	16	CONTRACT NO. 63200	
	PLOT SCALE = 20"	CHECKED KAC	REVISED -		STA. 405+00 TO STA. 407+96.07		ILLINOIS FED. AID PROJECT				
	PLOT DATE = 6/4/2009	DATE 5/15/09	REVISED -								