


F.A.P. RTE.	SECTION	COUNTY	TOTAL SHEETS	SHEET NO.
120		LAKE	469	195
STA.	TO STA.		ILLINOIS	FED. AID PROJECT
FED. ROAD DIST. NO. D-91-404-99				
• 125X-HB-(1&2) R-1				

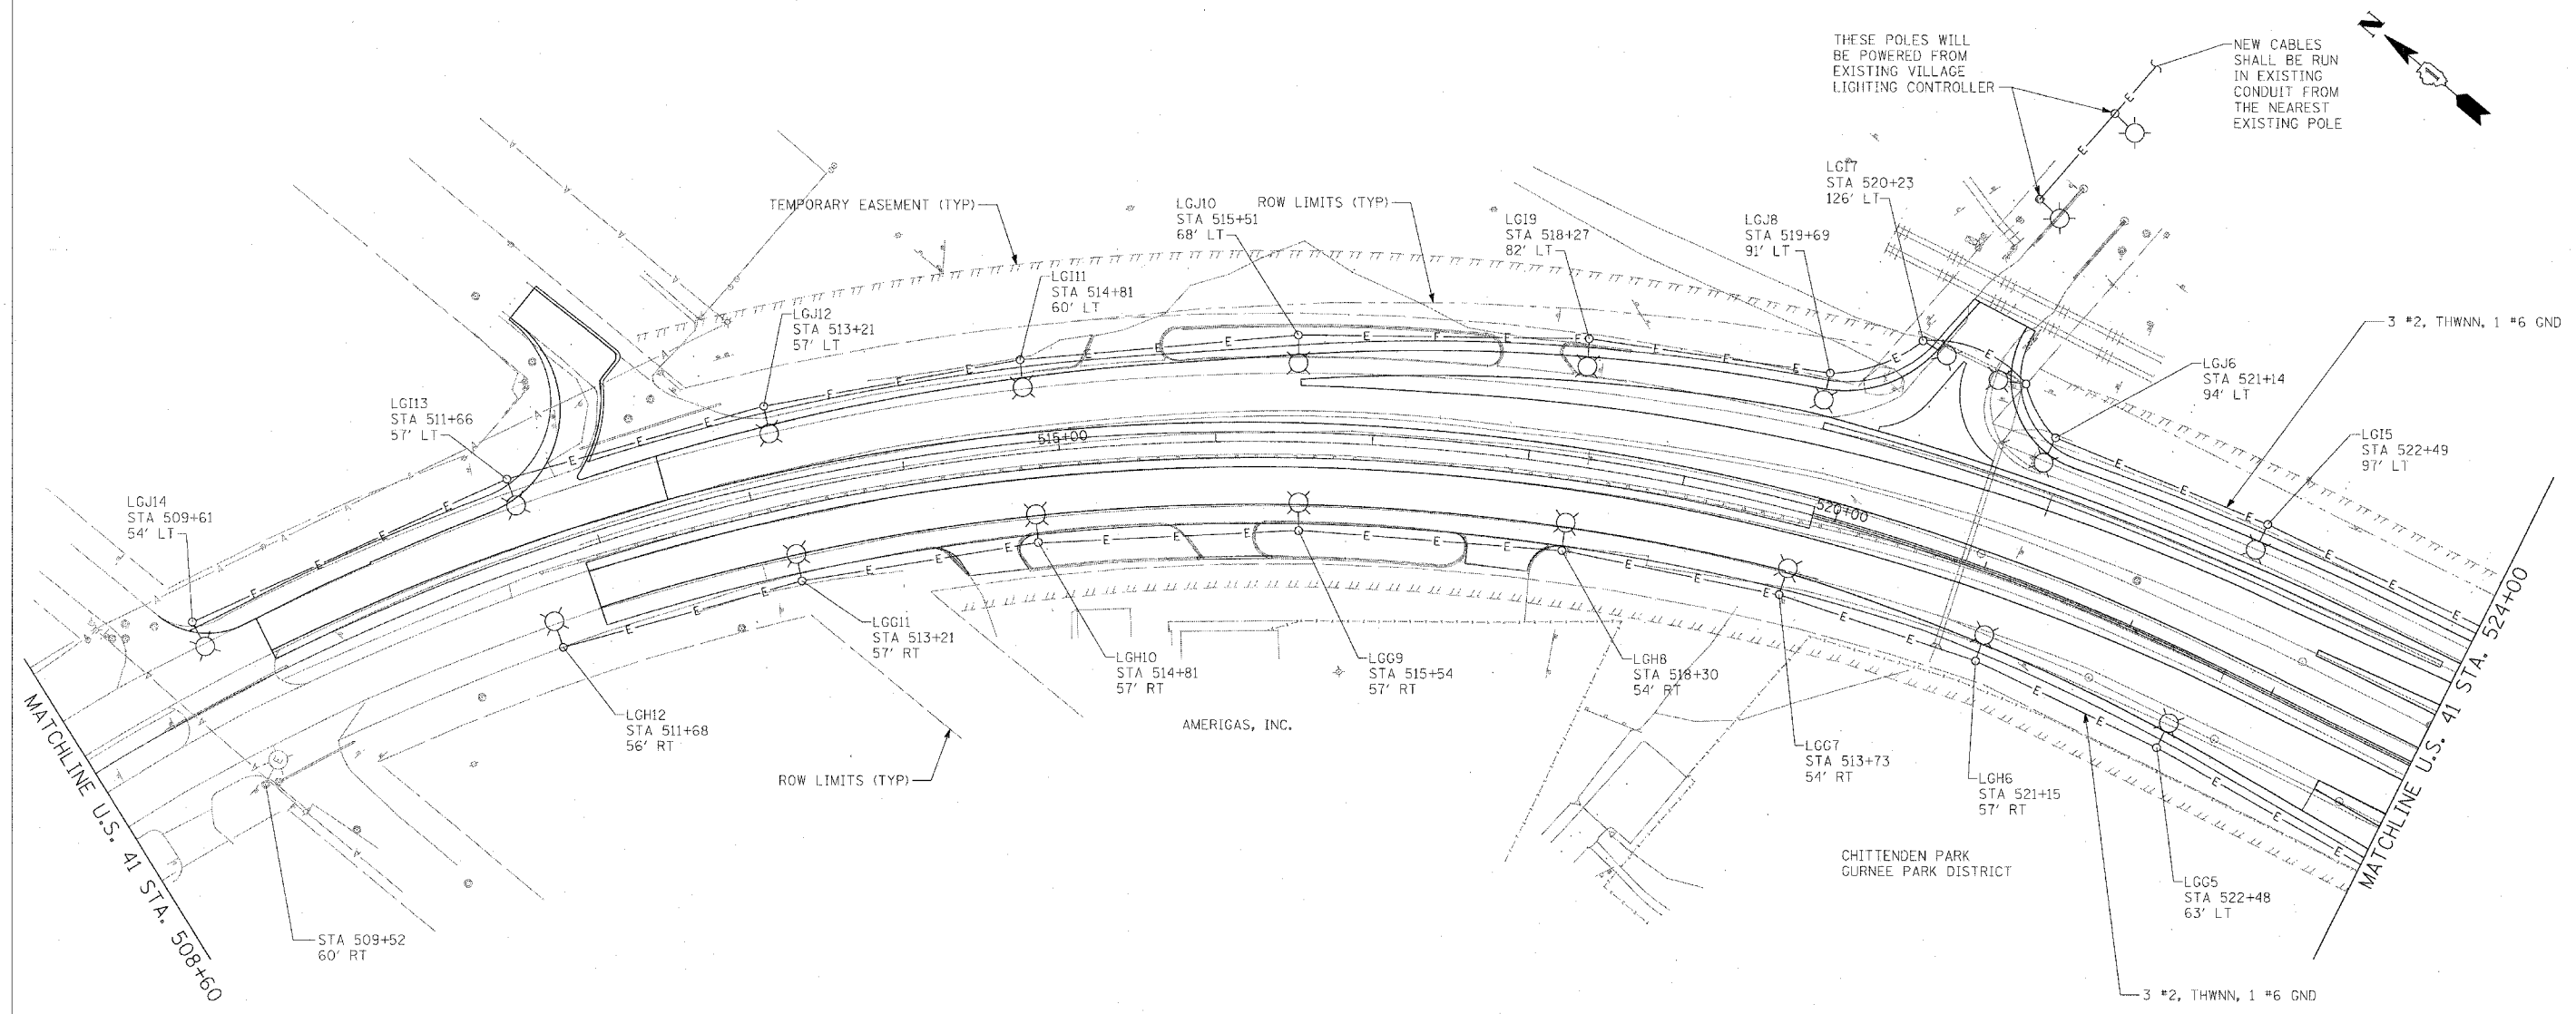

DATE	BY	REVISIONS
		PLANNING
		DESIGN
		CONSTRUCTION

DATE	BY	REVISIONS
		PLANNING
		DESIGN
		CONSTRUCTION

NOTES:
 1.) LIGHT POLE(S) WILL BE 47.5 FT IN HEIGHT WITH 10 FT MAST ARM. MOUNTED FIXTURE(S) WILL BE 400W HPS LUMINAIRE(S).



REVISIONS	
NAME	DATE
FEI	06/19/08

ILLINOIS DEPARTMENT OF TRANSPORTATION
 U.S. 41 (SKOKIE HIGHWAY)
 AT IL ROUTE 132
 PROPOSED ROADWAY LIGHTING PLAN
 SHEET 1 OF 6
 US 41 - BOP TO STA. 524+00
 SCALE: 1"=50'-0"
 DATE: 05/07/08
 DRAWN BY: FO
 CHECKED BY: DEM

PLOT DATE = #DATE#
 FILE NAME = #FILE#