 



F.A.P. RTE.	SECTION	COUNTY	TOTAL SHEETS	SHEET NO.
120		LAKE	469	147
STA.		TO STA.		
FED. ROAD DIST. NO. D-91-404-99		ILLINOIS	FED. AID PROJECT	
• 125X-HB-(1&2) R-1				

PLAN	DATE
NO. & BOOK	
REVISIONS	
NOTED	
ALIGNED	
CHECKED	
CAD FILE NAME	

PROFILE	DATE
NO. & BOOK	
REVISIONS	
NOTED	
CHECKED	
CAD FILE NAME	

PLOT DATE = 5/17/2008  
 FILE NAME = I:\TY\_LIN\34295 - US 41 ST. IL 132\GOOD\41TEMP\TG-3103.dwg

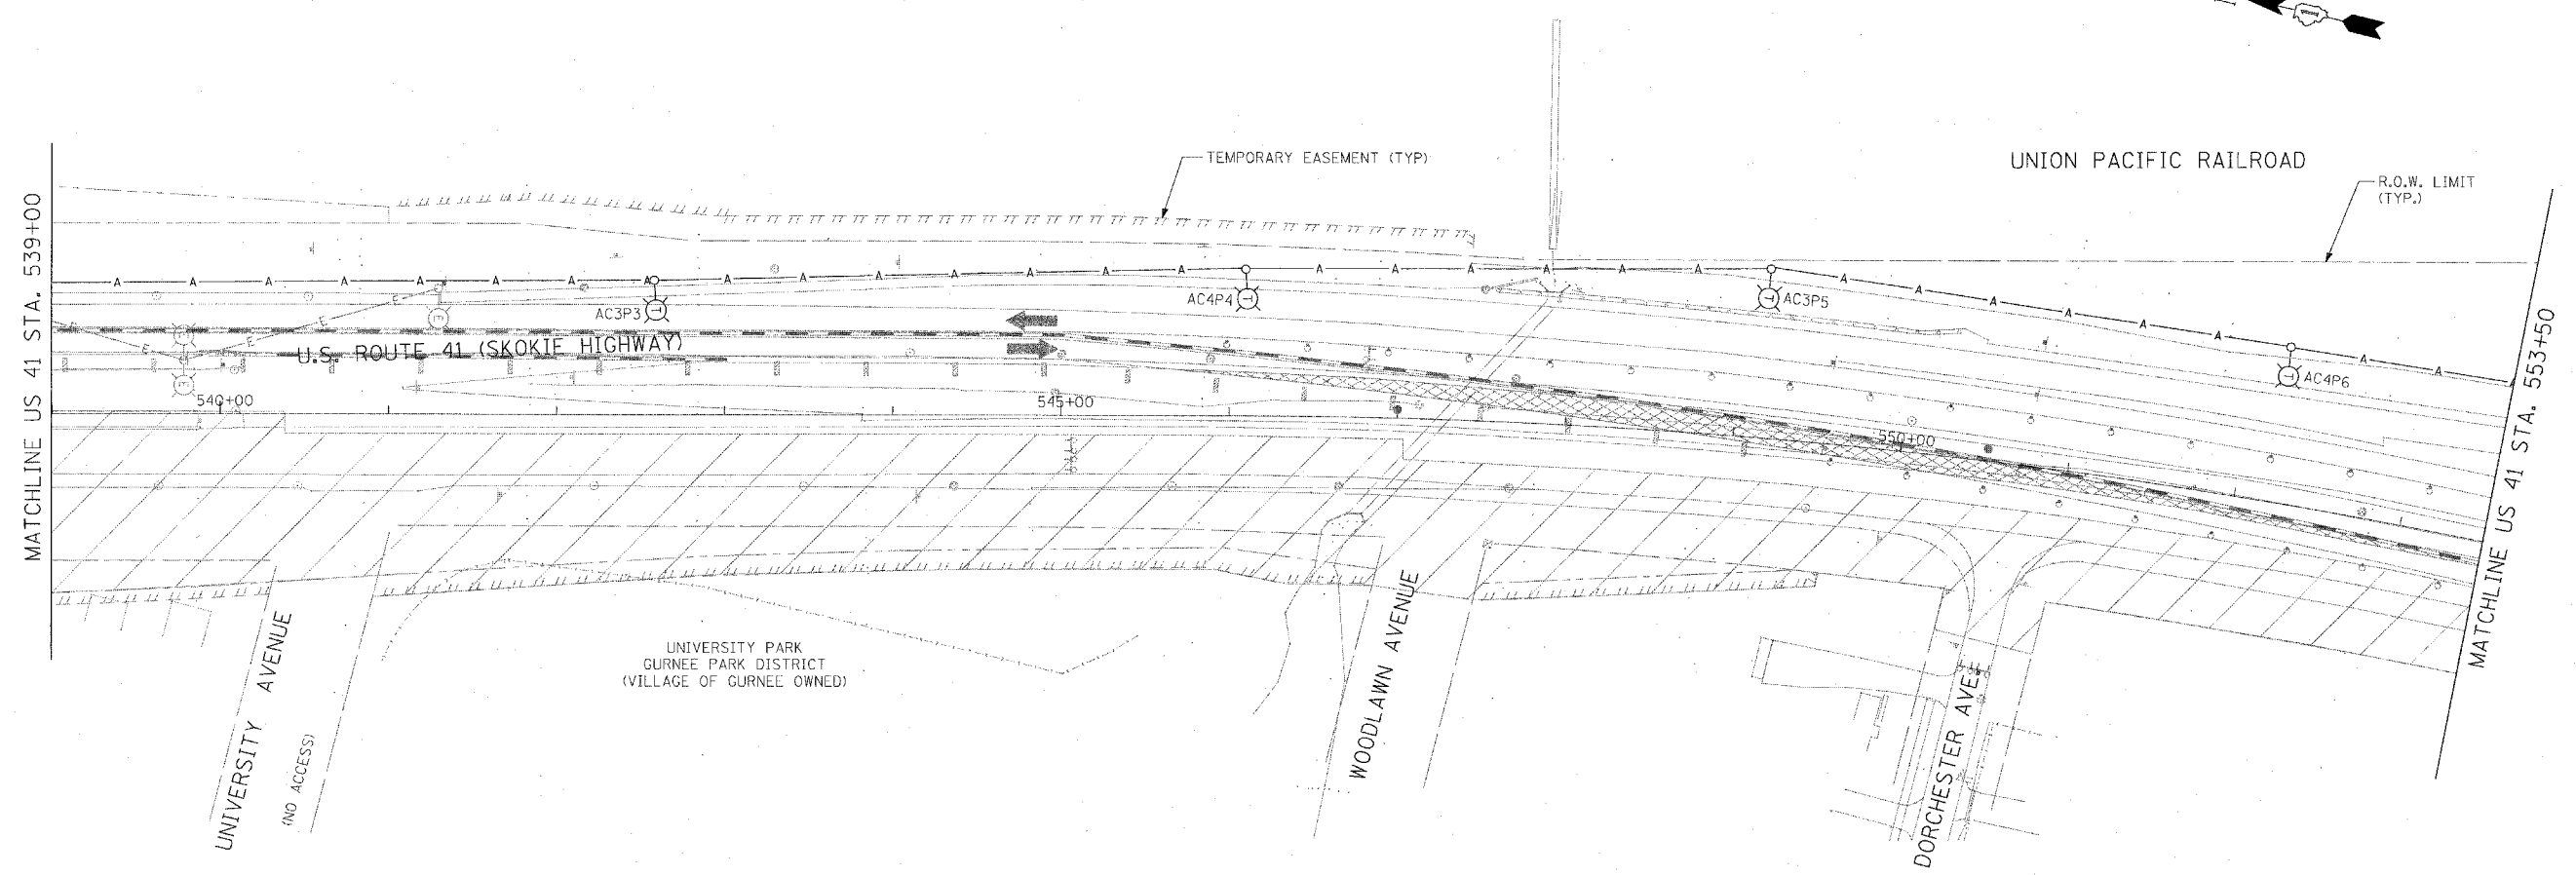

REVISIONS	
NAME	DATE

ILLINOIS DEPARTMENT OF TRANSPORTATION  
 U.S. 41 (SKOKIE HIGHWAY)  
 AT IL ROUTE 132  
 TEMPORARY ROADWAY LIGHTING PLAN  
 SHEET 3 OF 4  
 US 41 - STA. 539+00 TO STA. 553+50  
 SCALE: 1"=50'-0" DRAWN BY: FO  
 DATE: 05/07/08 CHECKED BY: DEM