



TYPICAL SPLICE DETAIL

N.T.S.

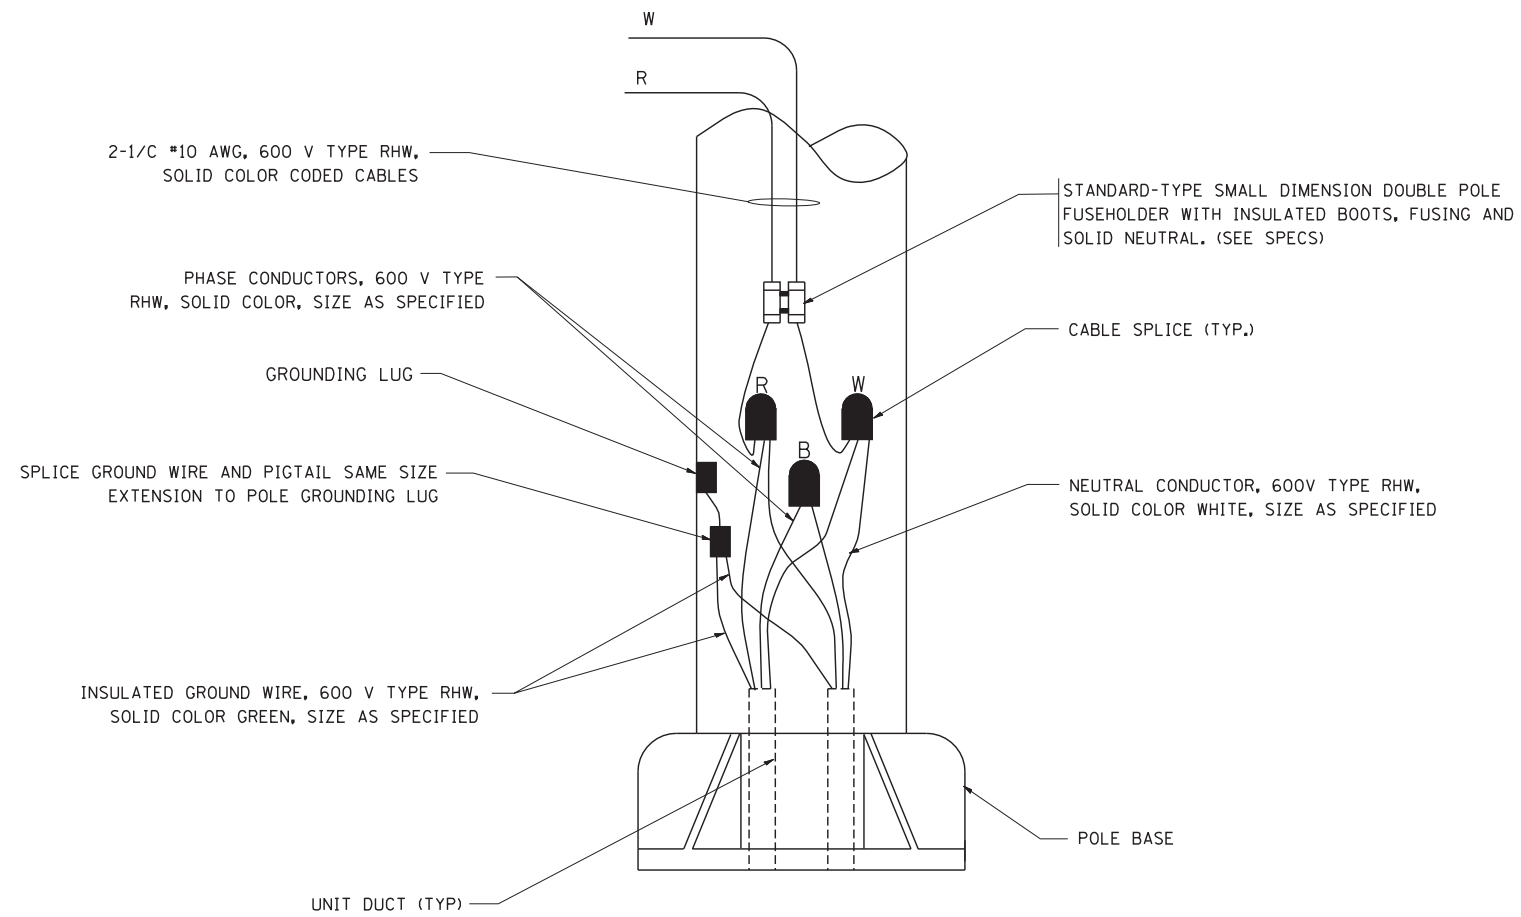

POLE WIRING DETAIL

N.T.S.

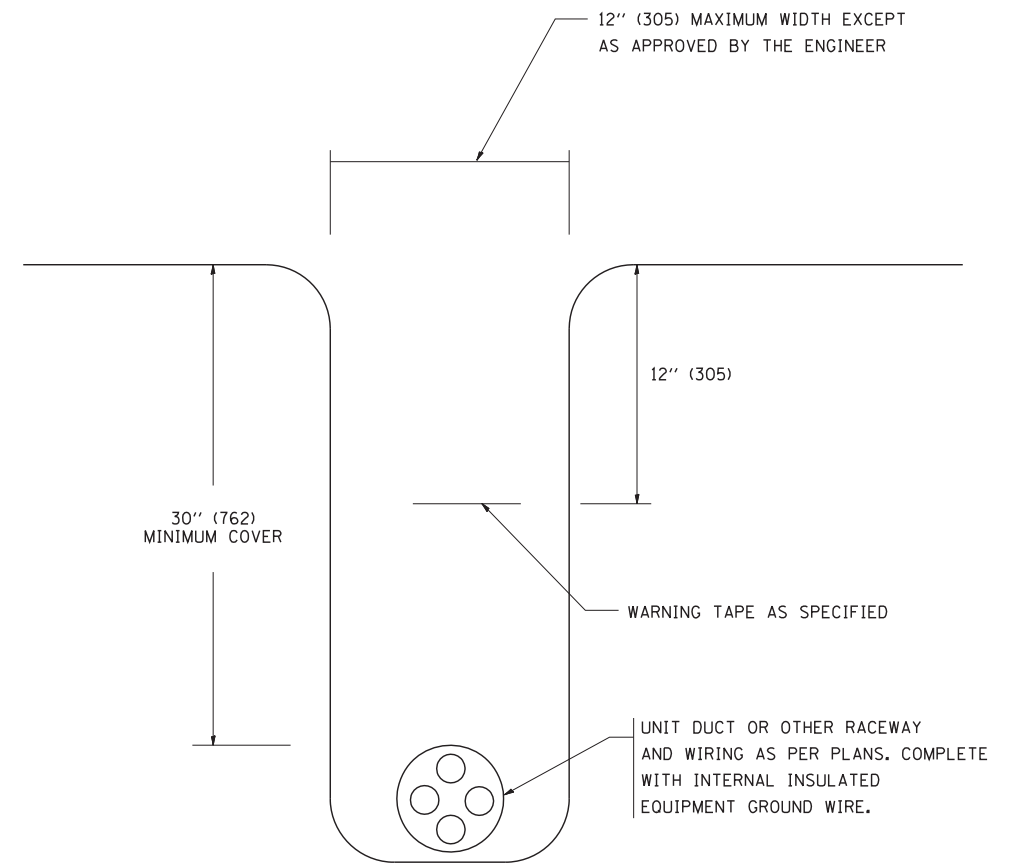

TYPICAL WIRING IN TRENCH DETAIL

N.T.S.

FILE NAME = W:\diststd\22x34\be702.dgn

USER NAME = gaglionobt
 PLOT SCALE = 50.000' / IN.
 PLOT DATE = 1/4/2008

| | |
|------------|--------------------|
| DESIGNED - | REVISED - 08-08-03 |
| DRAWN - | REVISED - |
| CHECKED - | REVISED - |
| DATE - | REVISED - |

**STATE OF ILLINOIS
 DEPARTMENT OF TRANSPORTATION**

**MISC. ELECTRICAL DETAILS
 SHEET A**

SCALE: NONE SHEET NO. 1 OF 1 SHEETS STA. TO STA.

| | | | | |
|---|-------------------|--------------------|------------------|---------------|
| F.A.P. RTE. 345 | SECTION 106-S-N-2 | COUNTY KANE | TOTAL SHEETS 147 | SHEET NO. 119 |
| BE-702 | | CONTRACT NO. 60T09 | | |
| FED. ROAD DIST. NO. 1 ILLINOIS FED. AID PROJECT | | | | |