



**TYPICAL SPLICE DETAIL**

N.T.S.

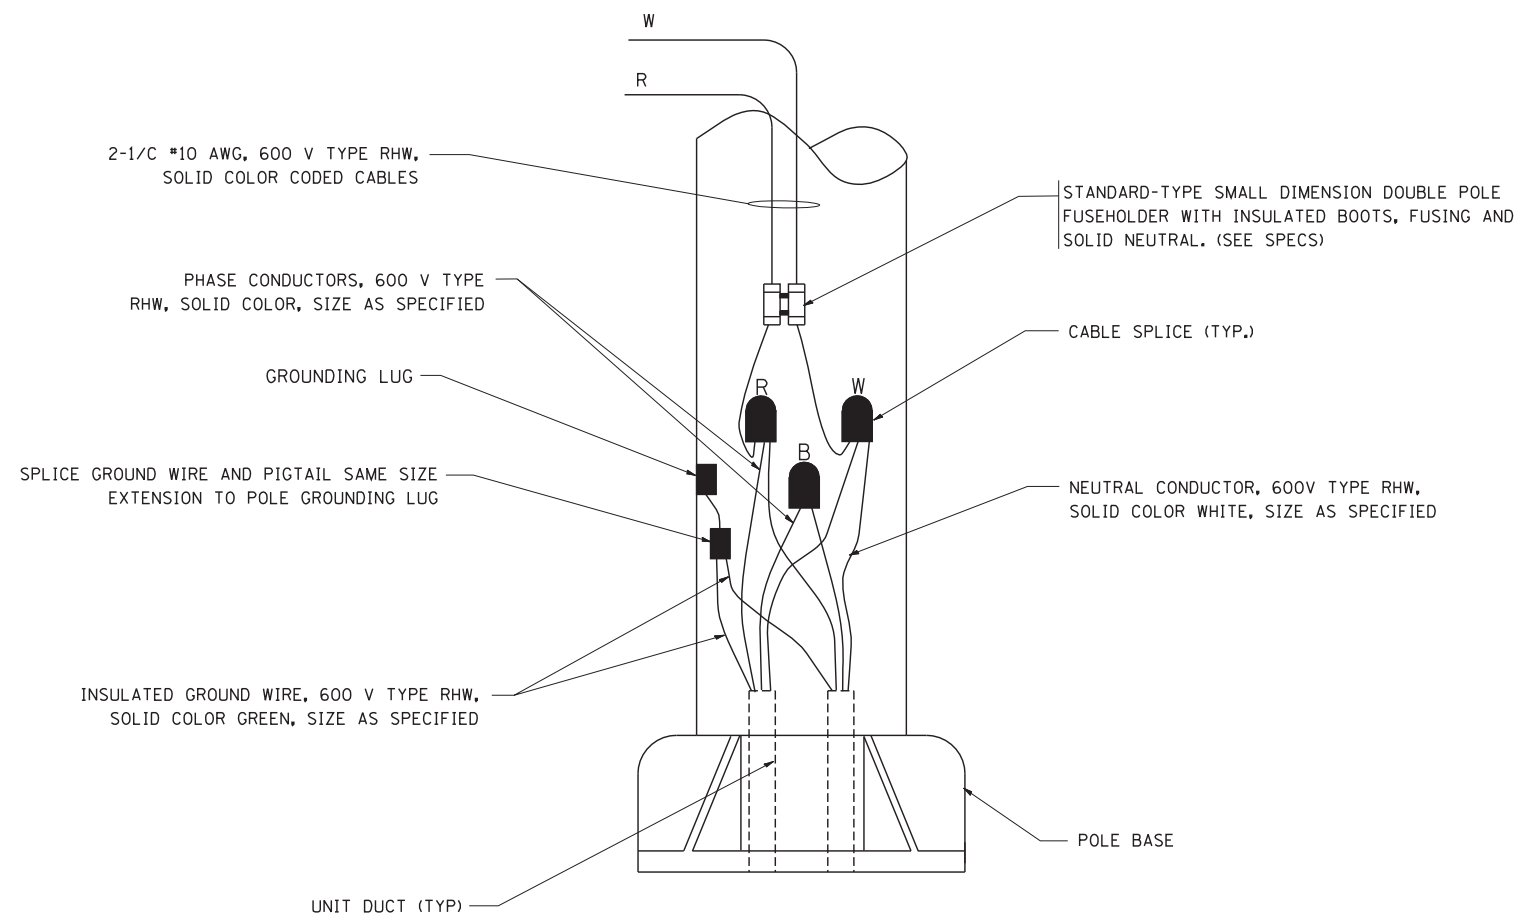

**POLE WIRING DETAIL**

N.T.S.

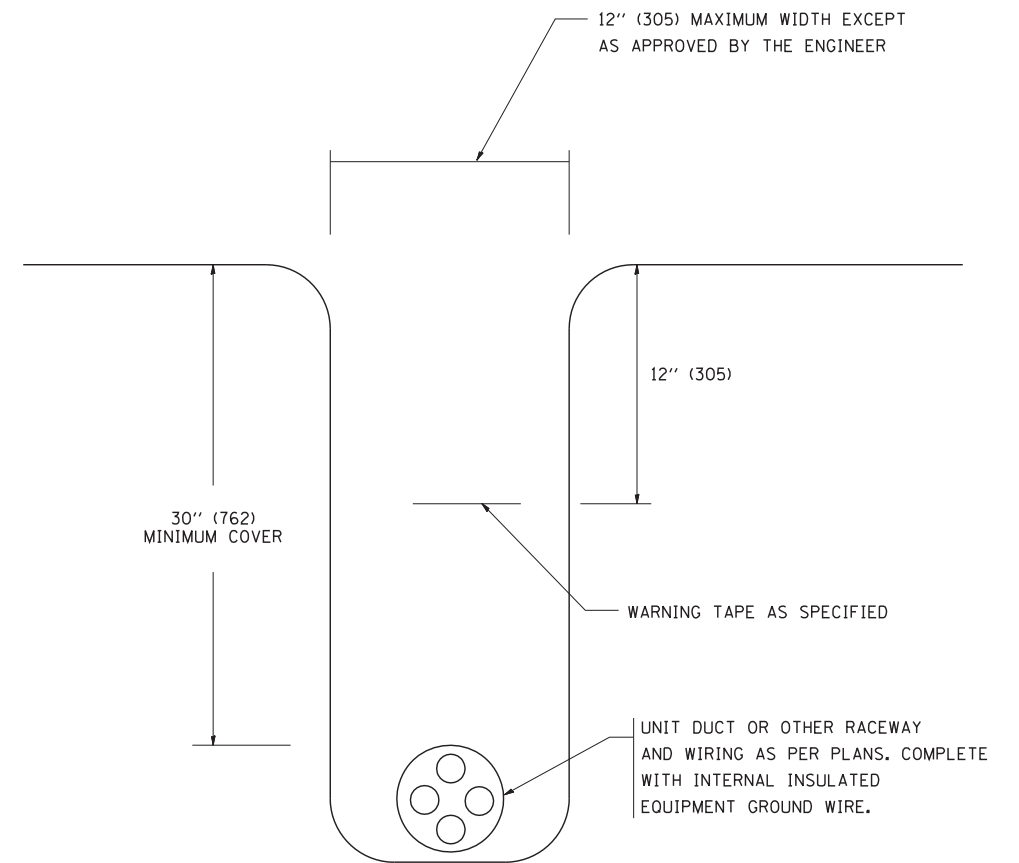

**TYPICAL WIRING IN TRENCH DETAIL**

N.T.S.

FILE NAME = W:\diststd\22x34\be702.dgn

USER NAME = gaglionobt  
 PLOT SCALE = 50.000' / IN.  
 PLOT DATE = 1/4/2008

|            |                    |
|------------|--------------------|
| DESIGNED - | REVISED - 08-08-03 |
| DRAWN -    | REVISED -          |
| CHECKED -  | REVISED -          |
| DATE -     | REVISED -          |

**STATE OF ILLINOIS  
 DEPARTMENT OF TRANSPORTATION**

**MISC. ELECTRICAL DETAILS  
 SHEET A**

SCALE: NONE SHEET NO. 1 OF 1 SHEETS STA. TO STA.

|   |         |         |                    |           |
|---|---------|---------|--------------------|-----------|
| F.A. RTE.                                       | SECTION | COUNTY  | TOTAL SHEETS       | SHEET NO. |
| 305   | 27R-3   | MCHENRY | 431                | 279       |
| BE-702  |         |         | CONTRACT NO. 62517 |           |
| FED. ROAD DIST. NO. 1 ILLINOIS FED. AID PROJECT |         |         |                    |           |