
 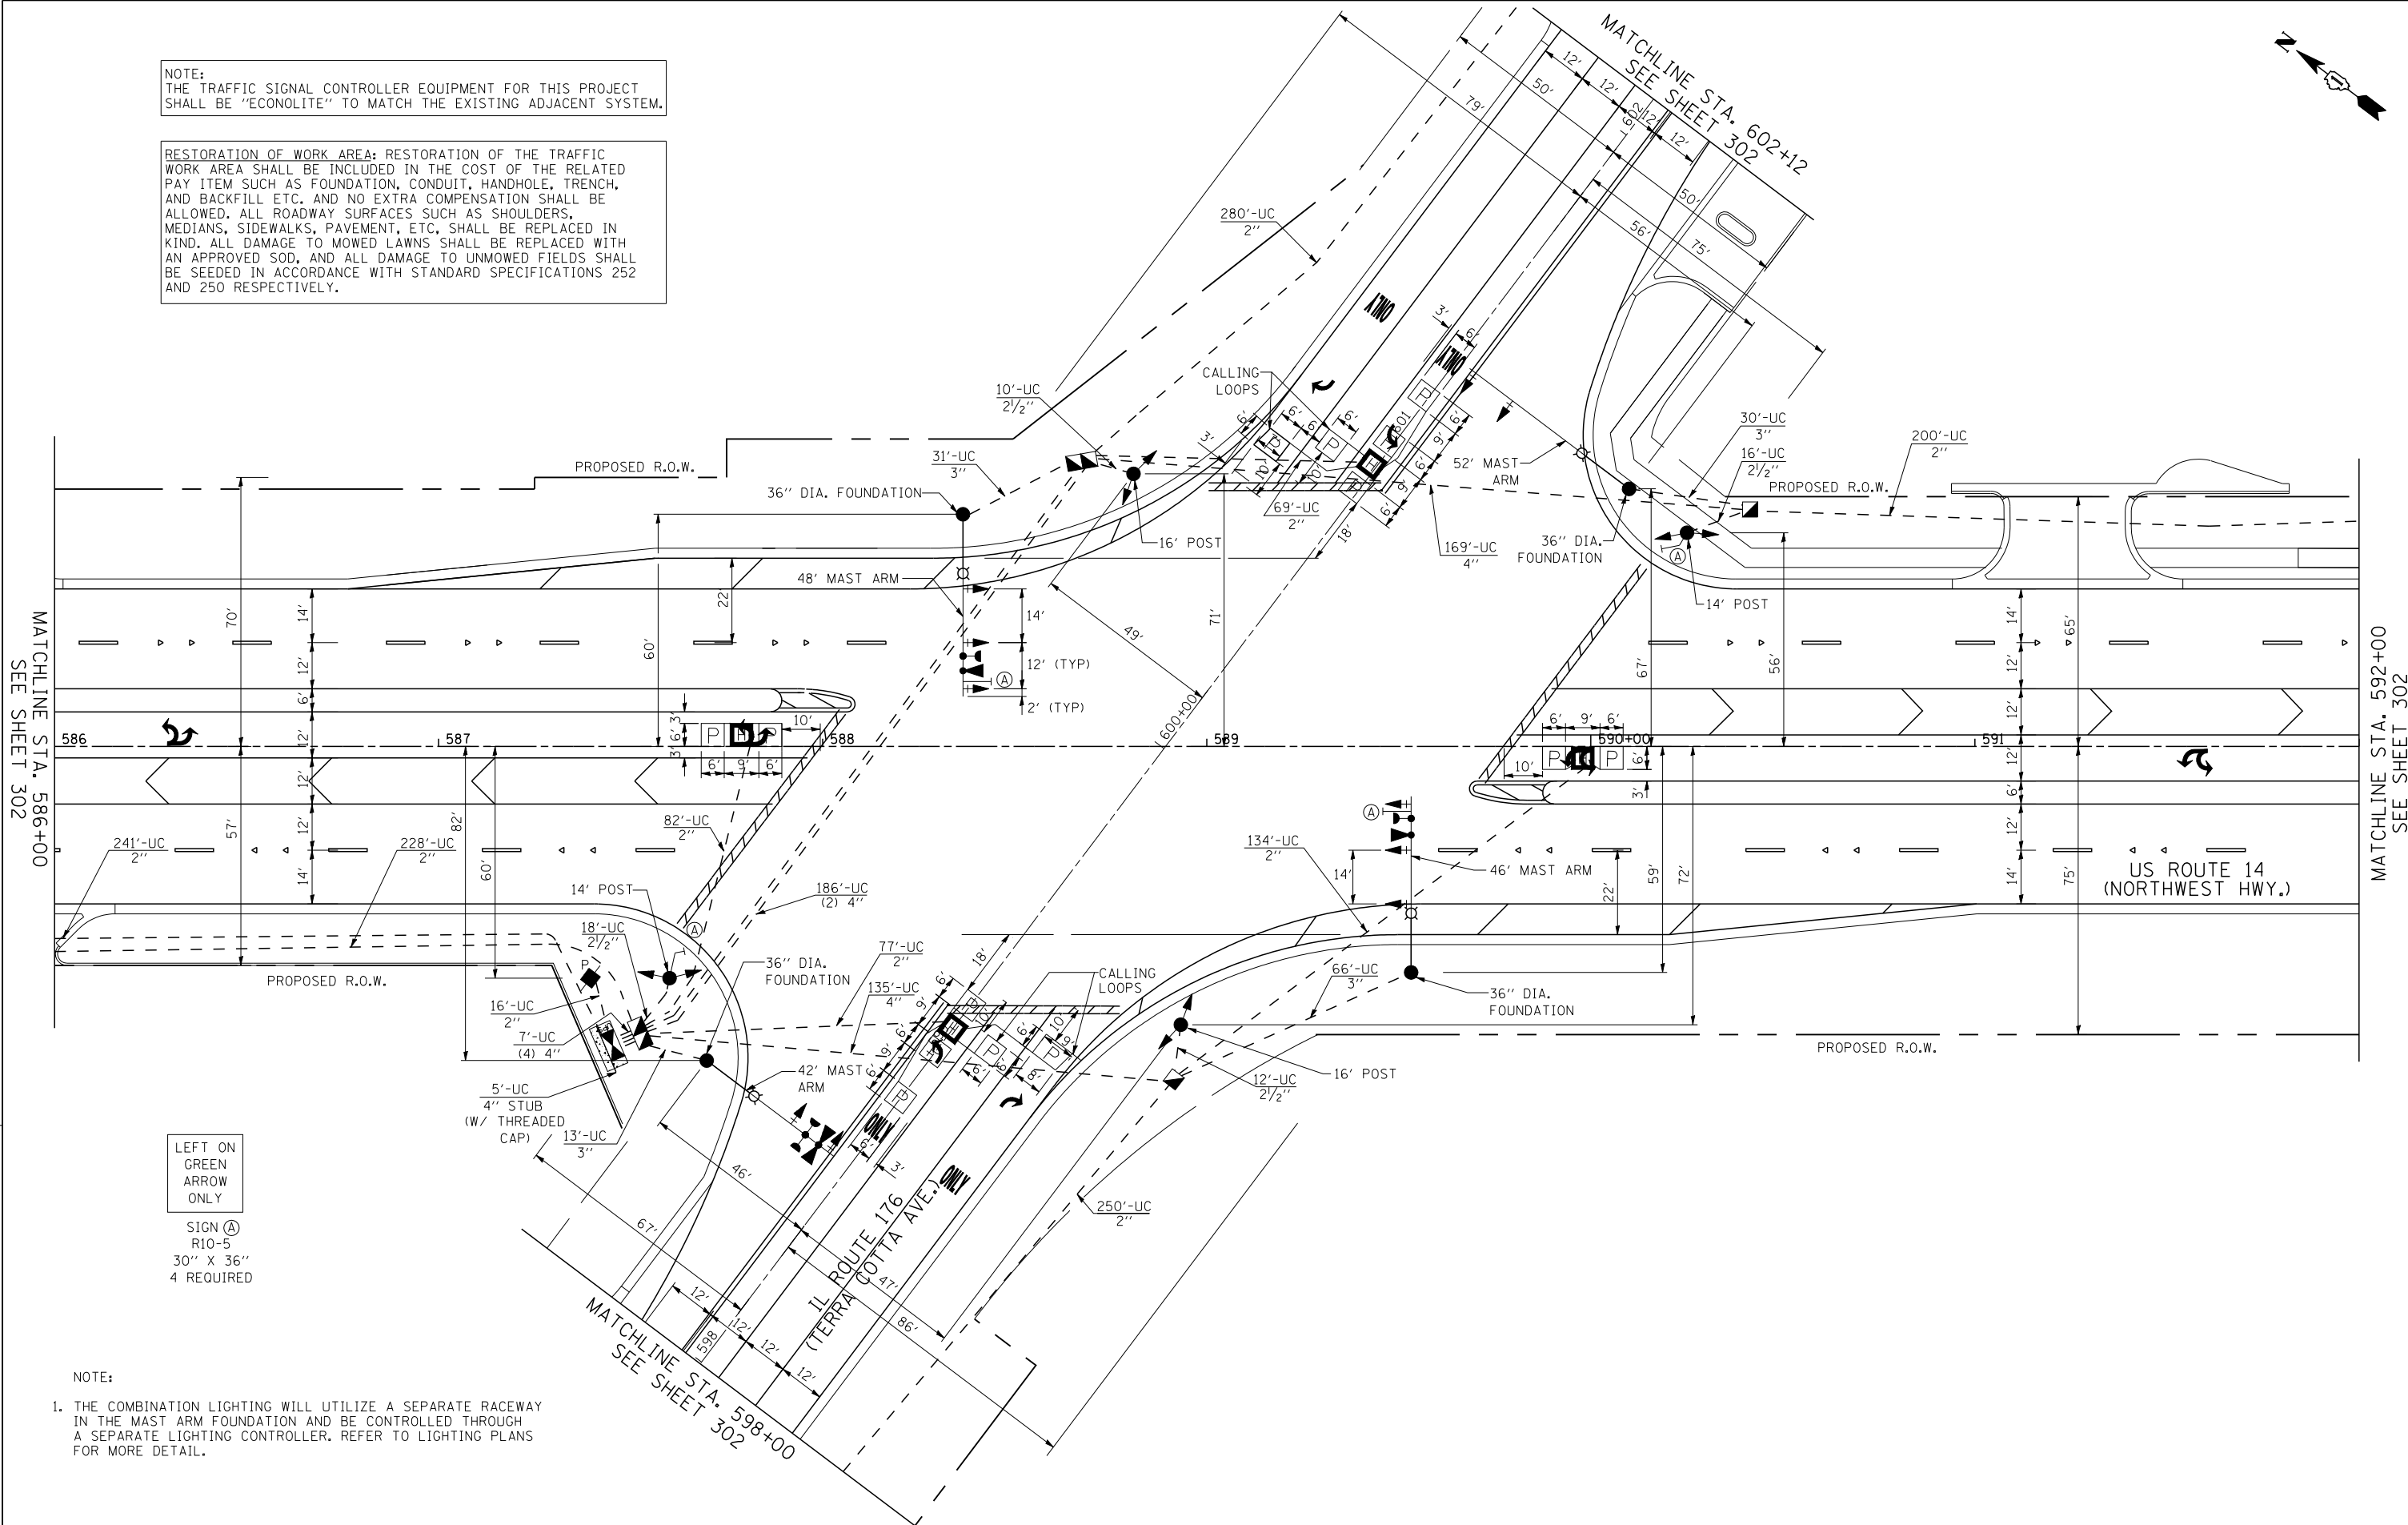


NOTE:  
THE TRAFFIC SIGNAL CONTROLLER EQUIPMENT FOR THIS PROJECT SHALL BE "ECONOLITE" TO MATCH THE EXISTING ADJACENT SYSTEM.

RESTORATION OF WORK AREA: RESTORATION OF THE TRAFFIC WORK AREA SHALL BE INCLUDED IN THE COST OF THE RELATED PAY ITEM SUCH AS FOUNDATION, CONDUIT, HANDHOLE, TRENCH, AND BACKFILL ETC. AND NO EXTRA COMPENSATION SHALL BE ALLOWED. ALL ROADWAY SURFACES SUCH AS SHOULDERS, MEDIANS, SIDEWALKS, PAVEMENT, ETC. SHALL BE REPLACED IN KIND. ALL DAMAGE TO MOWED LAWNS SHALL BE REPLACED WITH AN APPROVED SOD, AND ALL DAMAGE TO UNMOWED FIELDS SHALL BE SEEDED IN ACCORDANCE WITH STANDARD SPECIFICATIONS 252 AND 250 RESPECTIVELY.



LEFT ON GREEN ARROW ONLY

SIGN (A)  
R10-5  
30" X 36"  
4 REQUIRED

NOTE:  
1. THE COMBINATION LIGHTING WILL UTILIZE A SEPARATE RACEWAY IN THE MAST ARM FOUNDATION AND BE CONTROLLED THROUGH A SEPARATE LIGHTING CONTROLLER. REFER TO LIGHTING PLANS FOR MORE DETAIL.

**EJM ENGINEERING, INC.**  
411 South Wells Street Suite 1000  
Chicago, Illinois 60607



FILE NAME =  
...\\D162517-SHT-TS03.dgn

USER NAME = rswanson  
PLOT SCALE = 20:1  
PLOT DATE = 10/8/2013

DESIGNED - GR  
DRAWN - GR  
CHECKED - RS  
DATE - 10/15/2013

REVISED -  
REVISED -  
REVISED -  
REVISED -

**STATE OF ILLINOIS  
DEPARTMENT OF TRANSPORTATION**

**TRAFFIC SIGNAL INSTALLATION PLAN  
US RTE. 14 AND IL RTE. 176**

SCALE: 20:1 SHEET NO. 1 OF 2 SHEETS STA. TO STA.

F.A.P. RTE.	SECTION	COUNTY	TOTAL SHEETS	SHEET NO.
305	27R-3	MCHENRY	431	301
FED. ROAD DIST. NO. 1		ILLINOIS	FED. AID PROJECT	

CONTRACT NO. 62517