
 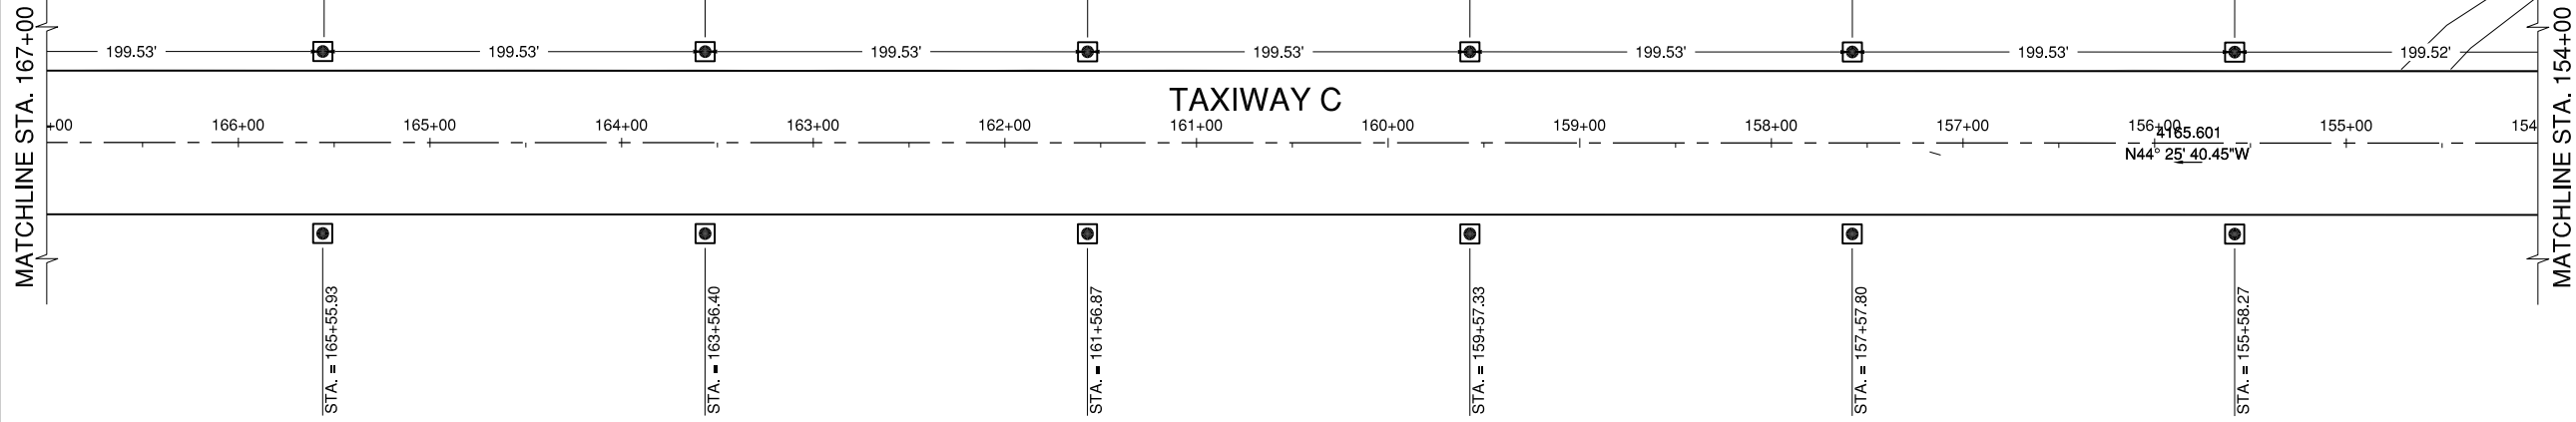


UN053

REVISIONS		
NUMBER	BY	DATE




LEGEND

- NEW BASE MOUNTED TAXIWAY LIGHT
- NEW TAXIWAY GUIDANCE SIGN
- RELOCATED RGL
- NEW 4-WAY DUCT BANK
- NEW SPLIT DUCT
- EXISTING STAKE MOUNTED LIGHT
- EXISTING BASE MOUNTED LIGHT

NOTES:

1. LIGHTS ARE SHOWN AT 10' OFF EDGE OF PAVEMENT. SEE EDGE LIGHT DETAIL FOR MORE INFORMATION.
2. RELOCATE EXISTING RGL LIGHTS TO LOCATION SHOWN. SEE RGL DETAIL FOR MORE INFORMATION.

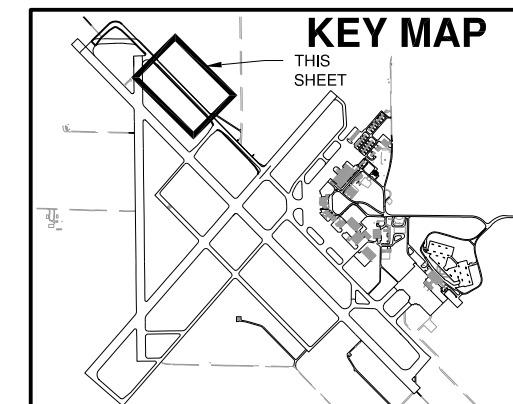

UNIVERSITY OF ILLINOIS
 WILLARD AIRPORT
 SAVOY, ILLINOIS

**BASE BID - REALIGN AND WIDEN TAXIWAY C
 PROPOSED LIGHTING LAYOUT 2**

© Copyright CMT, Inc.
CMT
 CRAWFORD, MURPHY & TILLY, INC.
 CONSULTING ENGINEERS
 License No. 184-000613

DESIGN BY:	CBG
DRAWN BY:	ADD
CHECKED BY:	CET
APPROVED BY:	CET
DATE:	JUNE 27, 2014
JOB No:	13059-02-00
IL PROJ. NO. CMI-4347 AIP PROJ. NO. 3-17-0016-XX	
SHEET	41 OF 83 SHEETS