


SIGN DETAIL
1:75

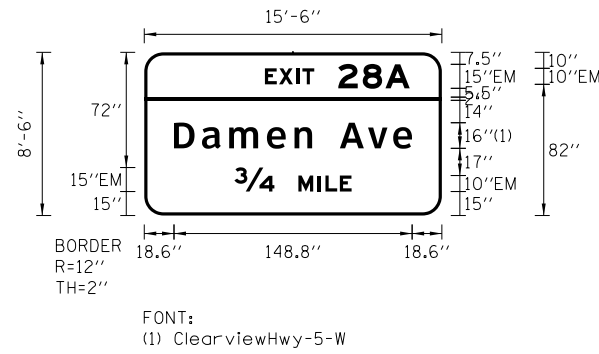

SIGN NUMBER	WB-05-BM
WIDTH x HGHT.	15'-6" x 8'-6"
BORDER WIDTH	2"
CORNER RADIUS	12"
MOUNTING	Overhead
BACKGROUND	TYPE: ZZ Retro Reflective COLOR: Green
LEGEND/BORDER	TYPE: Reflective COLOR: White /White


SYMBOL	ROT	X	Y	WID	HT

Panel Style: guide_exp_advance_a.ssi
Dimensions are in inches,tenths

Letter locations are panel edge to lower left corner

LETTER POSITIONS (X)													LENGTH	SERIES/SIZE
E	X	I	T	2	8	A							90.5	EM 2000
75.5	84.3	95.1	98.9	121.3	136.6	150.8								10,15
D	a	m	e	n		A	v	e					148.8	ClearviewHwy-5-W
18.6	36.1	53.1	76.7	93.9	105	122.3	139.9	155.6						1613
34	M	I	L	E									73.3	EM 2000
56.4	96.4	108.5	113.3	122.3										15,10

SIGN DETAIL
1:75

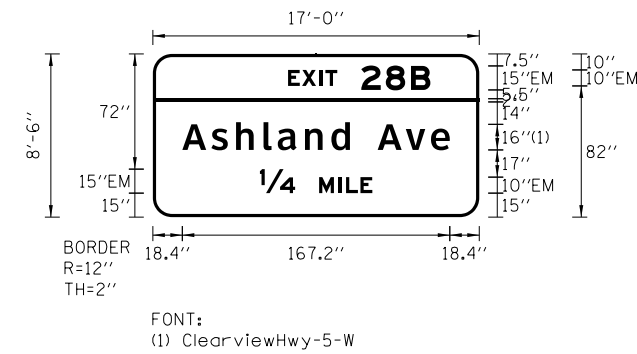

SIGN NUMBER	WB-06-BM
WIDTH x HGHT.	17'-0" x 8'-6"
BORDER WIDTH	2"
CORNER RADIUS	12"
MOUNTING	Overhead
BACKGROUND	TYPE: ZZ Retro Reflective COLOR: Green
LEGEND/BORDER	TYPE: Reflective COLOR: White/White

SYMBOL	ROT	X	Y	WID	HT

Panel Style: guide_exp_advance_a.ssi
Dimensions are in inches,tenths

Letter locations are panel edge to lower left corner

LETTER POSITIONS (X)													LENGTH	SERIES/SIZE
E	X	I	T	2	8	B							89	EM 2000
84.5	93.3	104.1	107.9	130.3	145.6	161.3								10,15
A	s	h	l	a	n	d		A	v	e			167.2	ClearviewHwy-5-W
18.4	36.6	52	69.2	78.1	95.1	111.6	123.3	140.5	158.1	173.9				1613
1/4	M	I	L	E									70.3	EM 2000
66.9	103.9	116	120.8	129.8										15,10

FILE PATH = par\388039-par\1-escomon\line\local\p\wec\00\Documents\01_Americas\Transportation\60269938_Circle Phase_1\000_CAD\006_Roadway_Sheets\60W25_sht-Sign-Bridge-Detail-01



DI60W25-sht-Sign-Bridge-Detail-01
USER NAME = moronik
PLOT SCALE = 5.0000' / in.
PLOT DATE = 5/15/2013

DESIGNED - AFC	REVISED -
DRAWN - AFC	REVISED -
CHECKED - DBM	REVISED -
DATE - 5/14/2013	REVISED -

STATE OF ILLINOIS
DEPARTMENT OF TRANSPORTATION

OVERHEAD SIGN PANEL DETAILS
SCALE: NTS SHEET 1 OF 2 SHEETS STA. TO STA.

F.A.I. RTE.	SECTION	COUNTY	TOTAL SHEETS	SHEET NO.
90/94/290	2013-007R	COOK	317	114
CONTRACT NO. 60W25				
ILLINOIS FED. AID PROJECT				