



TYPICAL SPLICE DETAIL

N.T.S.

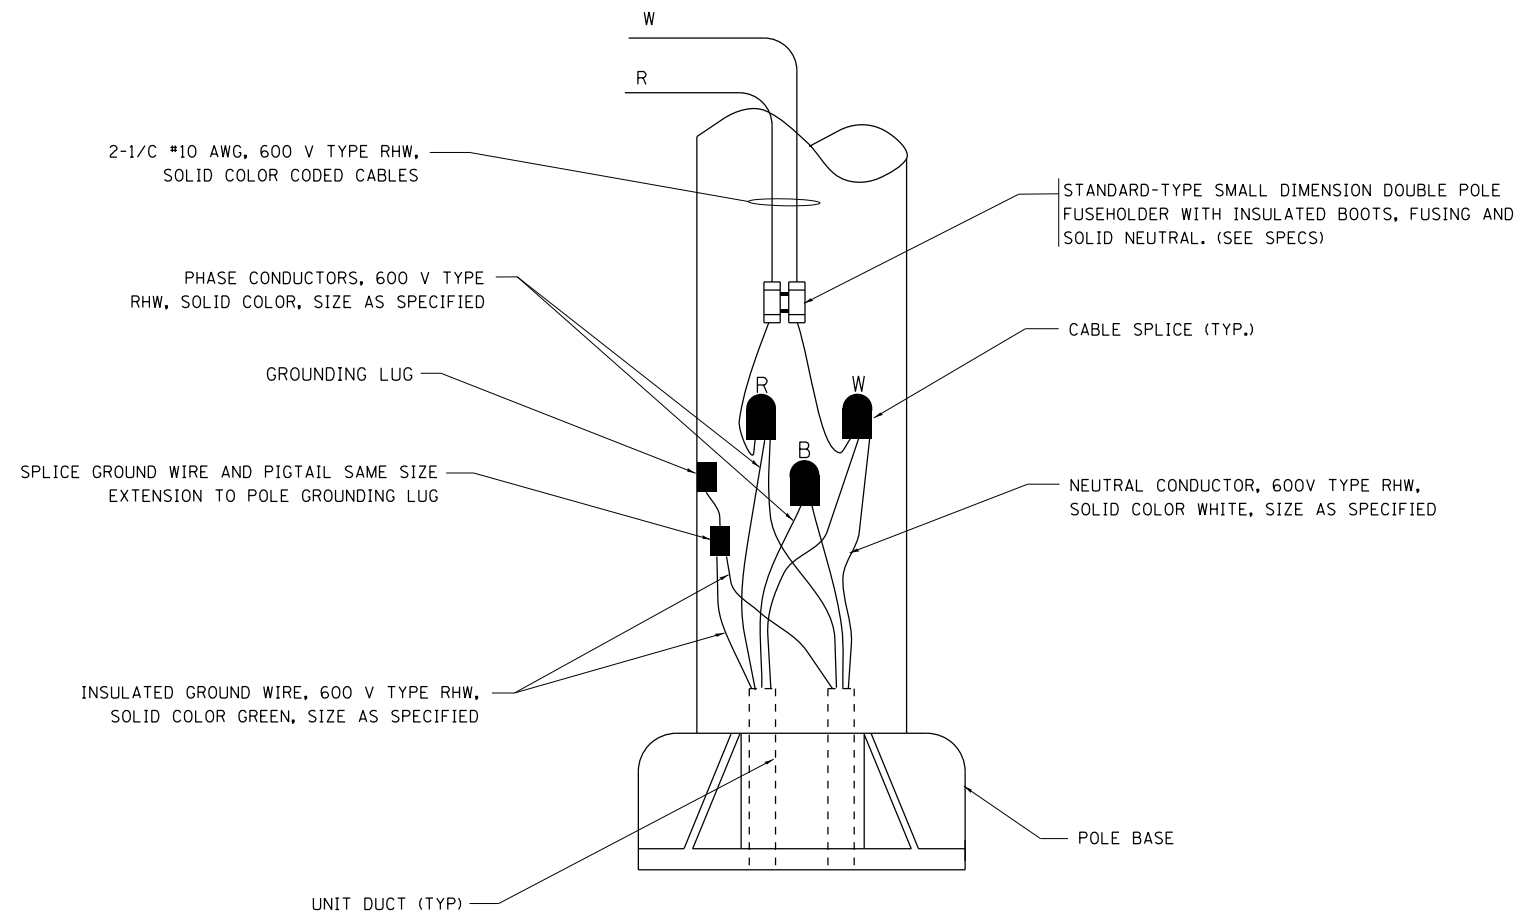

POLE WIRING DETAIL

N.T.S.

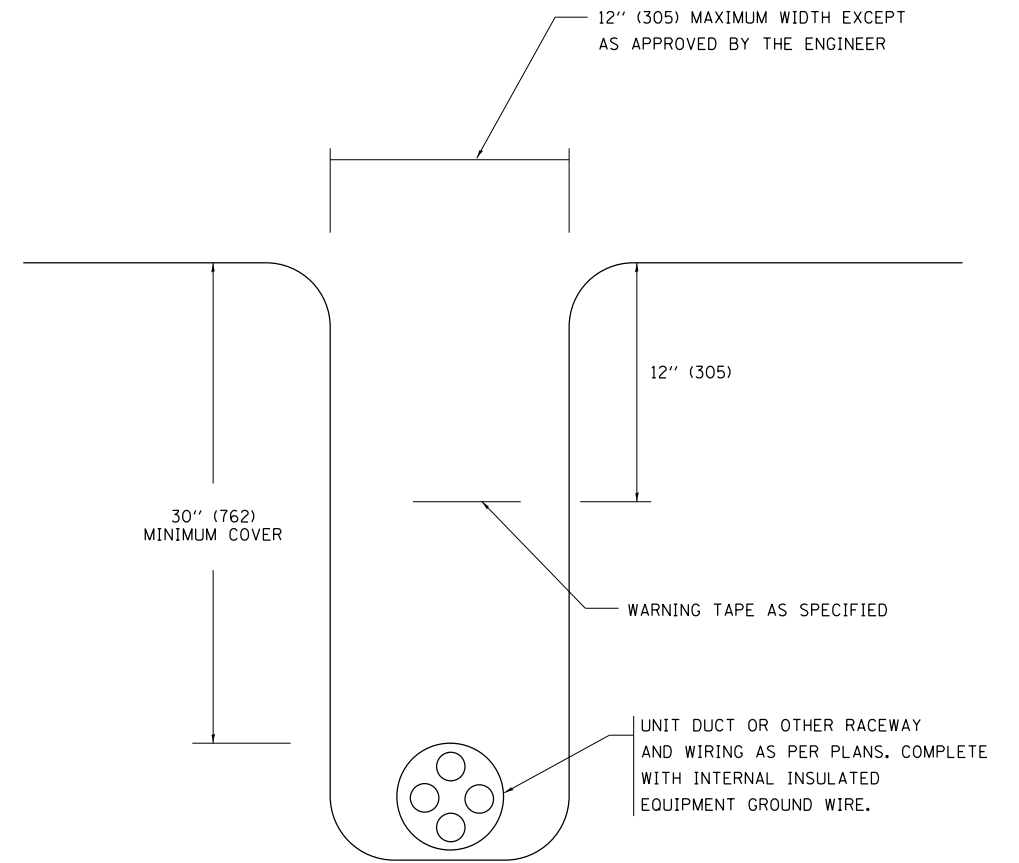

TYPICAL WIRING IN TRENCH DETAIL

N.T.S.

| | | | |
|--|---|---------------------------------------|---------------------------------------|
| FILE NAME = | USER NAME = pteip2 | DESIGNED - | REVISED - 08-08-03 |
| p:\388039-pwintl\ecomonline\local\pwae | C:\00\Documents\01 Americas\Transportation\ | DRAWN CirclePhase.II\000.CAD\006.Road | REVISED 60W25.Contract\DI60W25-SHT-DI |
| PLOT SCALE = 50.000' / in. | CHECKED - | REVISOR - | DATE - |
| PLOT DATE = 5/15/2013 | DATE - | REVISOR - | DATE - |

**STATE OF ILLINOIS
DEPARTMENT OF TRANSPORTATION**

| | | | |
|---------------------------------|---------------------------|------|---------|
| MISC. ELECTRICAL DETAILS | | | |
| SHEET A | | | |
| SCALE: NONE | SHEET NO. 14 OF 31 SHEETS | STA. | TO STA. |

| | | | | |
|---|-----------|---------------------------|--------------|-----------|
| F.A.I. RE. | SECTION | COUNTY | TOTAL SHEETS | SHEET NO. |
| * | 2013-007R | COOK | 317 | 246 |
| BE-702 | | CONTRACT NO. 60W25 | | |
| FED. ROAD DIST. NO. 1 ILLINOIS FED. AID PROJECT | | | | |
| • 90/94/290 | | | | |