
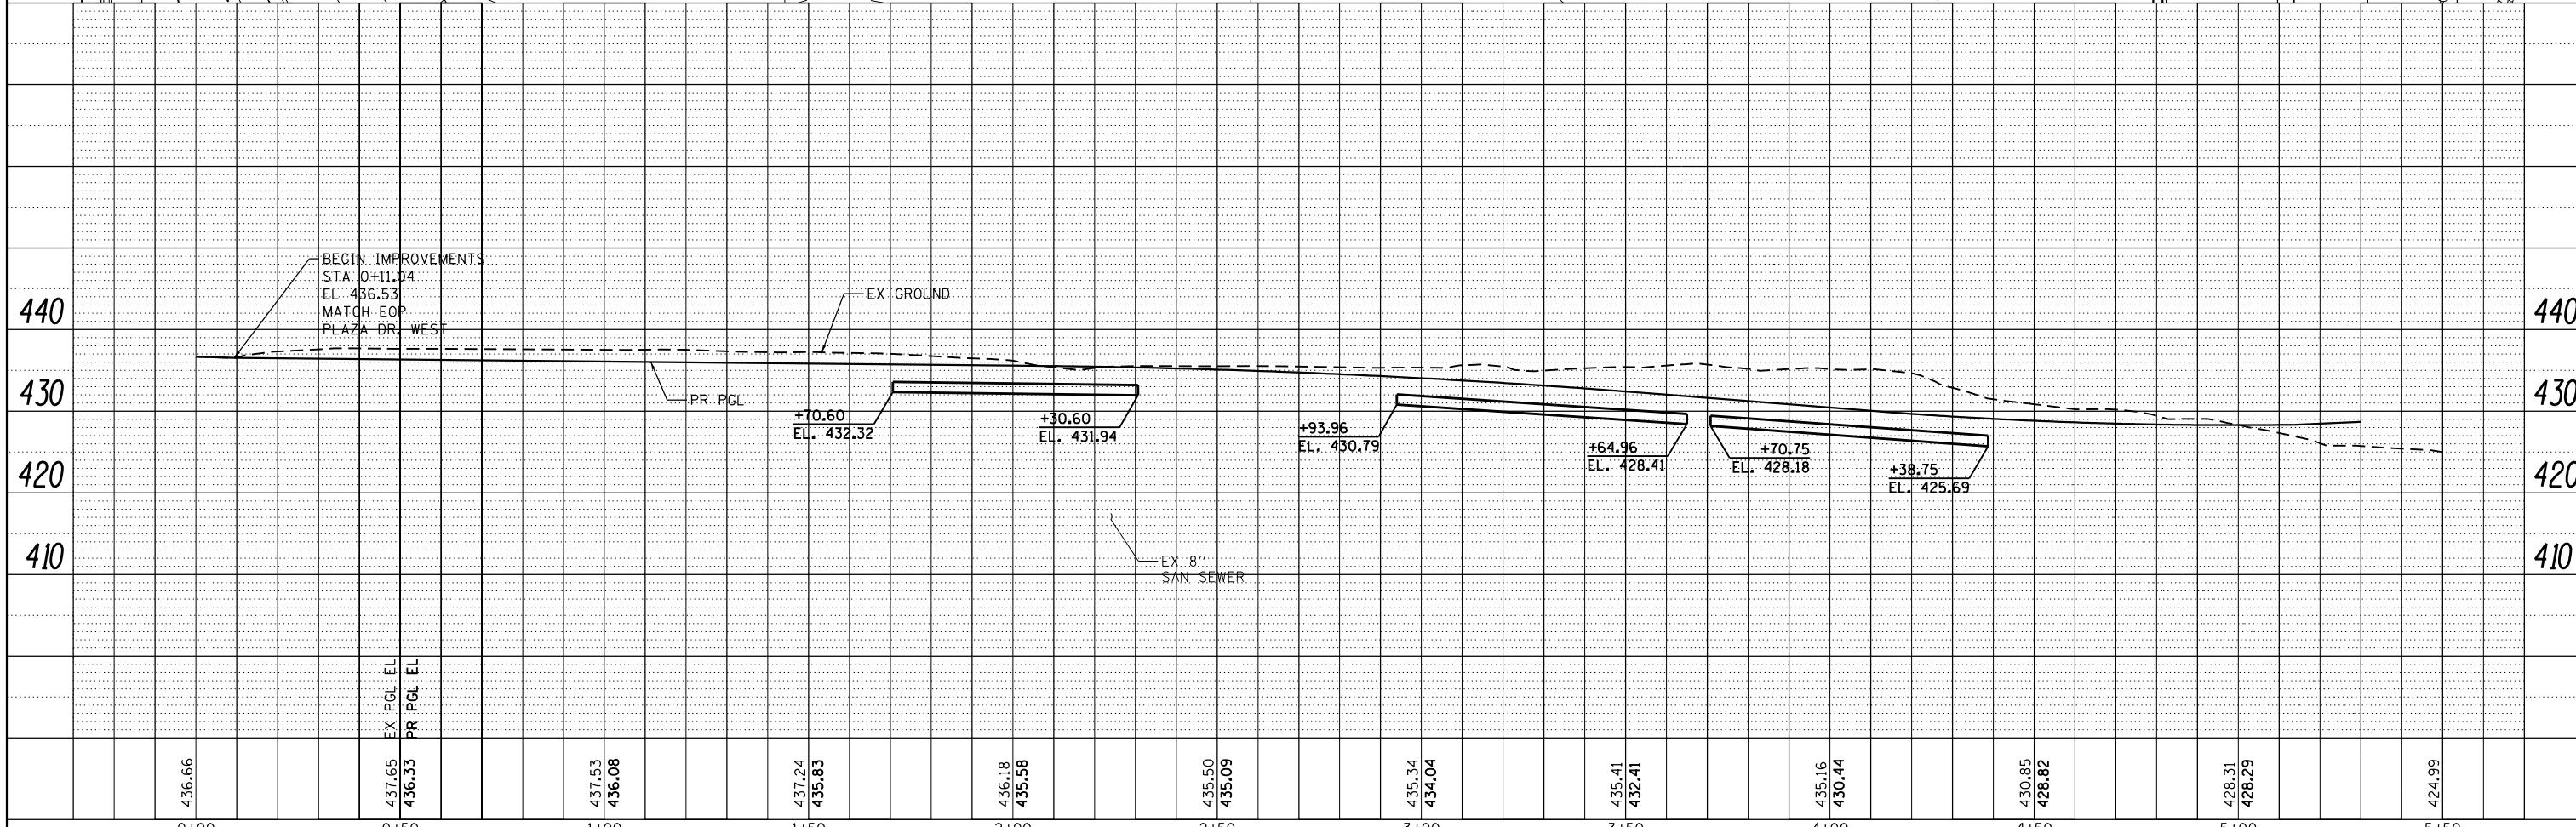


PLAN	SURVEYED	BY	DATE
	PLOTTED		
	ALIGNED		
	CHECKED		
	DESIGNED		
	FILE NAME		
	NO.		

PROFILE	SURVEYED	BY	DATE
	PLOTTED		
	GRADES CHECKED		
	STRUCTURE		
	NOTATIONS		
	NO.		

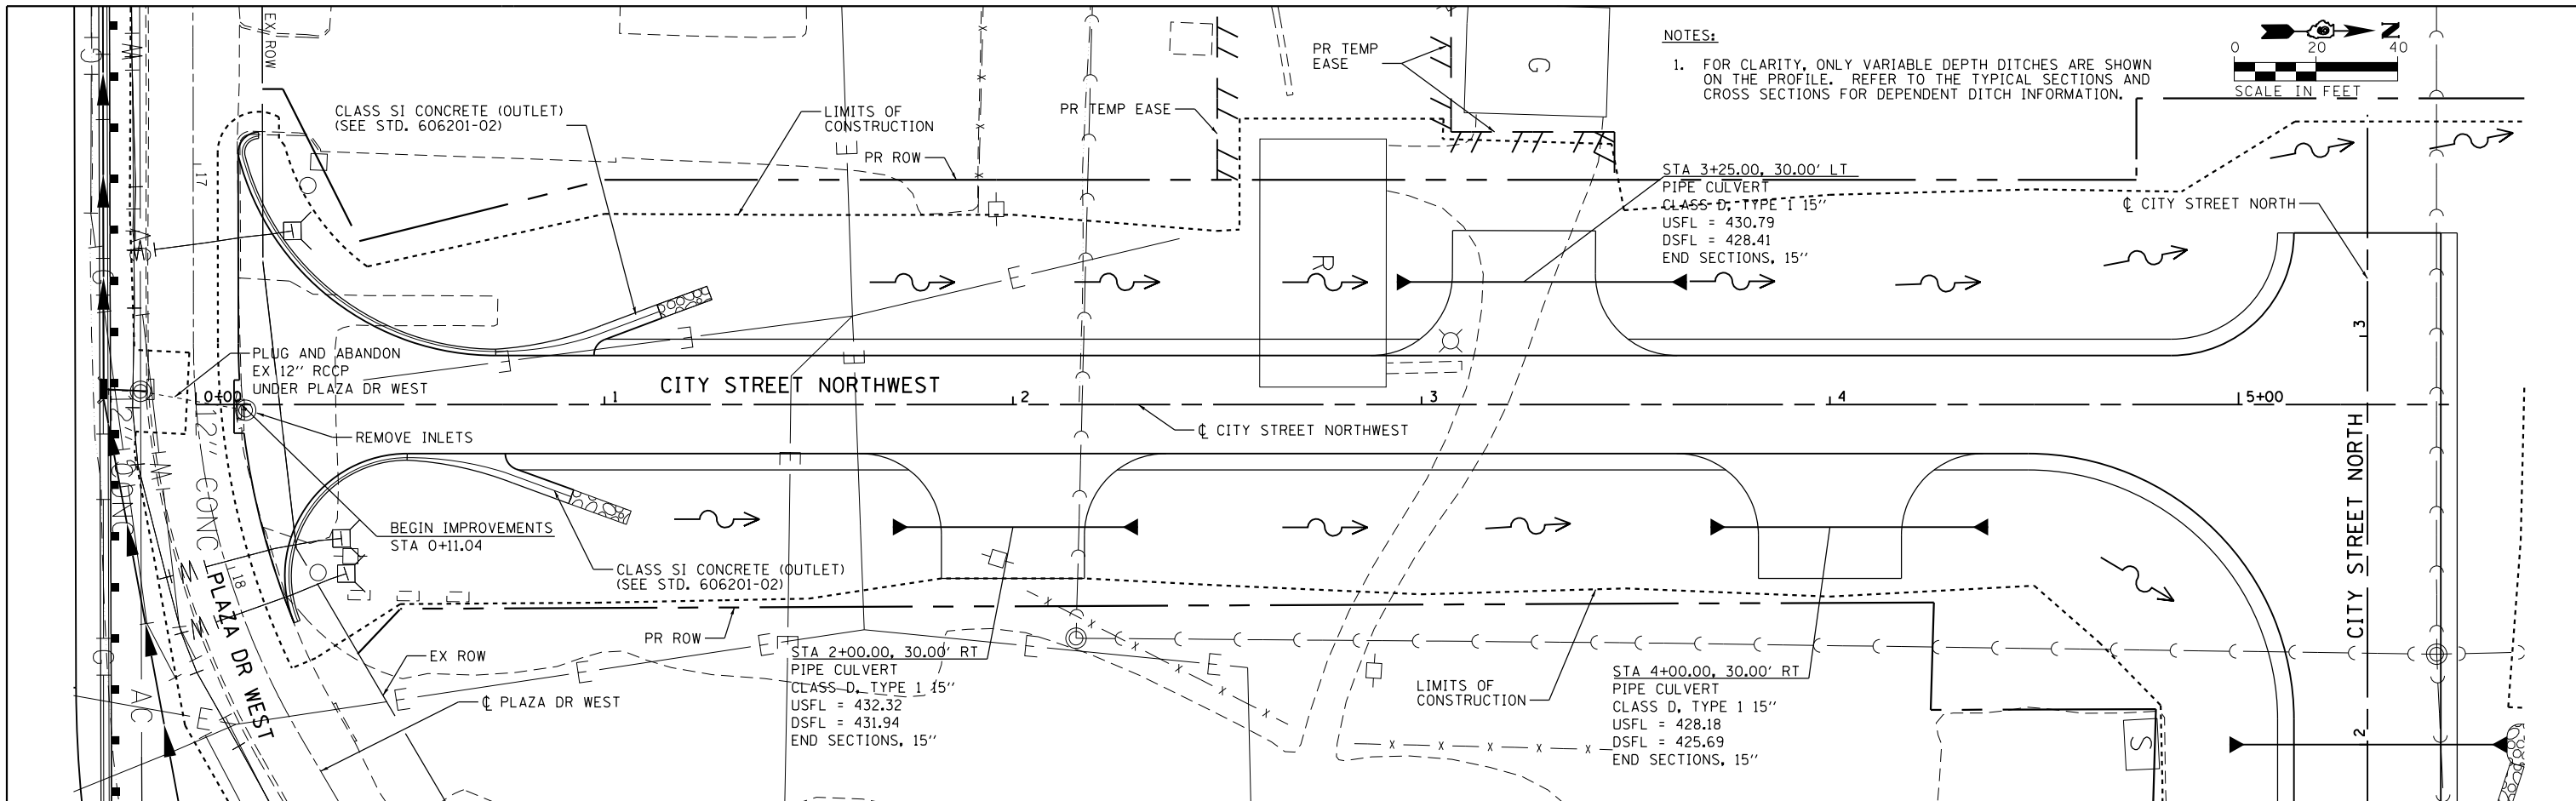

FILE NAME =	USER NAME = lovenderba	DESIGNED - KN	REVISED -
c:\pwork\pwork\lovederba\0335666\0978258-shd-drain-08.dgn		DRAWN - AS	REVISED -
PLOT SCALE = 40.0000' / in.		CHECKED -	REVISED -
PLOT DATE = 3/22/2013		DATE -	REVISED -

CH2MHILL

STATE OF ILLINOIS
DEPARTMENT OF TRANSPORTATION

DRAINAGE AND UTILITY PLANS
CITY STREET NORTHWEST

SCALE: SHEET NO. 10 OF 43 SHEETS STA. 0+11.04 TO STA. 5+51.56

F.A.P. RTE.	SECTION	COUNTY	TOTAL SHEETS	SHEET NO.
331	(1-4)R-2, N-4, TS-4	WILLIAMSON	381	165
DRAWING NO. DU-10			CONTRACT NO. 78258	
ILLINOIS FED. AID PROJECT				