

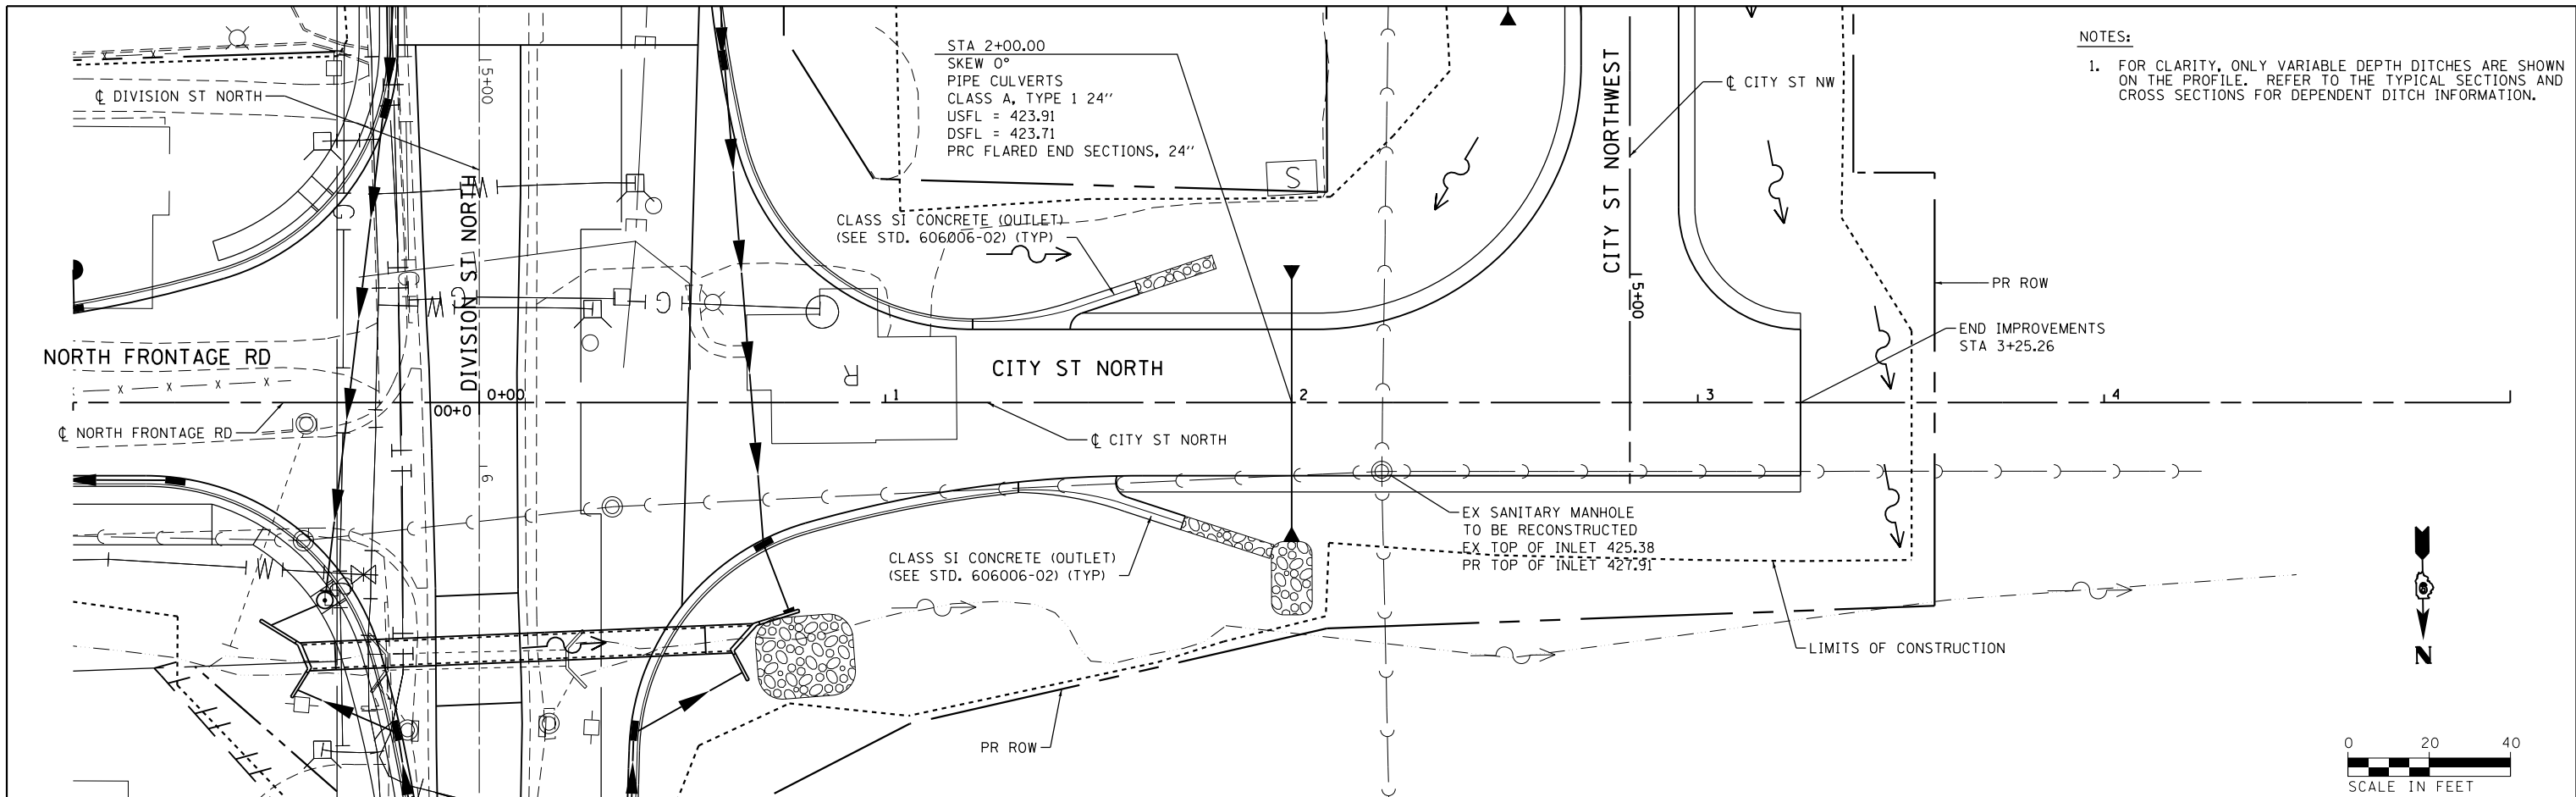


PLAN	SURVEYED	DATE
	PLOTTED	BY
	GRADES CHECKED	
	STRUCTURE NOTATIONS CHECKED	
	NOTE BOOK NO.	
	CADD FILE NAME	

PROFILE	SURVEYED	DATE
	PLOTTED	BY
	GRADES CHECKED	
	STRUCTURE NOTATIONS CHECKED	
	NOTE BOOK NO.	
	CADD FILE NAME	

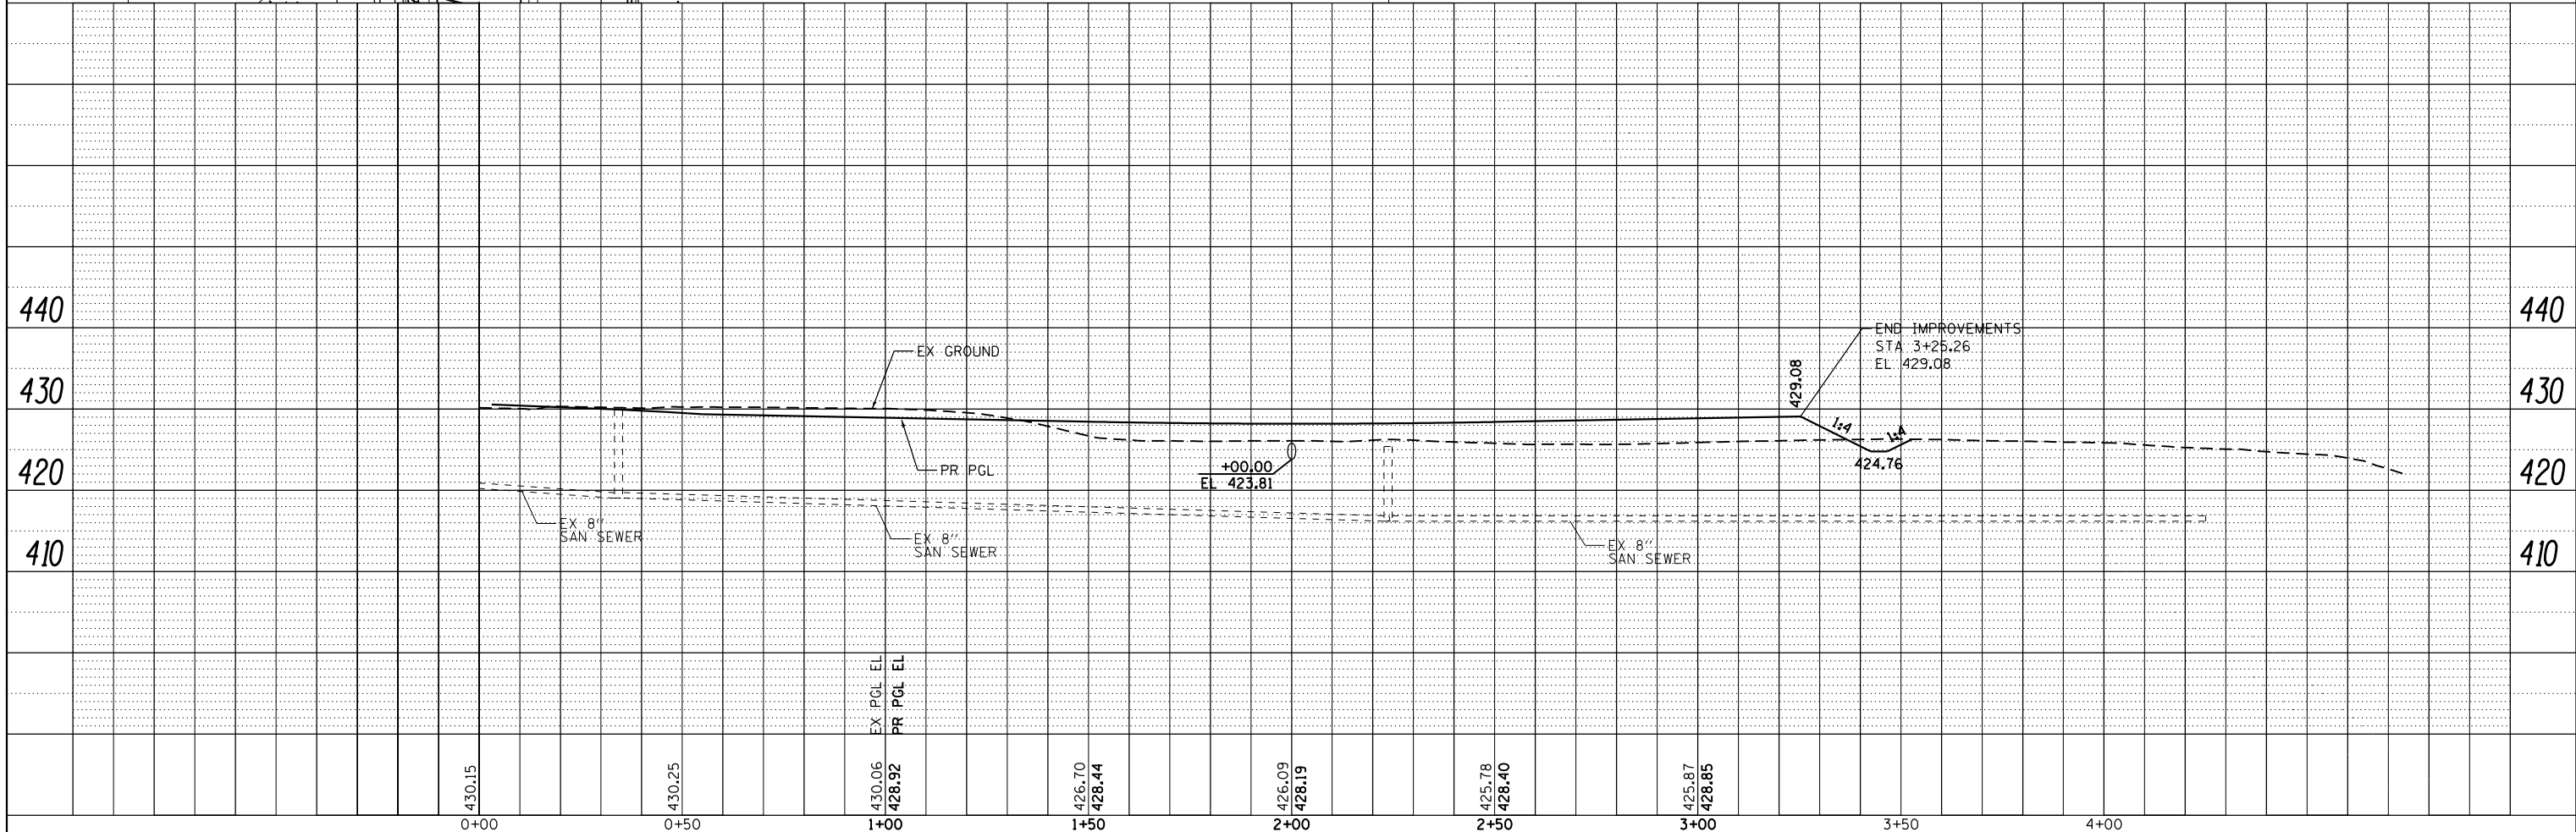

NOTES:
 1. FOR CLARITY, ONLY VARIABLE DEPTH DITCHES ARE SHOWN ON THE PROFILE. REFER TO THE TYPICAL SECTIONS AND CROSS SECTIONS FOR DEPENDENT DITCH INFORMATION.

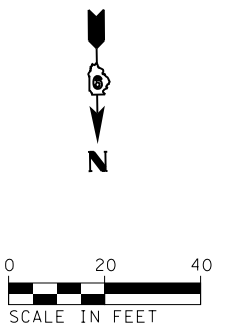

FILE NAME =	USER NAME = lovenderba	DESIGNED - KN	REVISED -	STATE OF ILLINOIS DEPARTMENT OF TRANSPORTATION	DRAINAGE AND UTILITY PLANS CITY STREET NORTH	F.A.P. RTE.	SECTION	COUNTY	TOTAL SHEETS	SHEET NO.
c:\pwork\pwork\lovenderba\0335666\0978258-shr-drain-09.dgn	DRAWN - AS	REVISED -	331			(1-4)R-2, N-4, TS-4	WILLIAMSON	381	166	
PLOT SCALE = 40.0000' / in.	CHECKED -	REVISED -	DRAWING NO. DU-11			CONTRACT NO. 78258				
PLOT DATE = 3/22/2013	DATE -	REVISED -	ILLINOIS FED. AID PROJECT							