



JUN 17, 2013 12:12 PM HARR01115
 pw:\sgr-svr306\hanson\Projects\Documents\12a0053\12a0053D\CAD\Airport\Sheet\C-141-ELE

MATCHLINE - STA. 129+50 RUNWAY 9-27

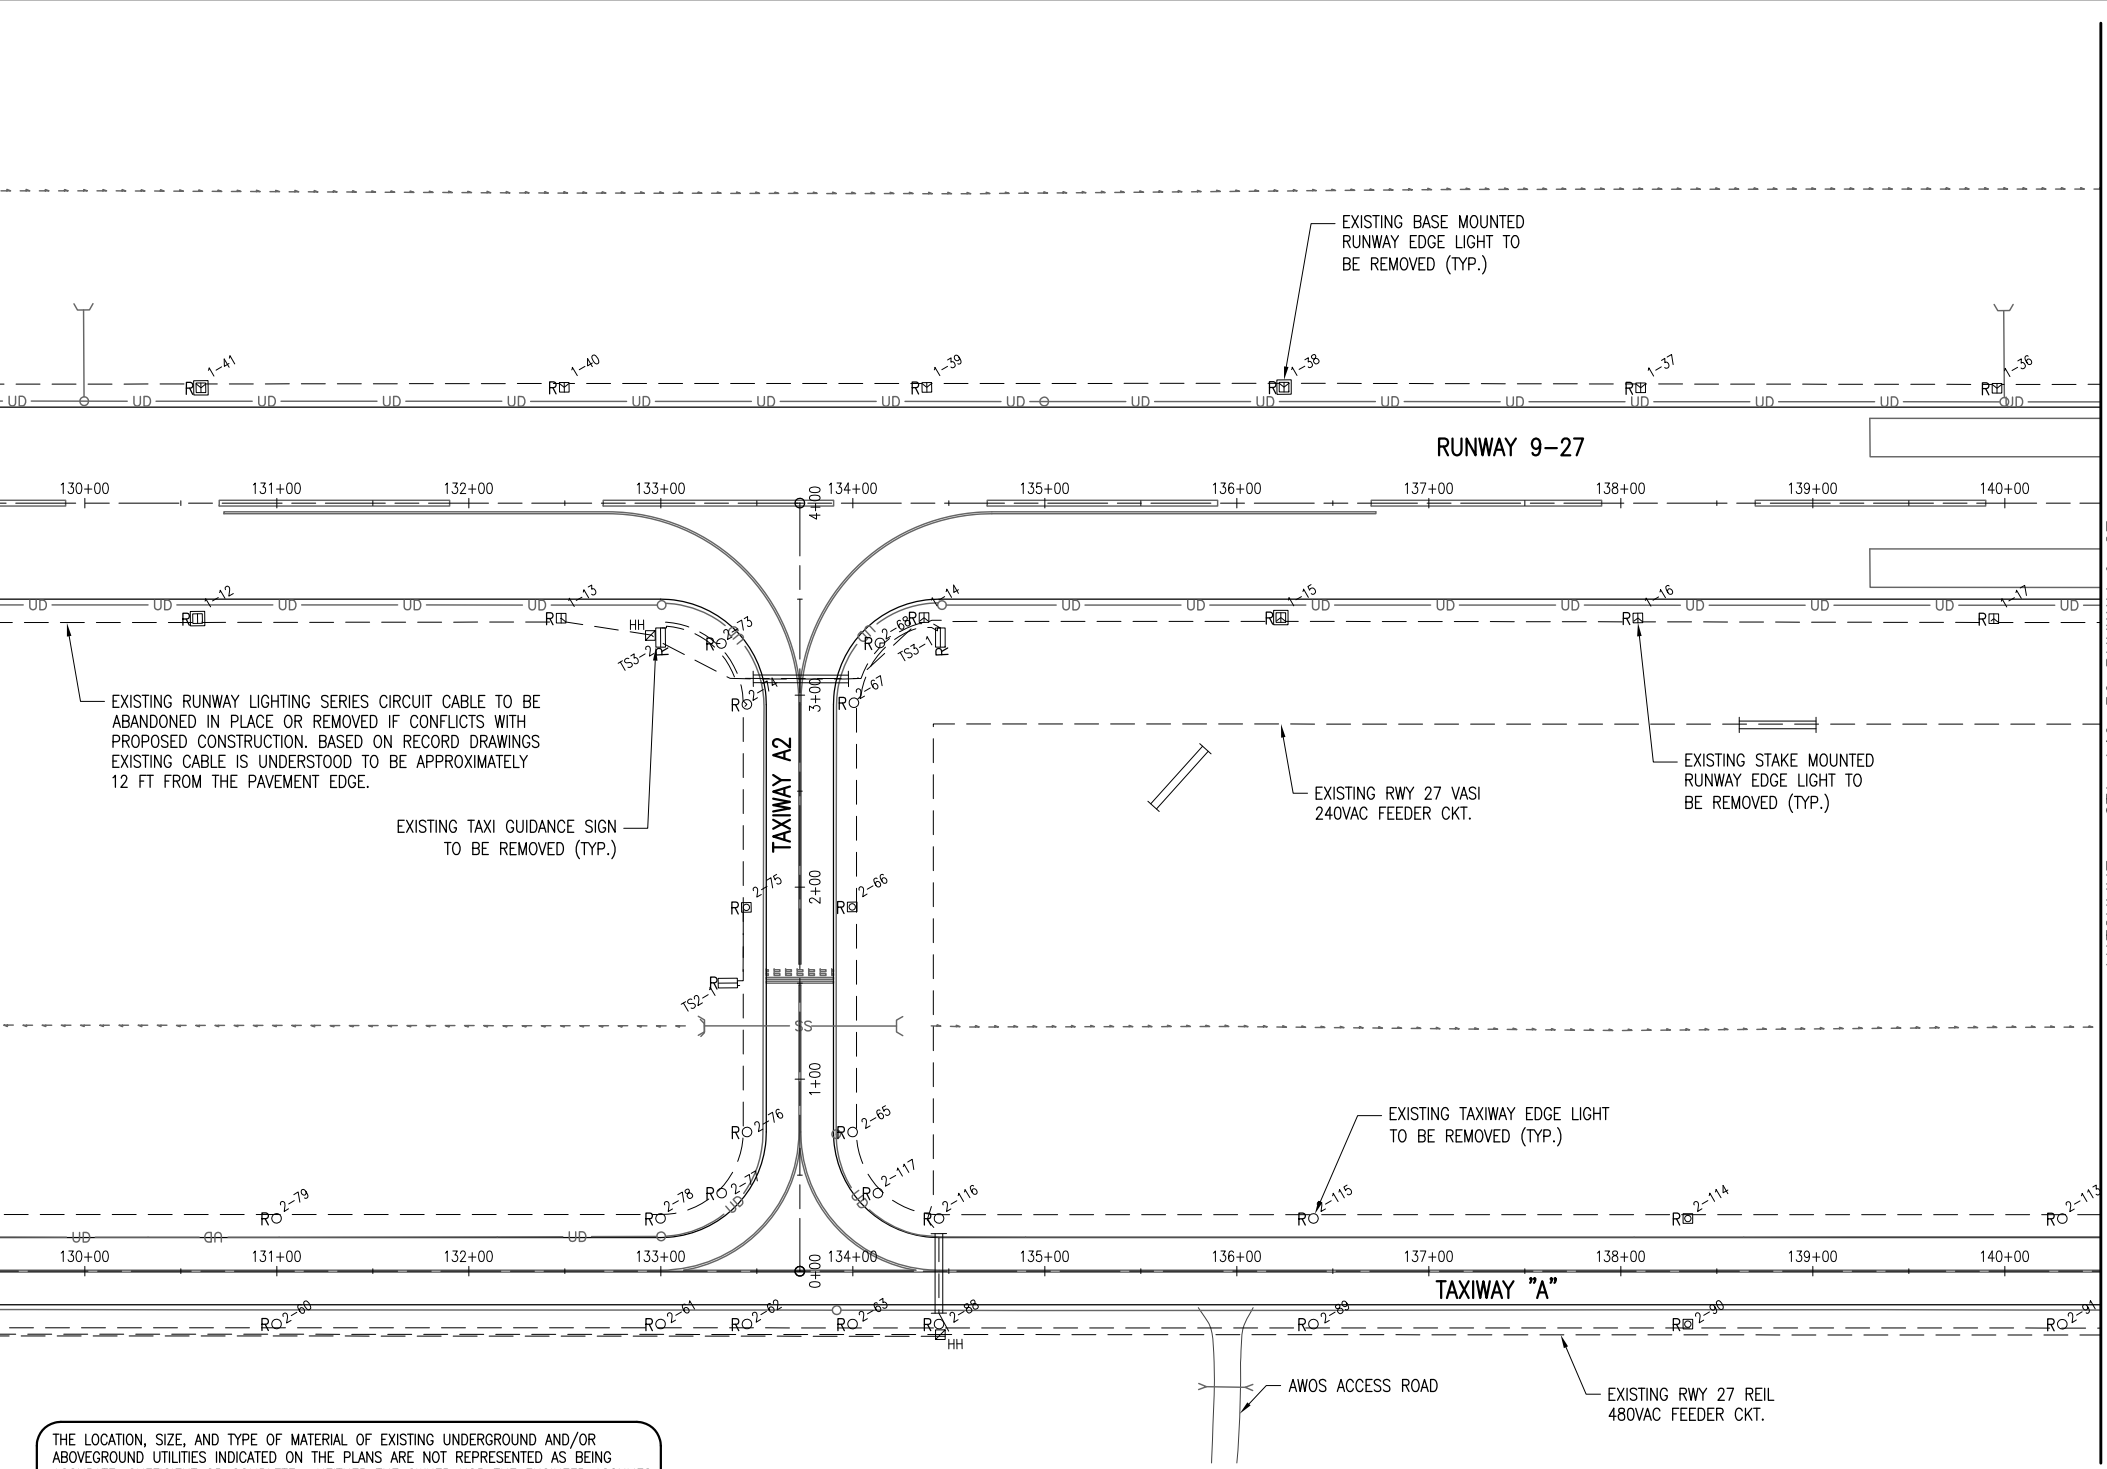

THE LOCATION, SIZE, AND TYPE OF MATERIAL OF EXISTING UNDERGROUND AND/OR ABOVEGROUND UTILITIES INDICATED ON THE PLANS ARE NOT REPRESENTED AS BEING ACCURATE, SUFFICIENT OR COMPLETE. NEITHER THE OWNER NOR THE ENGINEER ASSUMES ANY RESPONSIBILITY WHATEVER IN RESPECT TO THE ACCURACY, COMPLETENESS, OR SUFFICIENCY OF THE INFORMATION. THERE IS NO GUARANTEE, EITHER EXPRESSED OR IMPLIED, THAT THE LOCATIONS, SIZE AND TYPE OF MATERIAL OF EXISTING UNDERGROUND UTILITIES INDICATED ARE REPRESENTATIVE OF THOSE TO BE ENCOUNTERED IN THE CONSTRUCTION. IT SHALL BE THE CONTRACTOR'S RESPONSIBILITY TO DETERMINE THE ACTUAL LOCATION OF ALL SUCH FACILITIES, INCLUDING SERVICE CONNECTIONS TO UNDERGROUND UTILITIES. PRIOR TO CONSTRUCTION, THE CONTRACTOR SHALL NOTIFY THE UTILITY COMPANIES OF HIS OPERATIONAL PLANS AND SHALL OBTAIN FROM THE RESPECTIVE UTILITY COMPANIES DETAILED INFORMATION AND ASSISTANCE RELATIVE TO THE LOCATION OF THEIR FACILITIES AND THE WORKING SCHEDULE OF THE COMPANIES FOR REMOVAL OR ADJUSTMENT WHERE REQUIRED. IN THE EVENT AN UNEXPECTED UTILITY INTERFERENCE IS ENCOUNTERED DURING CONSTRUCTION, THE CONTRACTOR SHALL IMMEDIATELY NOTIFY THE UTILITY COMPANY OF JURISDICTION. THE OWNER'S REPRESENTATIVE AND/OR THE RESIDENT ENGINEER SHALL ALSO BE IMMEDIATELY NOTIFIED. ANY DAMAGE TO SUCH MAINS AND SERVICES SHALL BE RESTORED TO SERVICE AT ONCE AND PAID FOR BY THE CONTRACTOR AT NO ADDITIONAL COST TO THE CONTRACT.

ALL UTILITY CABLES AND LINES SHALL BE LOCATED BY THE RESPECTIVE UTILITY. **CONTACT JULIE (JOINT UTILITY LOCATION INFORMATION FOR EXCAVATORS) FOR UTILITY INFORMATION, PHONE: 1-800-892-0123.** CONTACT THE FAA (FEDERAL AVIATION ADMINISTRATION) FOR ASSISTANCE IN LOCATING FAA CABLES AND UTILITIES. LOCATION OF FAA POWER, CONTROL, AND COMMUNICATION CABLES SHALL BE COORDINATED WITH AND/OR LOCATED BY THE FAA. ALSO CONTACT AIRPORT DIRECTOR/MANAGER AND AIRPORT PERSONNEL FOR ASSISTANCE IN LOCATING UNDERGROUND AIRPORT CABLES AND/OR UTILITIES. ALSO COORDINATE WORK WITH ALL ABOVEGROUND UTILITIES.

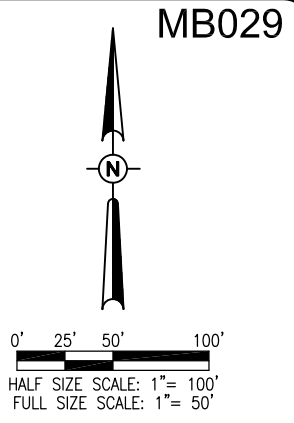

MATCHLINE - STA. 140+50 RUNWAY 9-27

LEGEND

	EXISTING PAVEMENT
	EXISTING BUILDING
	EXISTING ELECTRICAL DUCT
	EXISTING DITCH
	EXISTING ELECTRICAL CABLE
	EXISTING WATER
	EXISTING TELEPHONE
	EXISTING UNDERDRAIN
	EXISTING STORM SEWER
	EXISTING SANITARY
	EXISTING UNDERGROUND ELECTRICAL
	EXISTING REIL (TO BE REMOVED)
	EXISTING TAXI GUIDANCE SIGN (TO BE REMOVED)
	EXISTING STAKE MOUNTED TAXIWAY LIGHT (TO BE REMOVED)
	EXISTING BASE MOUNTED TAXIWAY LIGHT (TO BE REMOVED)
	EXISTING STAKE MOUNTED RUNWAY LIGHT (TO BE REMOVED)
	EXISTING BASE MOUNTED RUNWAY LIGHT (TO BE REMOVED)
	EXISTING STAKE MOUNTED THRESHOLD LIGHT (TO BE REMOVED)
	EXISTING BASE MOUNTED THRESHOLD LIGHT (TO BE REMOVED)
	EXISTING AIRPORT ROTATING BEACON

REVISION	
DATE	

**MACOMB MUNICIPAL AIRPORT
 MACOMB, ILLINOIS**

BLOCK GRANT PROJ.: 3-17-0064-B21
 IL PROJ.: MGB-4206

Hanson Proj. No. 12A0053	12/03/12
Filename C-141-ELE.dwg	DAW
Scale AS SHOWN	DAW
Date 06/17/13	REVIEWED
	KNL/CAH



**REPLACE VAULT, AIRFIELD
 LIGHTING AND GUIDANCE SIGNS**

**EXISTING ELECTRICAL PLAN
 STA. 129+50 TO 140+50**