


0' 25' 50' 100'  
 HALF SIZE SCALE: 1" = 100'  
 FULL SIZE SCALE: 1" = 50'

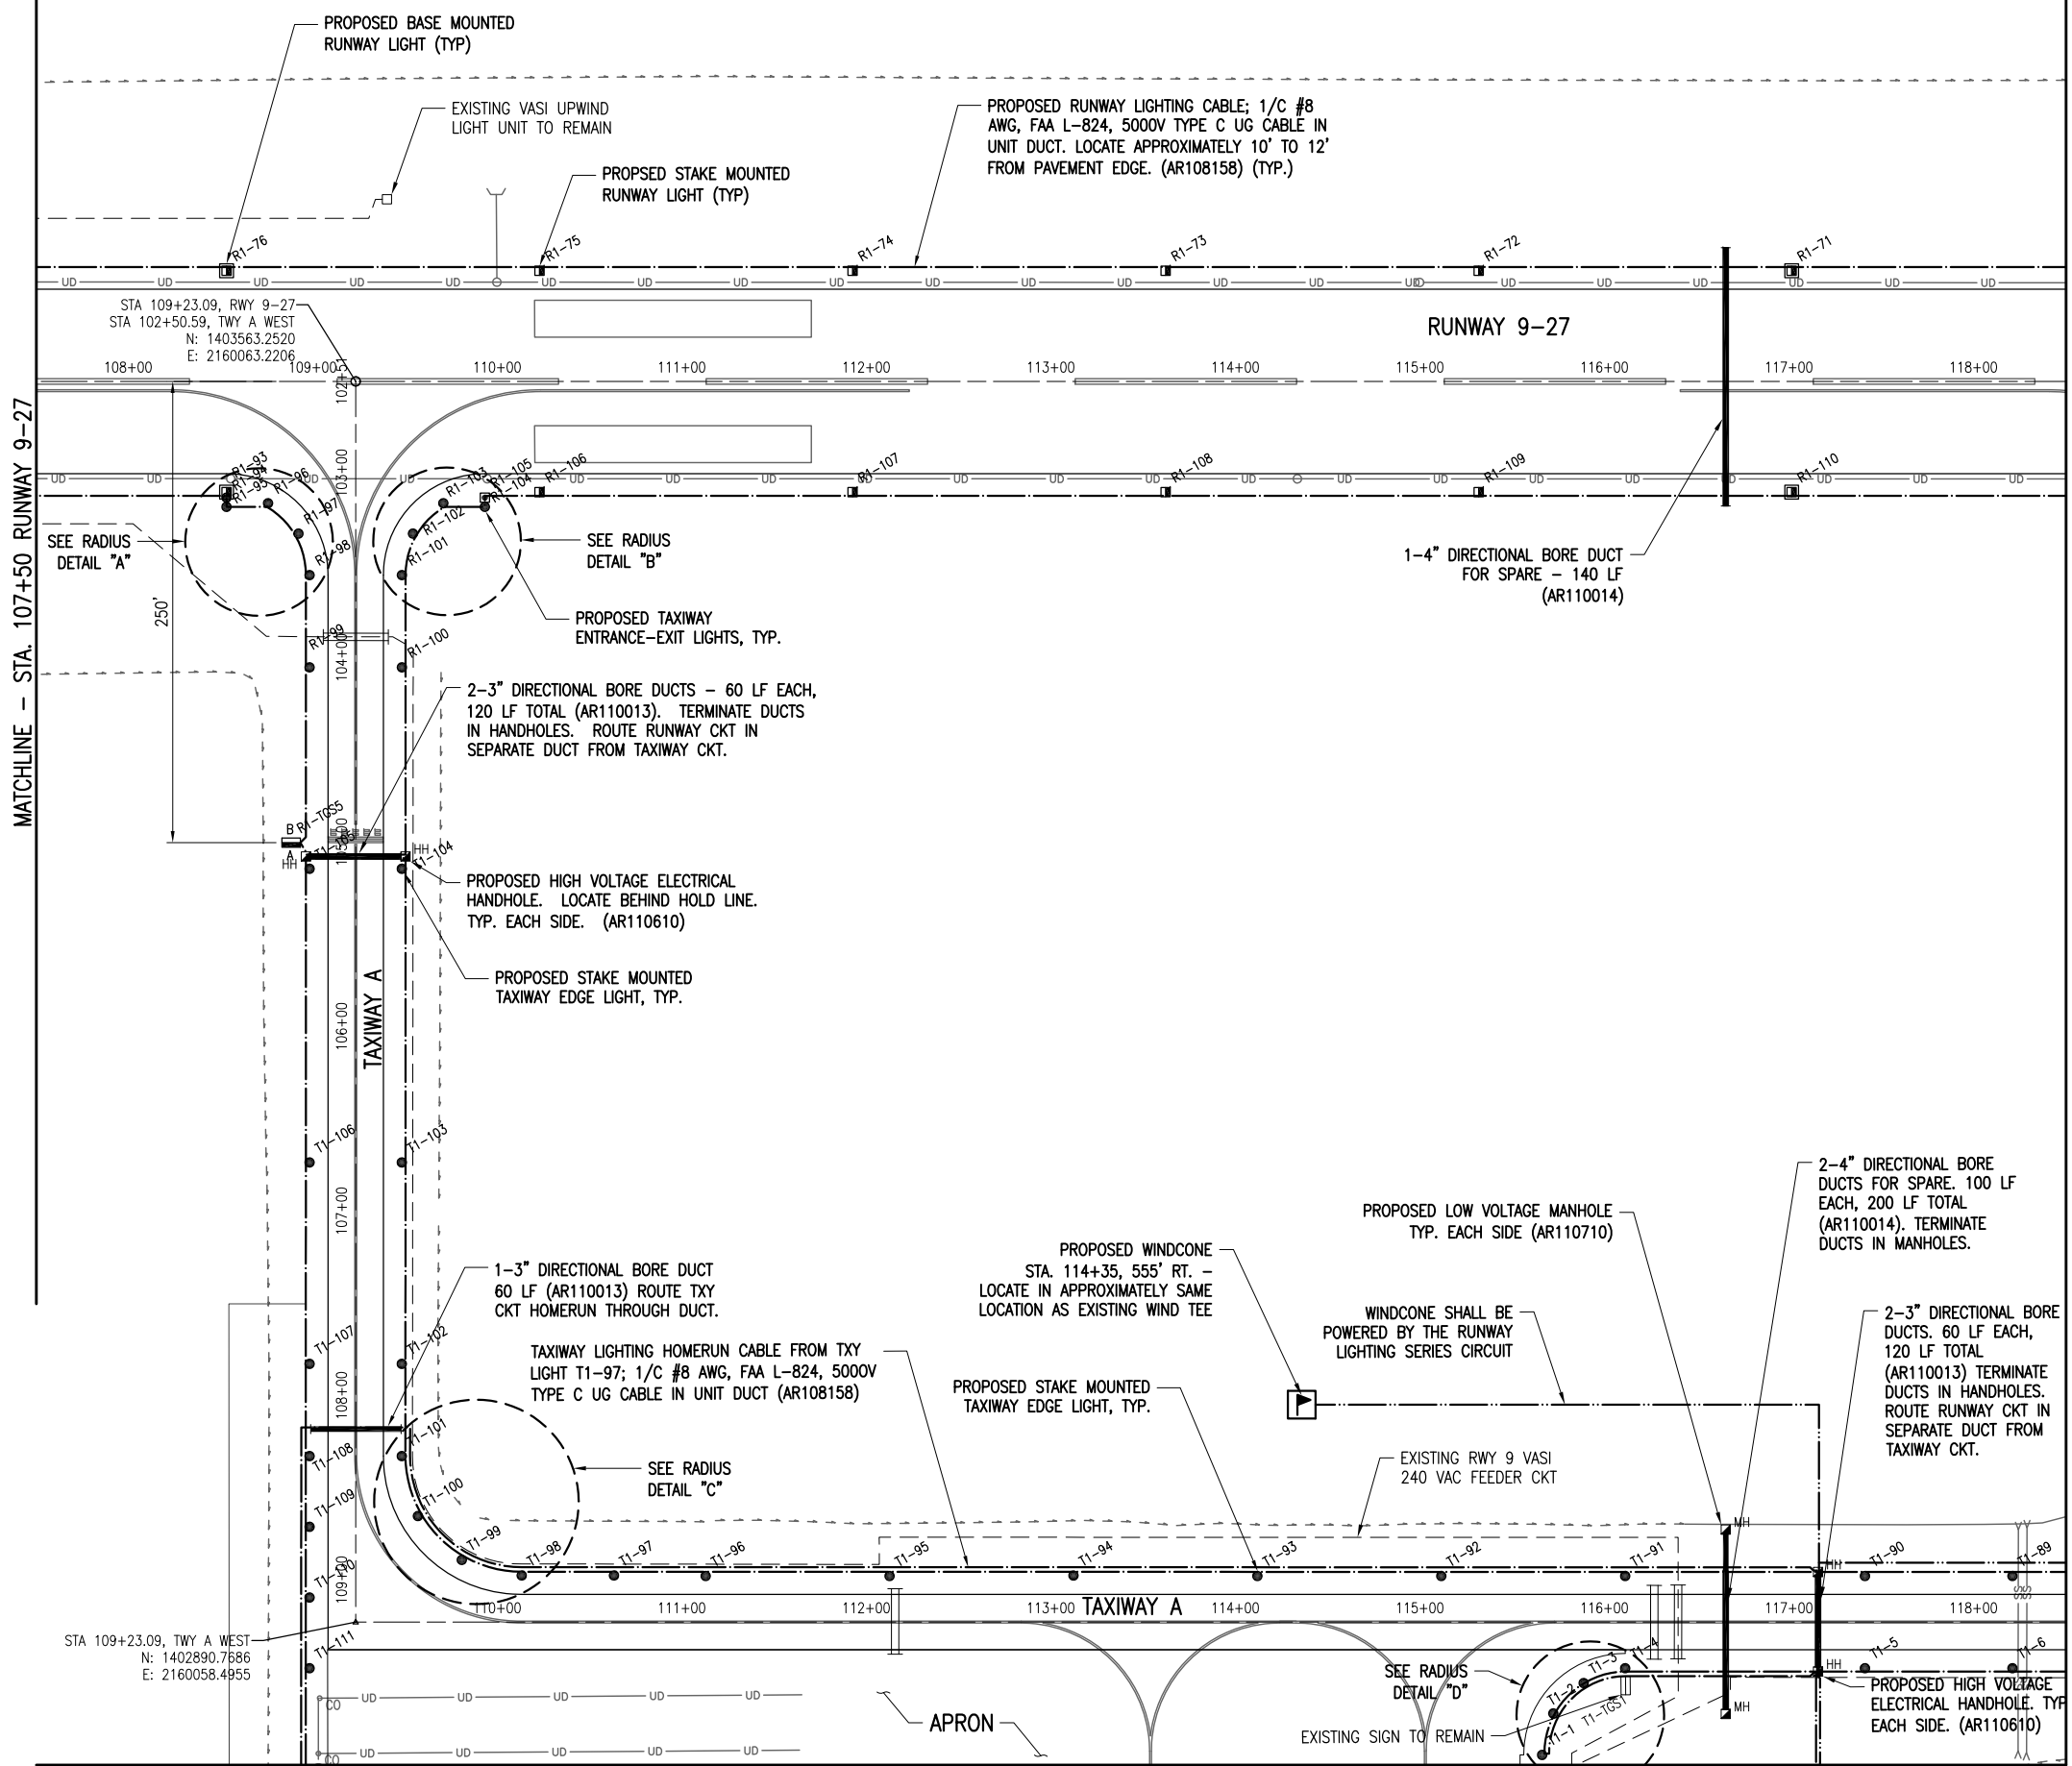

MATCHLINE - STA. 107+50 RUNWAY 9-27

MATCHLINE - STA. 118+50 RUNWAY 9-27

**LEGEND**

- EXISTING PAVEMENT
- EXISTING BUILDING
- EXISTING ELECTRICAL DUCT
- PROPOSED ELECTRICAL DUCT
- EXISTING DRAINAGE DITCH
- EXISTING ELECTRIC
- PROPOSED 1/C #8 AWG, FAA L-824, 5000 VOLT TYPE C UNDERGROUND CABLE UNIT DUCT
- PROPOSED 2-1/C #8 AWG, FAA L-824, 5000V TYPE C UNDERGROUND CABLE IN UNIT DUCT
- PROPOSED 3-1/C #6 XLP-USE 600V UG CABLE IN UNIT DUCT
- EXISTING WATER
- EXISTING TELEPHONE
- EXISTING UNDERDRAIN
- EXISTING STORM SEWER
- EXISTING SANITARY
- EXISTING UNDERGROUND ELECTRIC UTILITY PRIMARY
- PROPOSED REIL
- PROPOSED WIND CONE
- EXISTING TAXI GUIDANCE SIGN
- PROPOSED TAXI GUIDANCE SIGN
- PROPOSED STAKE MOUNTED TAXIWAY LIGHT
- PROPOSED BASE MOUNTED TAXIWAY LIGHT
- PROPOSED STAKE MOUNTED RUNWAY LIGHT
- PROPOSED BASE MOUNTED RUNWAY LIGHT
- PROPOSED STAKE MOUNTED THRESHOLD LIGHT
- PROPOSED BASE MOUNTED THRESHOLD LIGHT
- PROPOSED ELECTRICAL HANDHOLE
- PROPOSED ELECTRICAL MANHOLE
- EXISTING UTILITY TRANSFORMER
- PROPOSED UTILITY TRANSFORMER
- EXISTING AIRPORT ROTATING BEACON

REVISION	DATE	ADDED END INDICATORS
02/19/13		PER IDA REVIEW
06/12/13		REMOVED PAPI'S/VASI'S TO REMAIN

**MACOMB MUNICIPAL AIRPORT  
 MACOMB, ILLINOIS**

IL PROJ.: MGB-4206 BLOCK GRANT PROJ.: 3-17-0064-B21

Hanson Proj. No. 12A0053	01/26/13
Filename: C-142-ELE.dwg	MLP/KNL
Scale: AS SHOWN	TRR
Date: 06/17/13	01/28/13
	REVIEWED
	KNL/CAH
	02/04/13



© Copyright Hanson Professional Services Inc. 2013  
 Hanson Professional Services Inc.  
 1525 South Main Street  
 Springfield, Illinois 62703-2886

REPLACE VAULT, AIRFIELD LIGHTING AND GUIDANCE SIGNS

PROPOSED ELECTRICAL PLAN STA. 107+50 TO STA. 118+50

JUN 17, 2013 12:35 PM HARR01115  
 pw:\sps-svr306\hanson\dom\hanson\Projects\Documents\12A0053\12A0053D\CAD\Airport\Sheet\C-142-ELE