



F.A.P. NO.	SECTION	COUNTY	TOTAL SHEETS	SHEET NO.
335	119R-2	LAKE	439	150
STA. 432+83.12		TO STA. 470+56.84		
FED. ROAD DIST. NO. ILLINOIS FED. AID PROJECT				

60B01

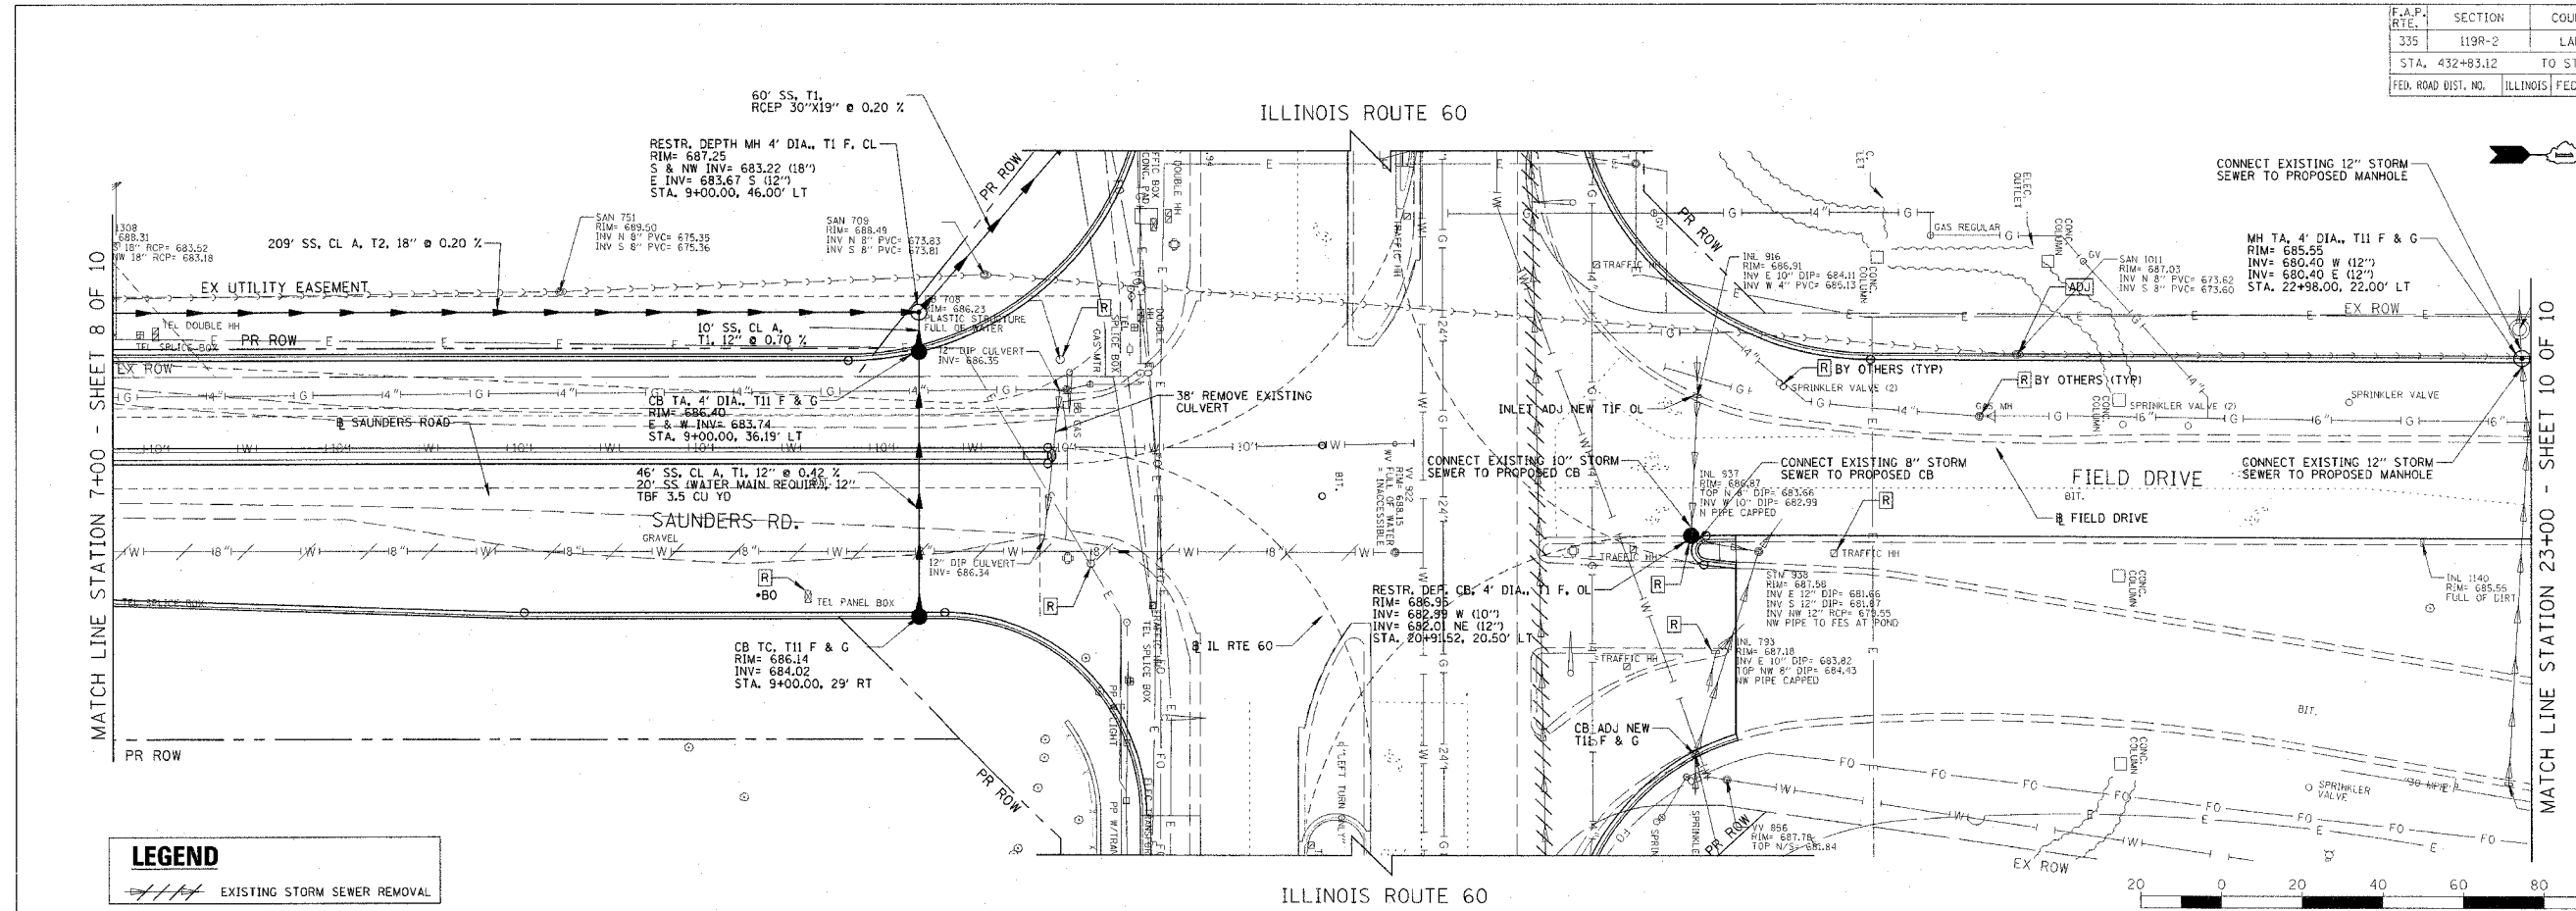

LEGEND

EXISTING STORM SEWER REMOVAL

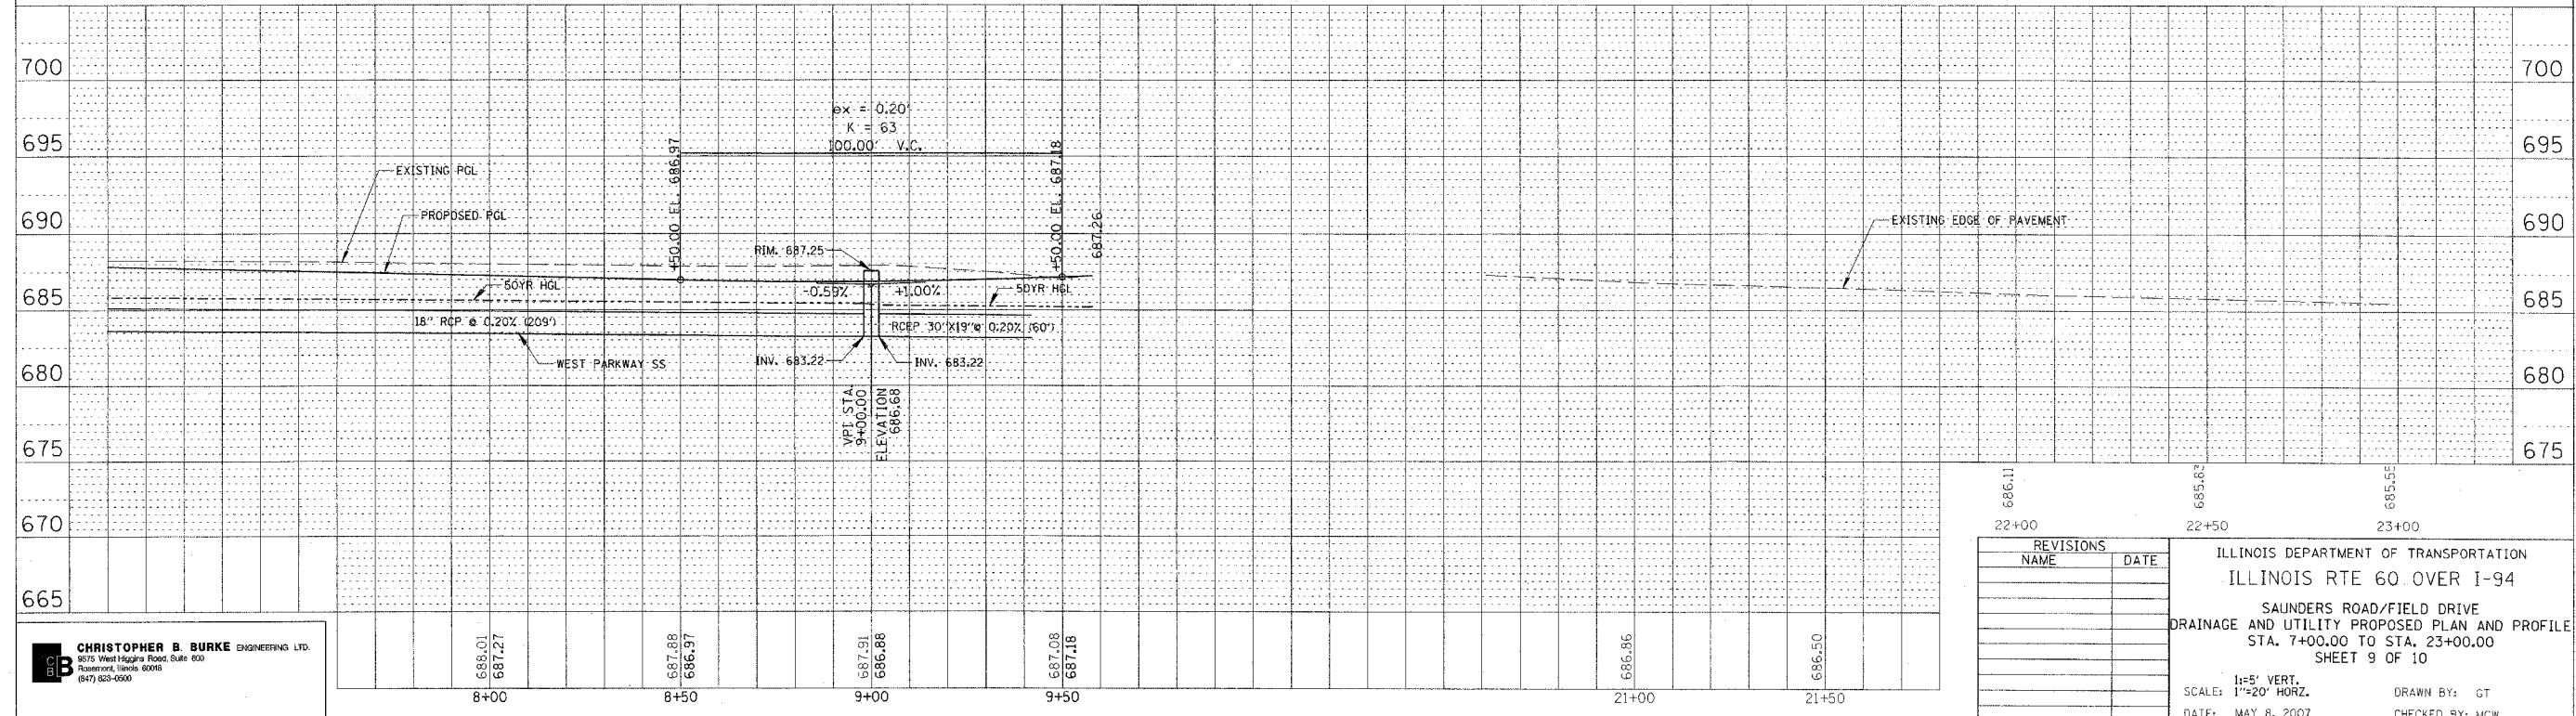

CHRISTOPHER B. BURKE ENGINEERING LTD.
 9575 West Higgins Road, Suite 600
 Rosemont, Illinois 60018
 (630) 953-0500

REVISIONS	
NAME	DATE

ILLINOIS DEPARTMENT OF TRANSPORTATION
 ILLINOIS RTE 60 OVER I-94
 SAUNDERS ROAD/FIELD DRIVE
 DRAINAGE AND UTILITY PROPOSED PLAN AND PROFILE
 STA. 7+00.00 TO STA. 23+00.00
 SHEET 9 OF 10

1"=5' VERT.
 SCALE: 1"=20' HORZ.
 DATE: MAY 8, 2007

DRAWN BY: GT
 CHECKED BY: MCW

PLAN	SURVEYED	DATE

PROFILE	SURVEYED	DATE

5/2/2007 10:08:26 AM