




F.A. RTE.	SECTION	COUNTY	TOTAL SHEETS	SHEET NO.
			439	327
STA.		TO STA.		
FED. ROAD DIST. NO.		ILLINOIS FED. AID PROJECT		

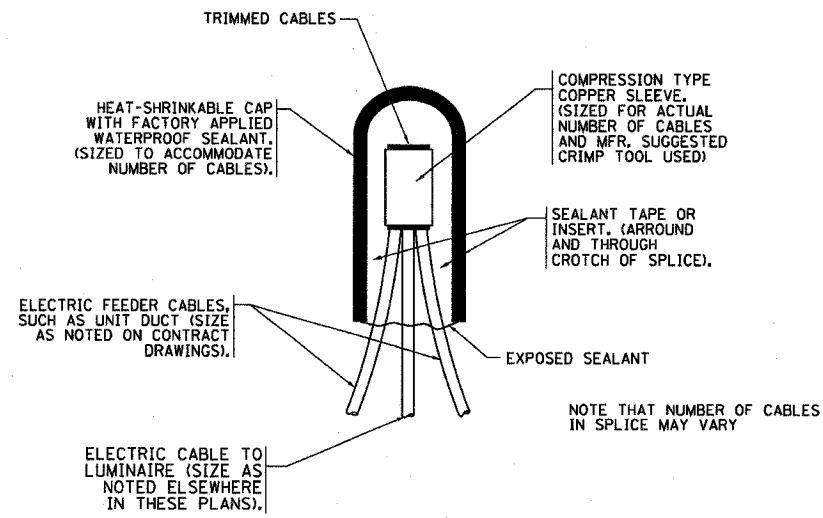

TYPICAL SPLICE DETAIL  
N.T.S.

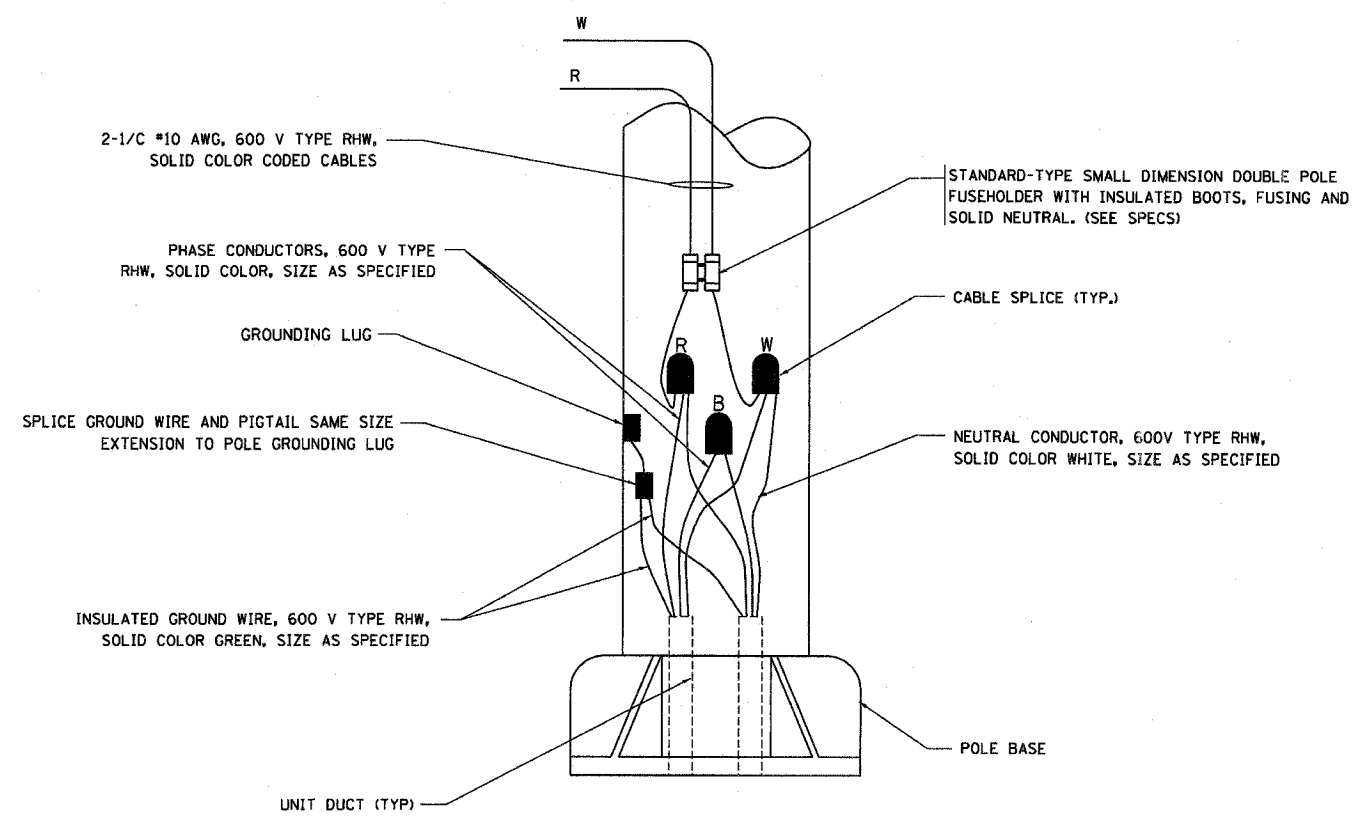

POLE WIRING DETAIL  
N.T.S.

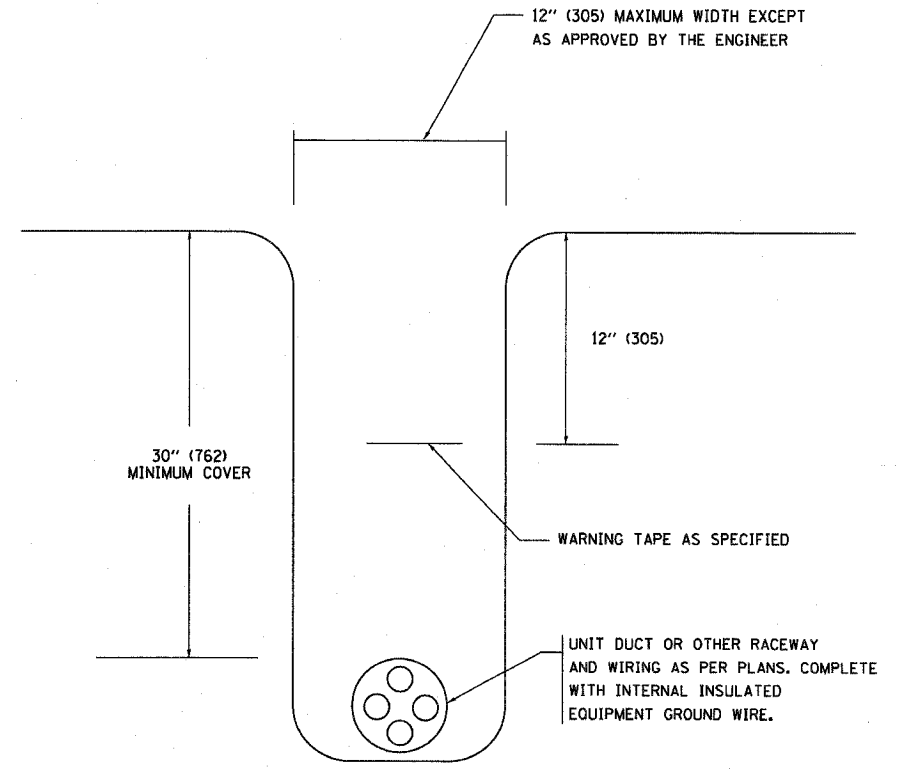

TYPICAL WIRING IN TRENCH DETAIL  
N.T.S.

PLOT DATE = 1/18/2007  
FILE NAME = c:\projects\60801\60801.dwg  
PLOT NAME = 60801.dwg  
USER NAME = gregory

REVISIONS		ILLINOIS DEPARTMENT OF TRANSPORTATION
NAME	DATE	
		MISC. ELECTRICAL DETAILS SHEET A

VERT. SCALE: 1/8" = 1'-0"  
HORIZ. SCALE: 1/8" = 1'-0"  
DATE: 1/18/2007

DRAWN BY: \_\_\_\_\_  
CHECKED BY: \_\_\_\_\_  
BE-702  
REVISION DATE: 01/01/07