



\*REF=drain05  
\*REF=drain06

CONTRACT NO. 62719

F.A.P. RTE.	SECTION	COUNTY	TOTAL SHEETS	SHEET NO.
344	3034N-1	COOK	71	15
STA.	TO STA.			
FED. ROAD DIST. NO.	ILLINOIS	FED. AID PROJECT		

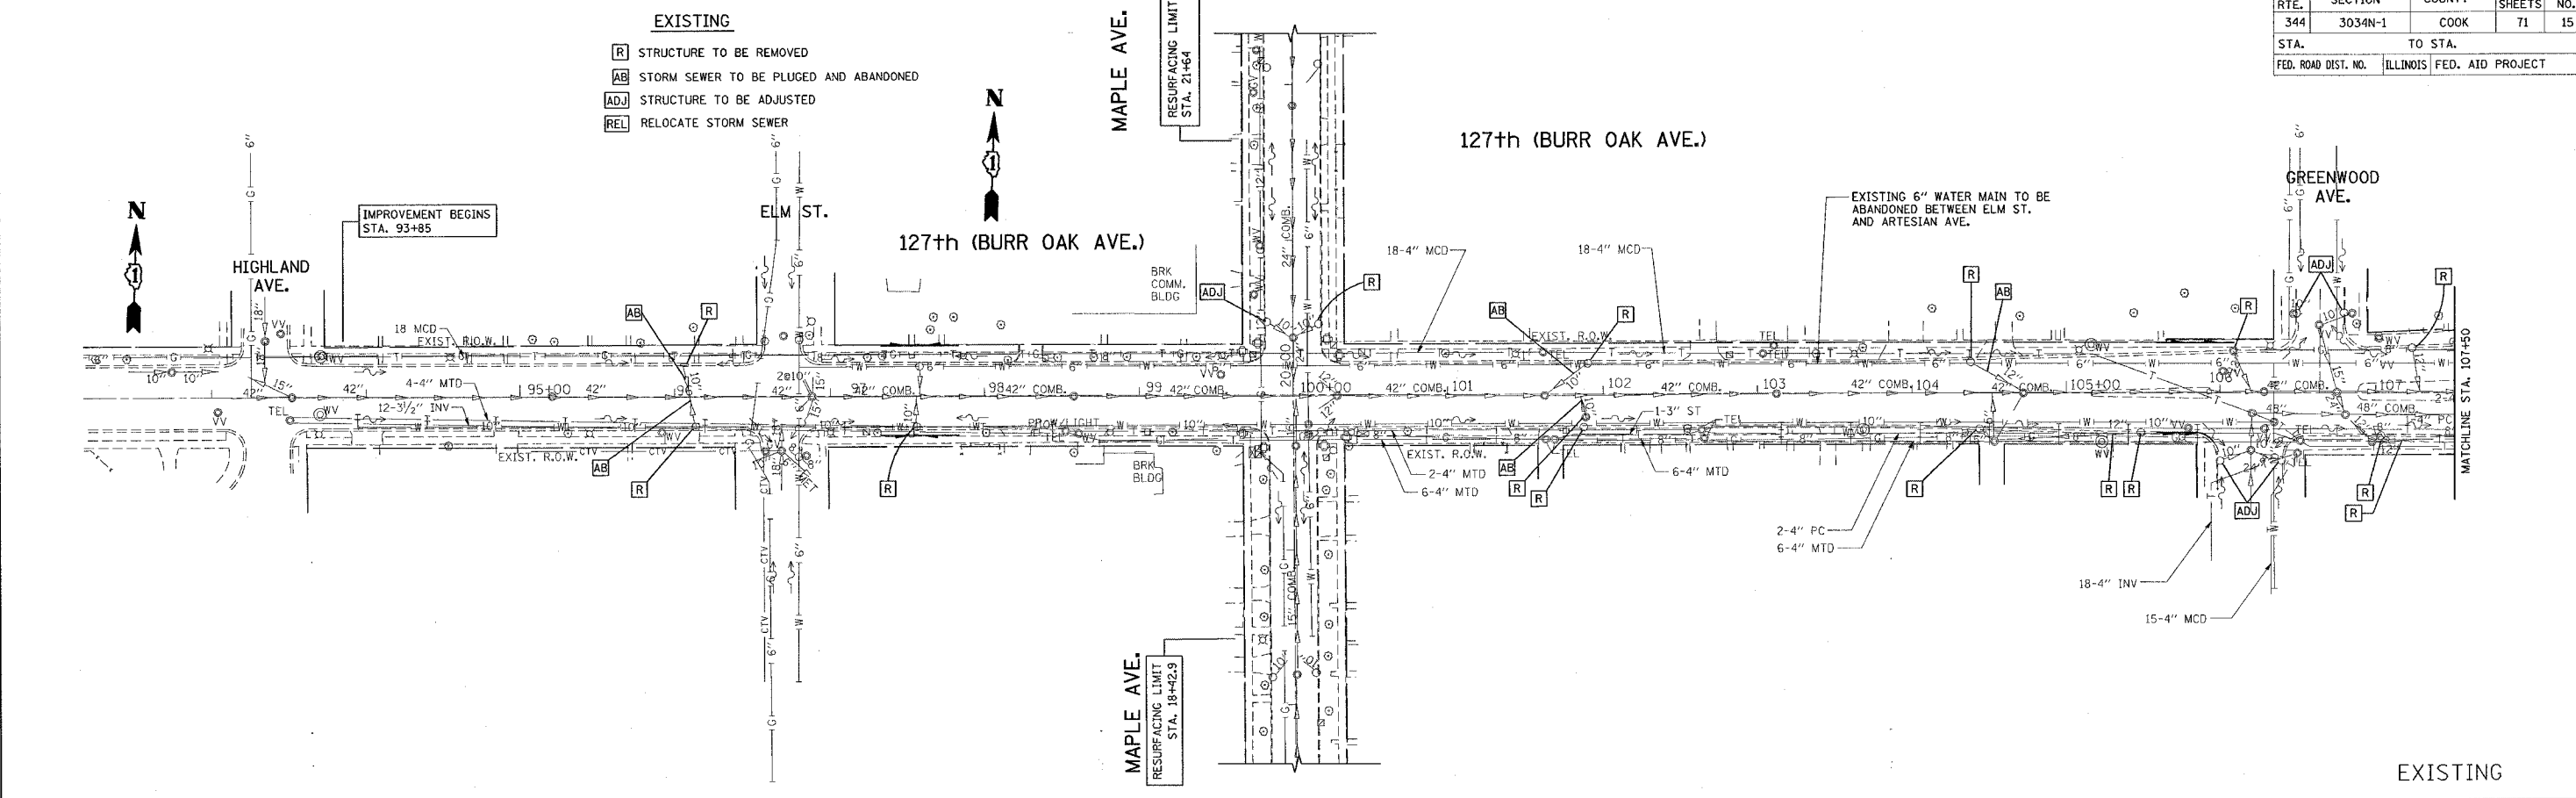

EXISTING

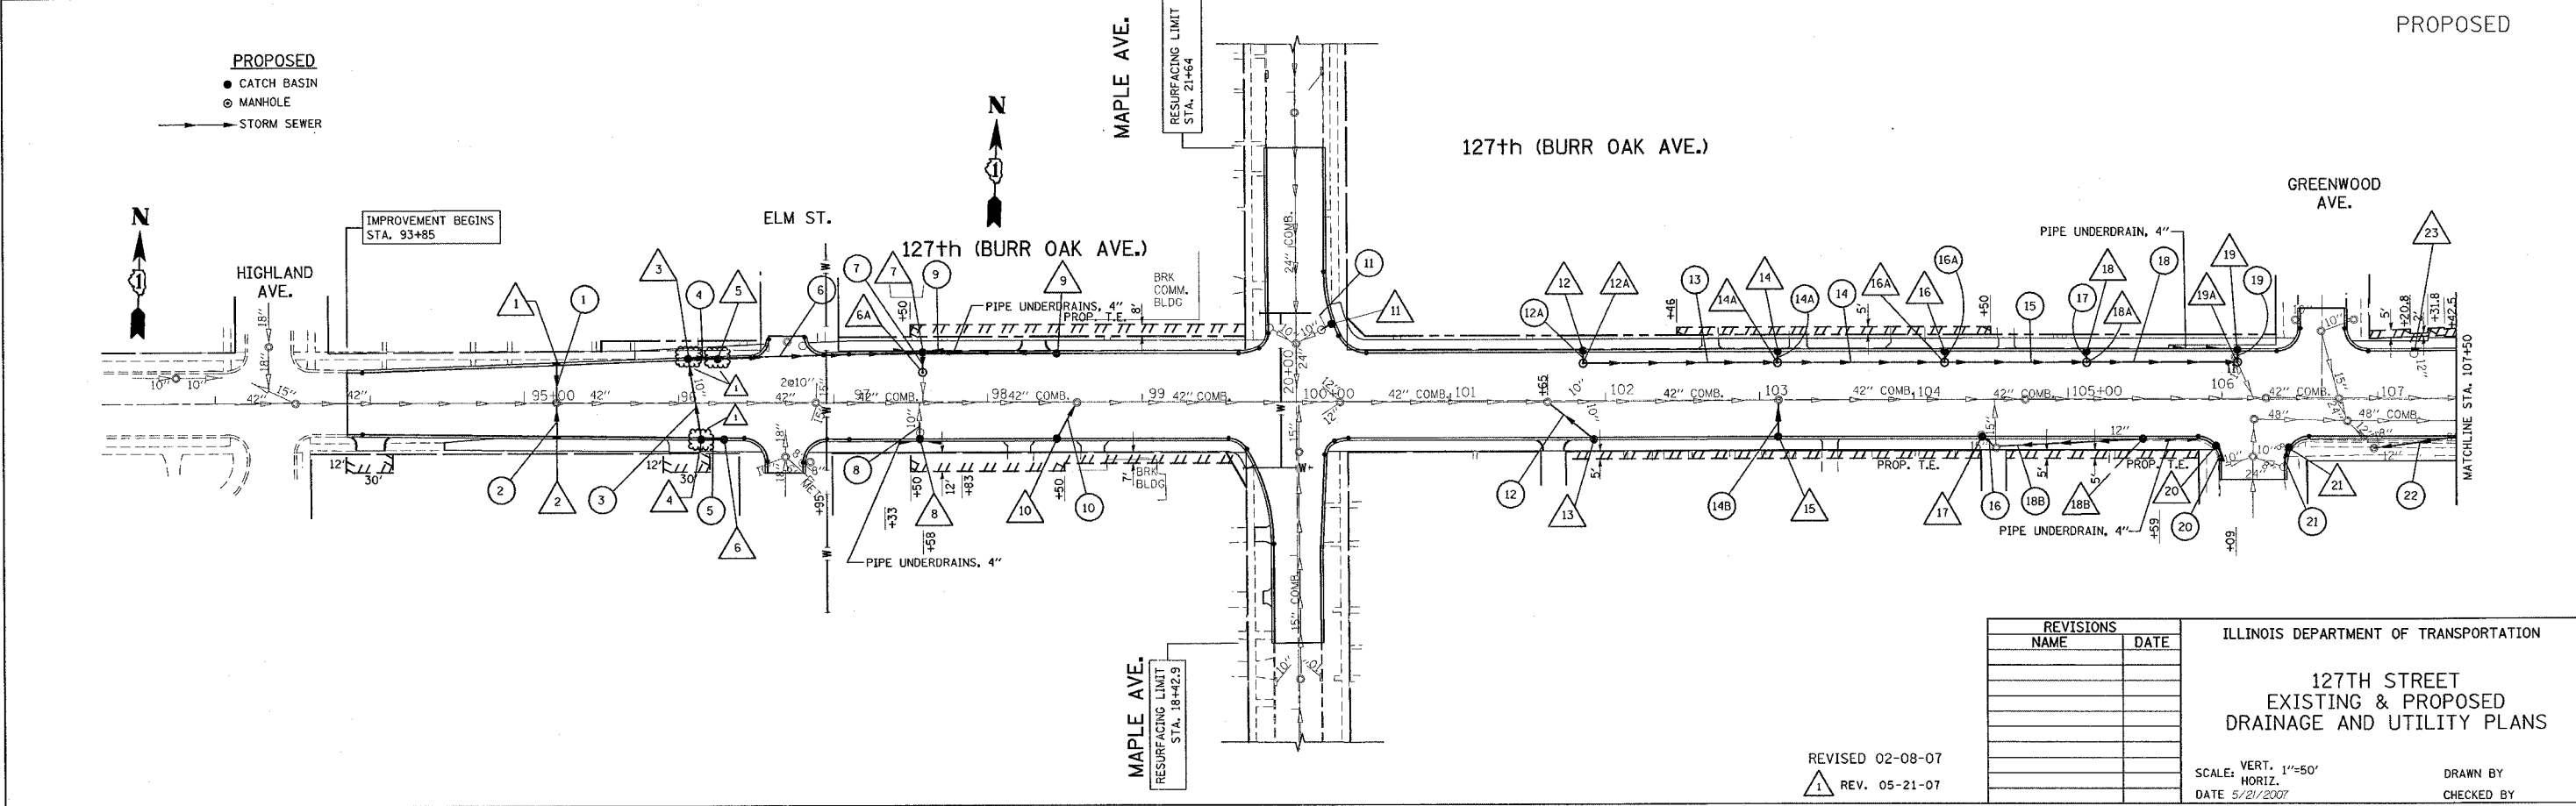

PROPOSED

REVISIONS	
NAME	DATE

ILLINOIS DEPARTMENT OF TRANSPORTATION

127TH STREET  
EXISTING & PROPOSED  
DRAINAGE AND UTILITY PLANS

SCALE: VERT. 1"=50'  
HORIZ. 1"=100'

DATE 5/21/2007

DRAWN BY  
CHECKED BY

REVISED 02-08-07  
1 REV. 05-21-07

PLOT DATE = 5/21/2007  
PLOT SCALE = 50.0000 / 1 IN.  
USER NAME = jayson