

F.A.P. RTE.	SECTION	COUNTY	TOTAL SHEETS	SHEET NO.
592	06-00096-00-LS	MADISON	10	1
STA. — TO STA. —				
FED. ROAD DIST. NO. 8 ILLINOIS FED. AID PROJECT				
COVER SHEET AND LIST OF STANDARDS				
CONTRACT NO. 97315				

### INDEX OF SHEETS

SHEET NO.	ITEM
1	COVER SHEET
2	SUMMARY OF QUANTITIES / GENERAL NOTES
3	SCHEDULE OF QUANTITIES
4	PLAN
5-7	INTERSECTION DETAILS
8	GENERAL DETAILS
9	ELECTRICAL PLAN VIEW
10	ELECTRICAL DETAILS

### STANDARDS

- 000001-04
- 424001-04
- 604001-02
- 606001-03
- 701502-01
- 701801-03
- 702001-06

 
### LIST OF UTILITIES

A.T.&T. (TELEPHONE)  
203 GEOTHE STREET  
COLLINSVILLE, IL 62234  
(618) 346-6400


CHARTER COMMUNICATIONS (CABLE TV)  
210 WEST DIVISION STREET  
MARYVILLE, IL 62062  
(618) 346-8121

CITY OF EDWARDSVILLE (WATER & SEWER)  
118 HILLSBORO AVENUE  
EDWARDSVILLE, IL 62025  
(618) 692-7535


AMEREN IP (GAS & ELECTRIC)  
2600 NORTH CENTER  
MARYVILLE, IL 62062  
(618) 346-1287




GRAPHIC SCALE  
1" = 5'

 

GRAPHIC SCALE  
1" = 10'

 

GRAPHIC SCALE  
1" = 20'

 

GRAPHIC SCALE  
1" = 60'

FULL SIZE PLANS HAVE BEEN PREPARED USING STANDARD ENGINEERING SCALES. REDUCED SIZED PLANS WILL NOT CONFORM TO STANDARD SCALES. IN MAKING MEASUREMENTS ON REDUCED PLANS, THE ABOVE SCALES MAY BE USED.

JOINT UTILITY LOCATING INFORMATION FOR EXCAVATIONS PHONE: 800-892-0123

ROADWAY DESIGNATION: PRINCIPAL ARTERIAL  
CURRENT TRAFFIC (2005) = 13,000 ADT

# STATE OF ILLINOIS DEPARTMENT OF TRANSPORTATION

## PLANS FOR PROPOSED

F.A.P. ROUTE 592 - ST. LOUIS STREET STREETScape  
SECTION 06-00096-00-LS  
PROJECT NO. TE-00D8 (111)  
JOB NO. C-98-302-07  
CITY OF EDWARDSVILLE  
MADISON COUNTY, ILLINOIS


SCALE IN FEET

PLAN	1" = 60'
INTERSECTION DETAILS	1" = 5'
ELECTRICAL PLAN	1" = 40'



ST. LOUIS STREET  
SECTION BEGINS @ STA. 10+40


ST. LOUIS STREET  
SECTION ENDS @ STA. 23+05

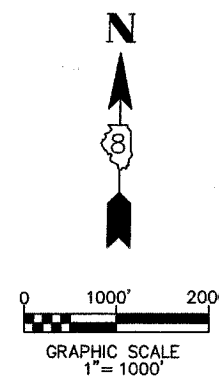

### LOCATION MAP


SCALE: 1" = 1,000'

NET LENGTH OF PROJECT  
ST. LOUIS STREET = 1,265 FEET (0.240 MILES)

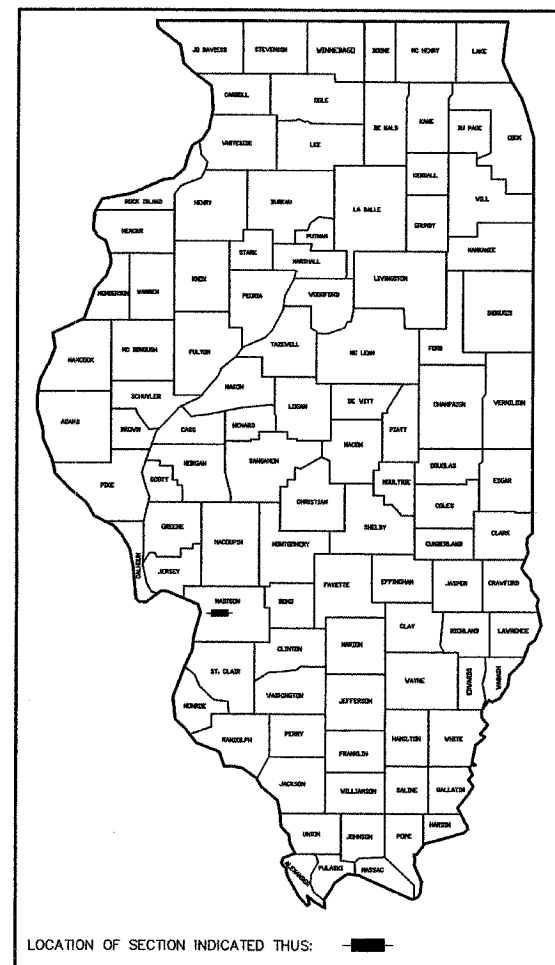

LOCATION OF SECTION INDICATED THUS: [Black Rectangle]

ILLINOIS DEPARTMENT OF TRANSPORTATION	
APPROVED	<i>Gary Niebur</i> June 1, 2007 GARY NIEBUR, MAYOR
PASSED	<i>June 5</i> 2007 DISTRICT 8 ENGINEER OF LOCAL ROADS & STREETS
RELEASED FOR BID BASED ON LIMITED REVIEW	<i>June 5</i> 2007 <i>Wm. C. Lammie, Jr.</i> DEPUTY DIRECTOR OF HIGHWAYS, REGION 5 ENGINEER

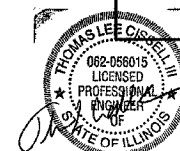

EXPIRES 11/30/07 *Thomas L. Cissell, III* DATE: 6/1/07  
THOMAS L. CISSSELL, III  
P.E. NO. 62-56015

