



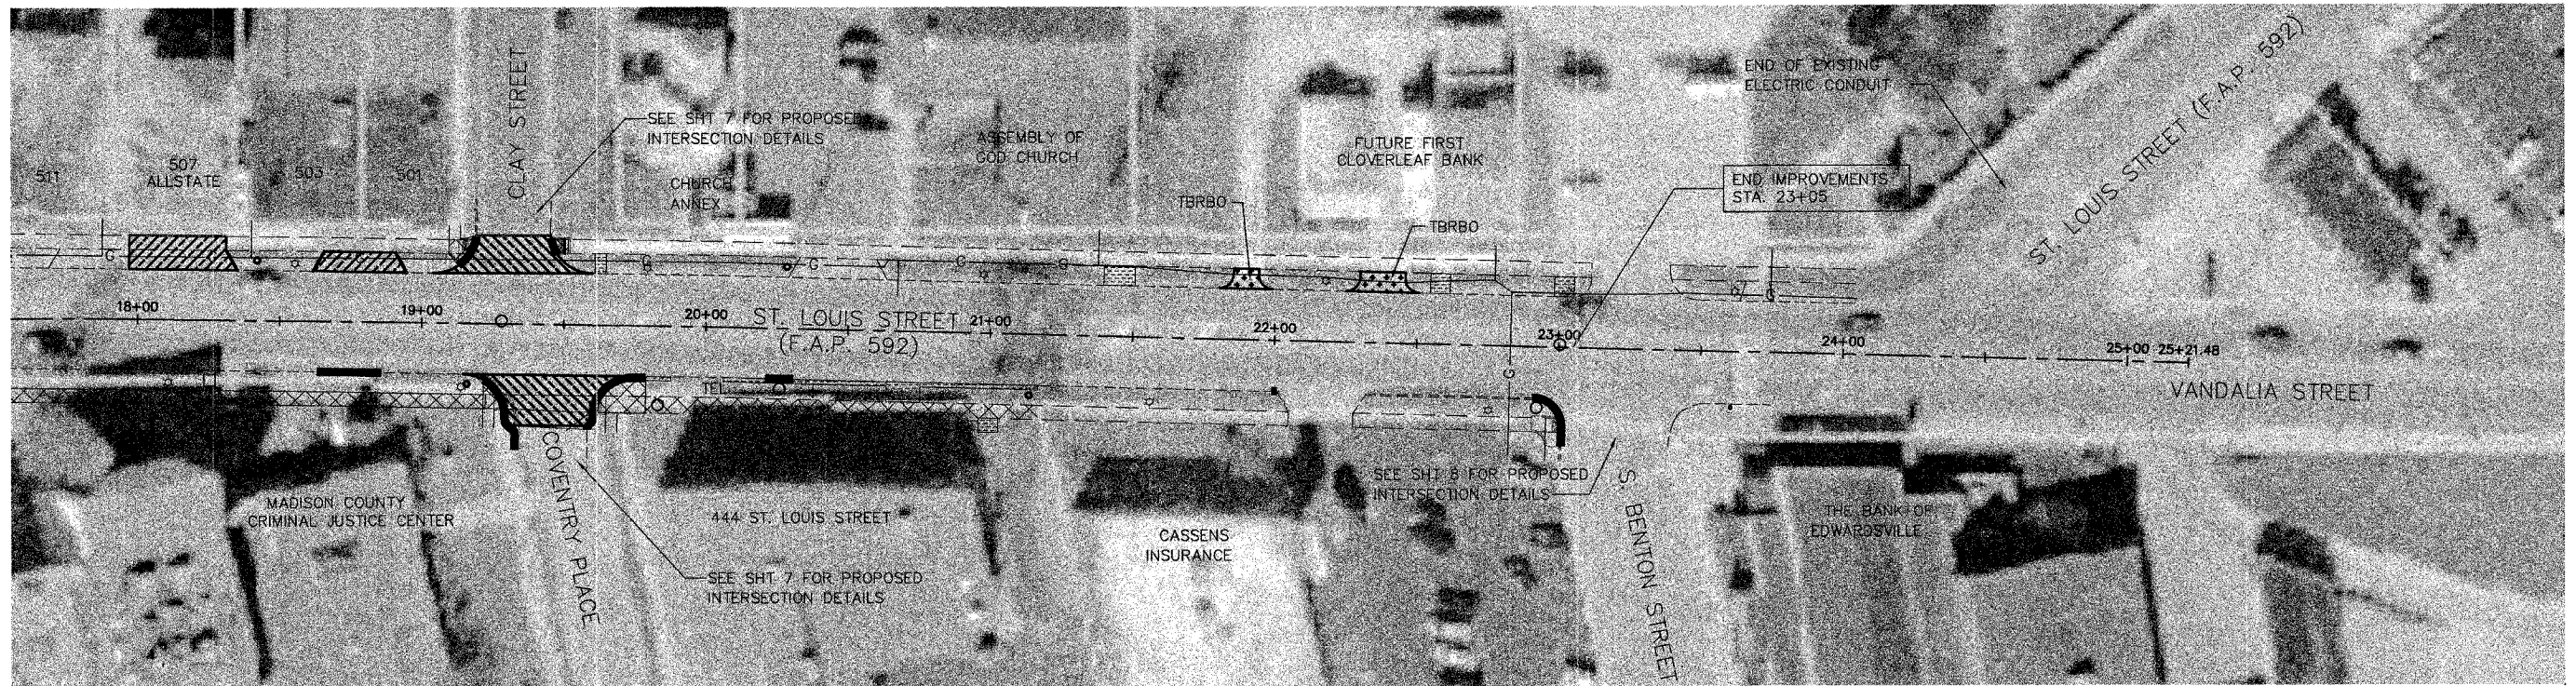

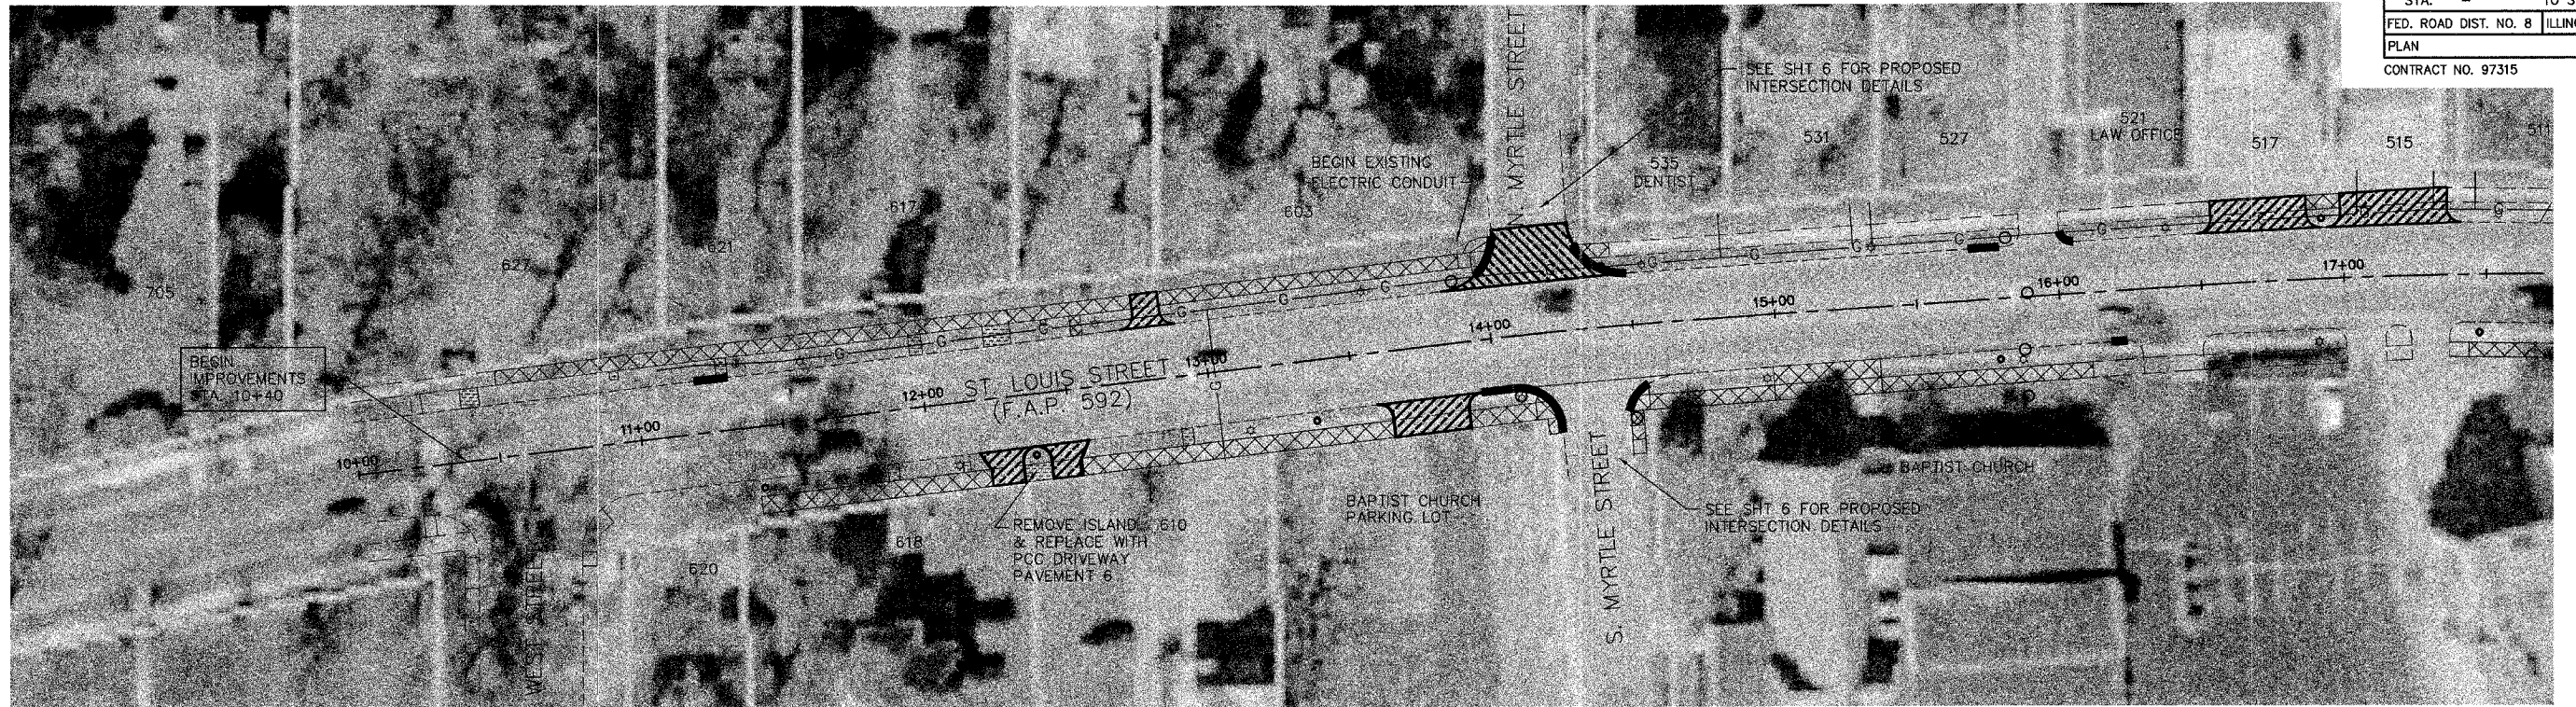

 


F.A.P. RTE.	SECTION	COUNTY	TOTAL SHEETS	SHEET NO.
592	06-00096-00-LS	MADISON	10	4
STA. —	TO STA. —			
FED. ROAD DIST. NO. 8		ILLINOIS	FED. AID PROJECT	
PLAN				
CONTRACT NO. 97315				



LEGEND

-  SIDEWALK REMOVAL & REPLACEMENT
-  DRIVEWAY PAVEMENT REMOVAL & REPLACEMENT
-  SIDEWALK REMOVAL
-  HOT-MIX ASPHALT SURFACE REMOVAL & REPLACEMENT W/ INCIDENTAL HOT-MIX ASPHALT SURFACING
-  DRIVEWAY PAVEMENT REMOVAL
-  CONCRETE CURB, TYPE B REMOVAL & REPLACEMENT
-  * PROPOSED LIGHT POST (SEE ELECTRICAL PLAN SHTS 9-10)

