



F.A. RTE.	SECTION	COUNTY	TOTAL SHEETS	SHEET NO.
9127	08-00081-02-LS	MADISON	45	26
STA.		TO STA.		
FED. ROAD DIST. NO.		ILLINOIS	FED. AID PROJECT	
ELECTRICAL PLAN				

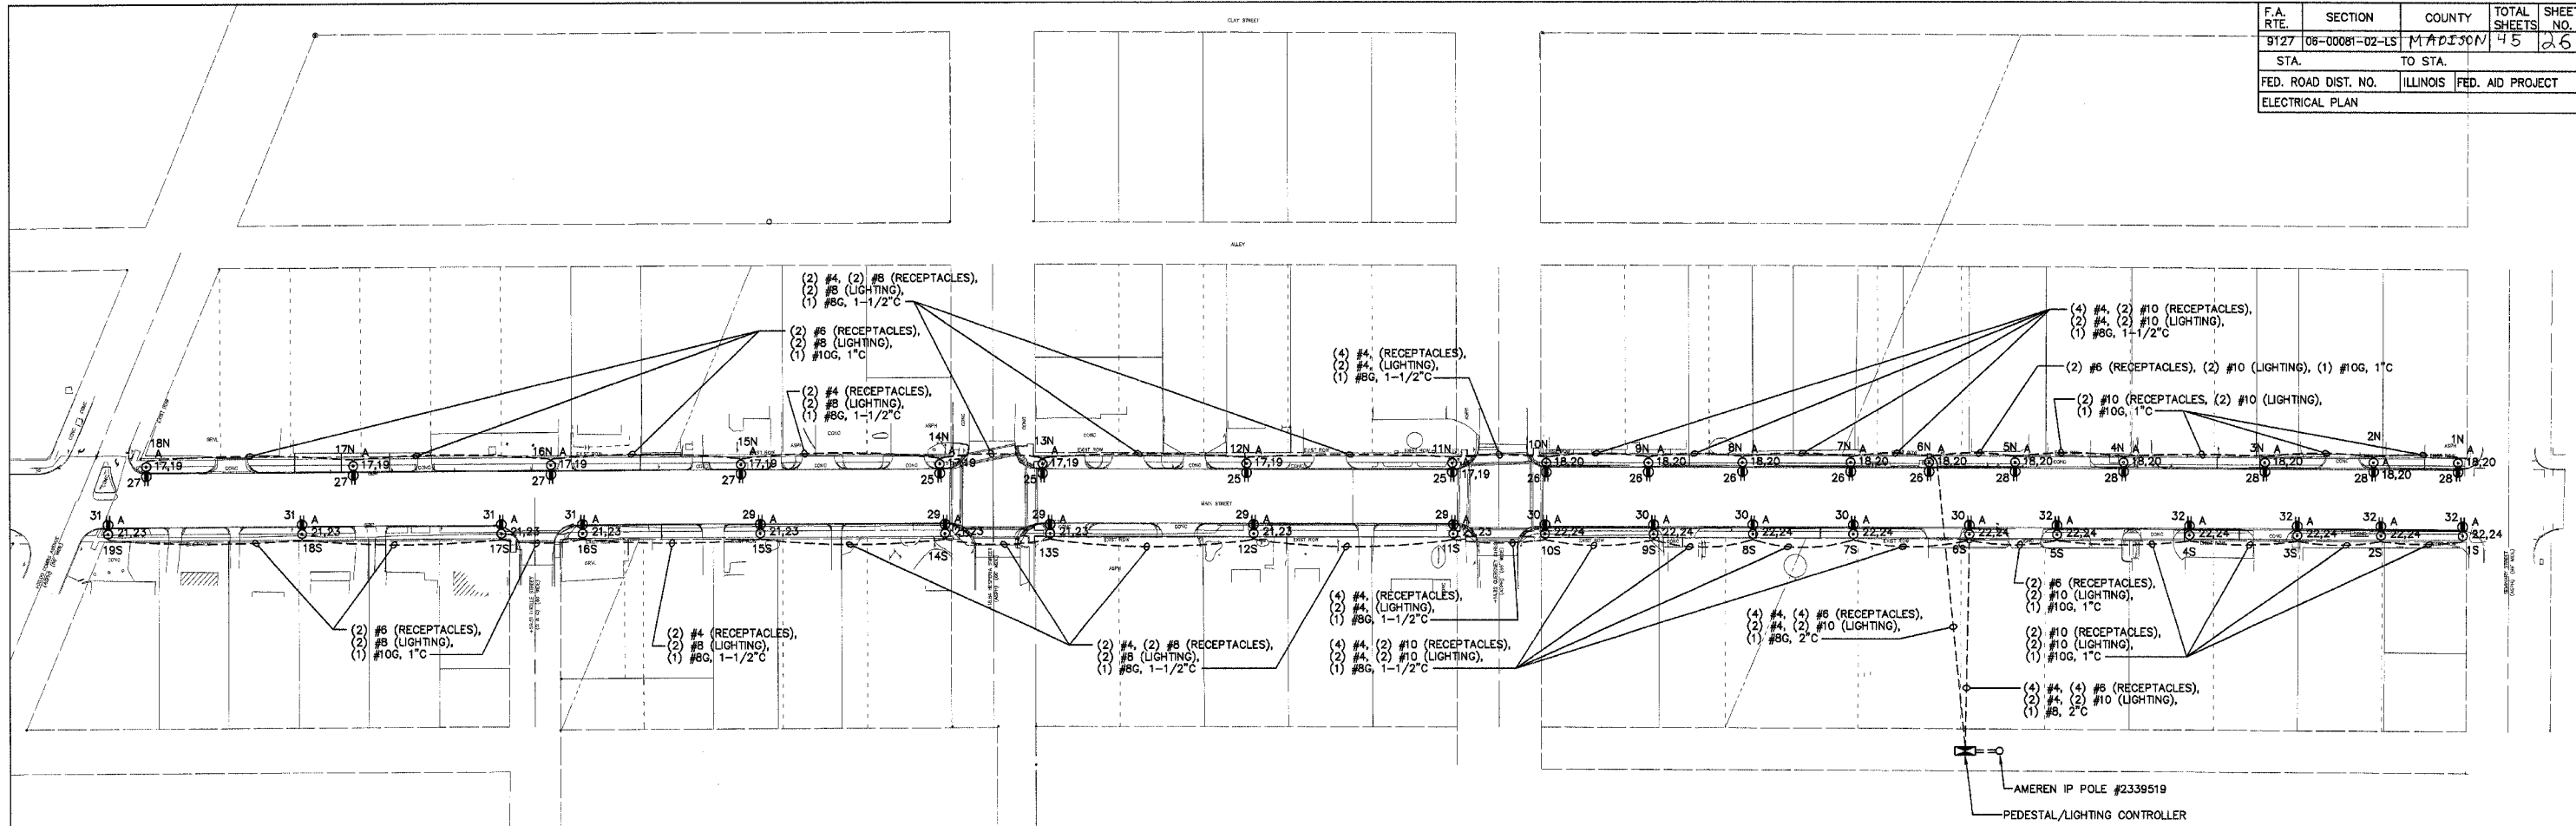

ELECTRICAL SITE PLAN
1" = 60'-0"

SYMBOL LEGEND

 - SITE LIGHT FIXTURE (SEE DETAIL #5 ON SHEET E-3)
- ⊕ GFI DUPLEX RECEPTACLE IN POLE WITH WEATHERPROOF "IN-USE" COVER.
- HANDHOLE SPECIAL, 12"x12" (SEE DETAIL #4 ON SHEET E-3)
- ⊞ ELECTRIC PEDESTAL/LIGHTING CONTROLLER



	<p>BRiC PARTNERSHIP, LLC CONSULTING ENGINEERS</p>	<p>100 EAST WASHINGTON, SUITE 220 BELLEVILLE, IL 62220 TEL 618.277.5200 FAX 618.277.5227</p>	<p>OATES ASSOCIATES</p>	<p>COLLINSVILLE STREETSCAPE PLAN VIEW</p>	
				<p>DRAWN BY: GYK CHKD BY: LLH DATE: 06/01/07</p>	<p>JOB NO.: C-98-304-07 E-1 SHEET 1 OF 3 SHEETS</p>