



TYPICAL SPLICE DETAIL

N.T.S.

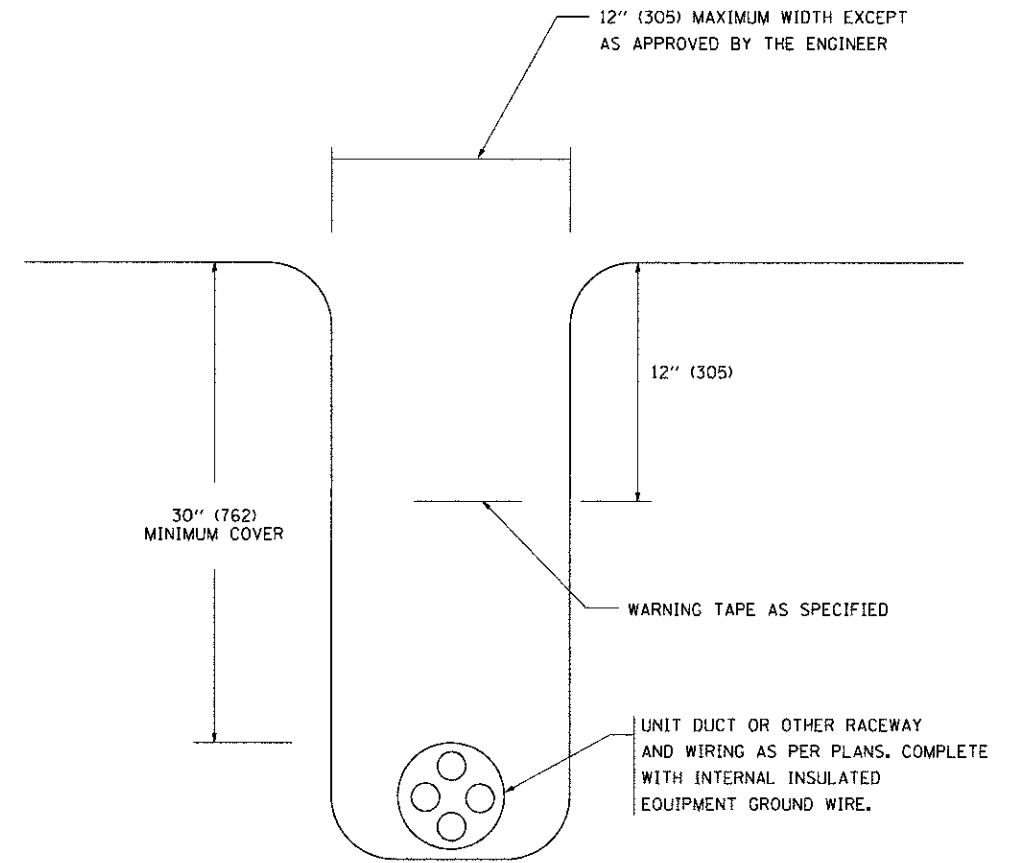

TYPICAL WIRING IN TRENCH DETAIL

N.T.S.

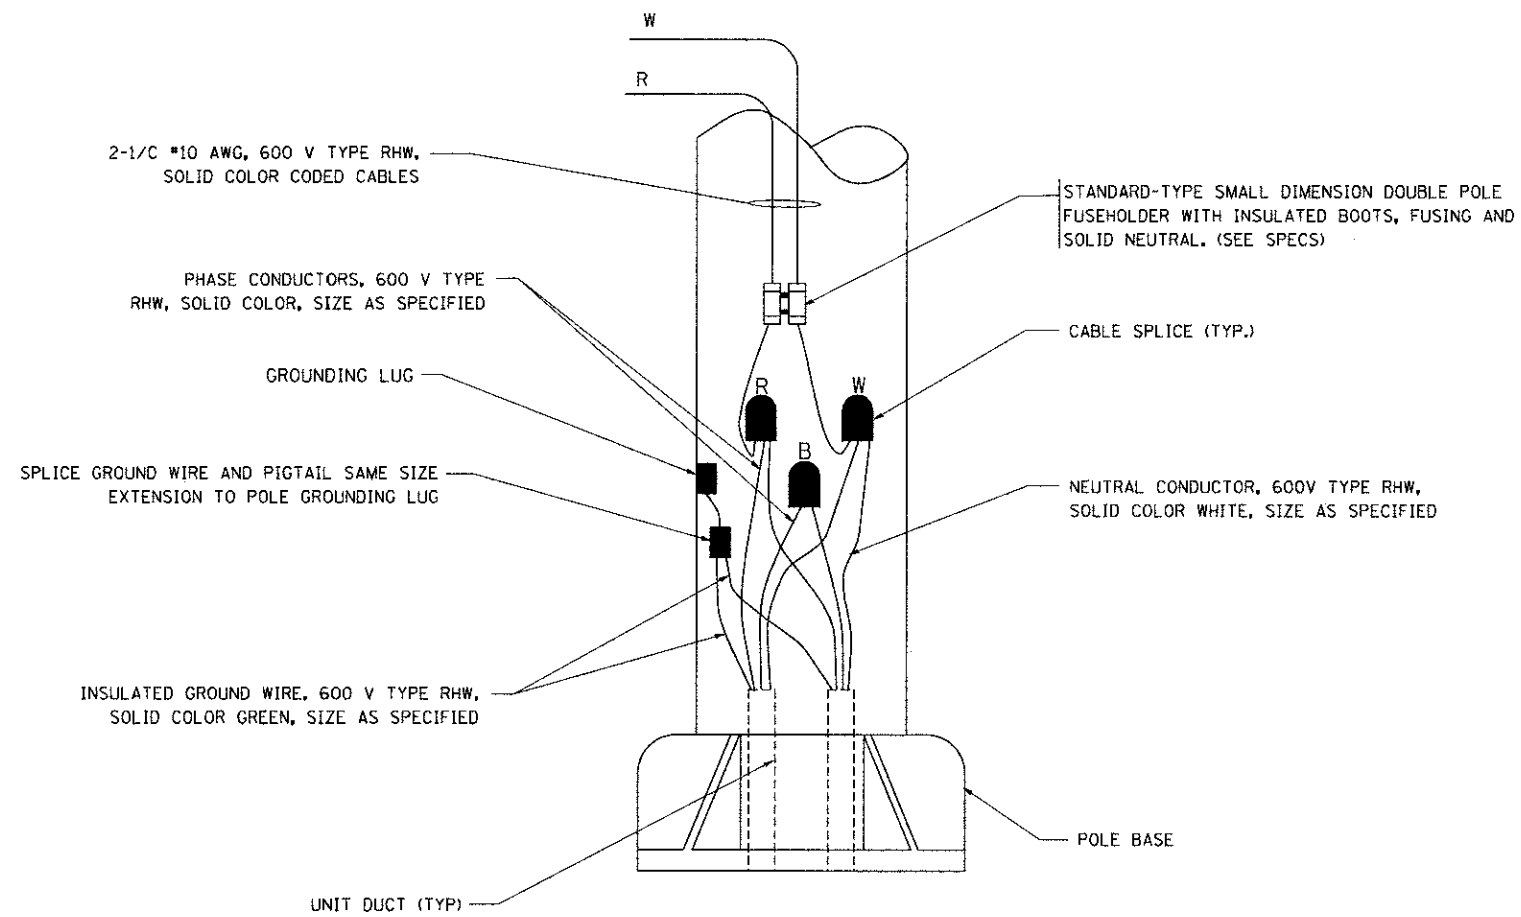

POLE WIRING DETAIL

N.T.S.

FILE NAME =  
w:\diststd\22x34\be782.dgn

USER NAME = gaglienobt

DESIGNED -

REVISED - 08-08-03

DRAWN -

REVISED -

PLOT SCALE = 50,000' / IN.

CHECKED -

REVISED -

PLOT DATE = 1/4/2008

DATE -

REVISED -

STATE OF ILLINOIS  
DEPARTMENT OF TRANSPORTATION

MISC. ELECTRICAL DETAILS  
SHEET A

SCALE: NONE SHEET NO. 1 OF 1 SHEETS STA. TO STA.

F.A.U. RTE.	SECTION	COUNTY	TOTAL SHEETS	SHEET NO.
2783	11-00253-00-LS	COOK	24	23
BE-702		CONTRACT NO. 63722		
FED. ROAD DIST. NO. 1 ILLINOIS FED. AID PROJECT				