


F.A.I. RTE.	SECTION	COUNTY	TOTAL SHEETS	SHEET NO.
90/94	*	COOK	565	5
STA.		TO STA.		
62301		* (2021-922 PT2 ETC 2324.6-1P) R-10		

P:\P\04060\CH\NB-ctrls 18 & 19\SH\CONT 18\schedule\cs180022a.sh

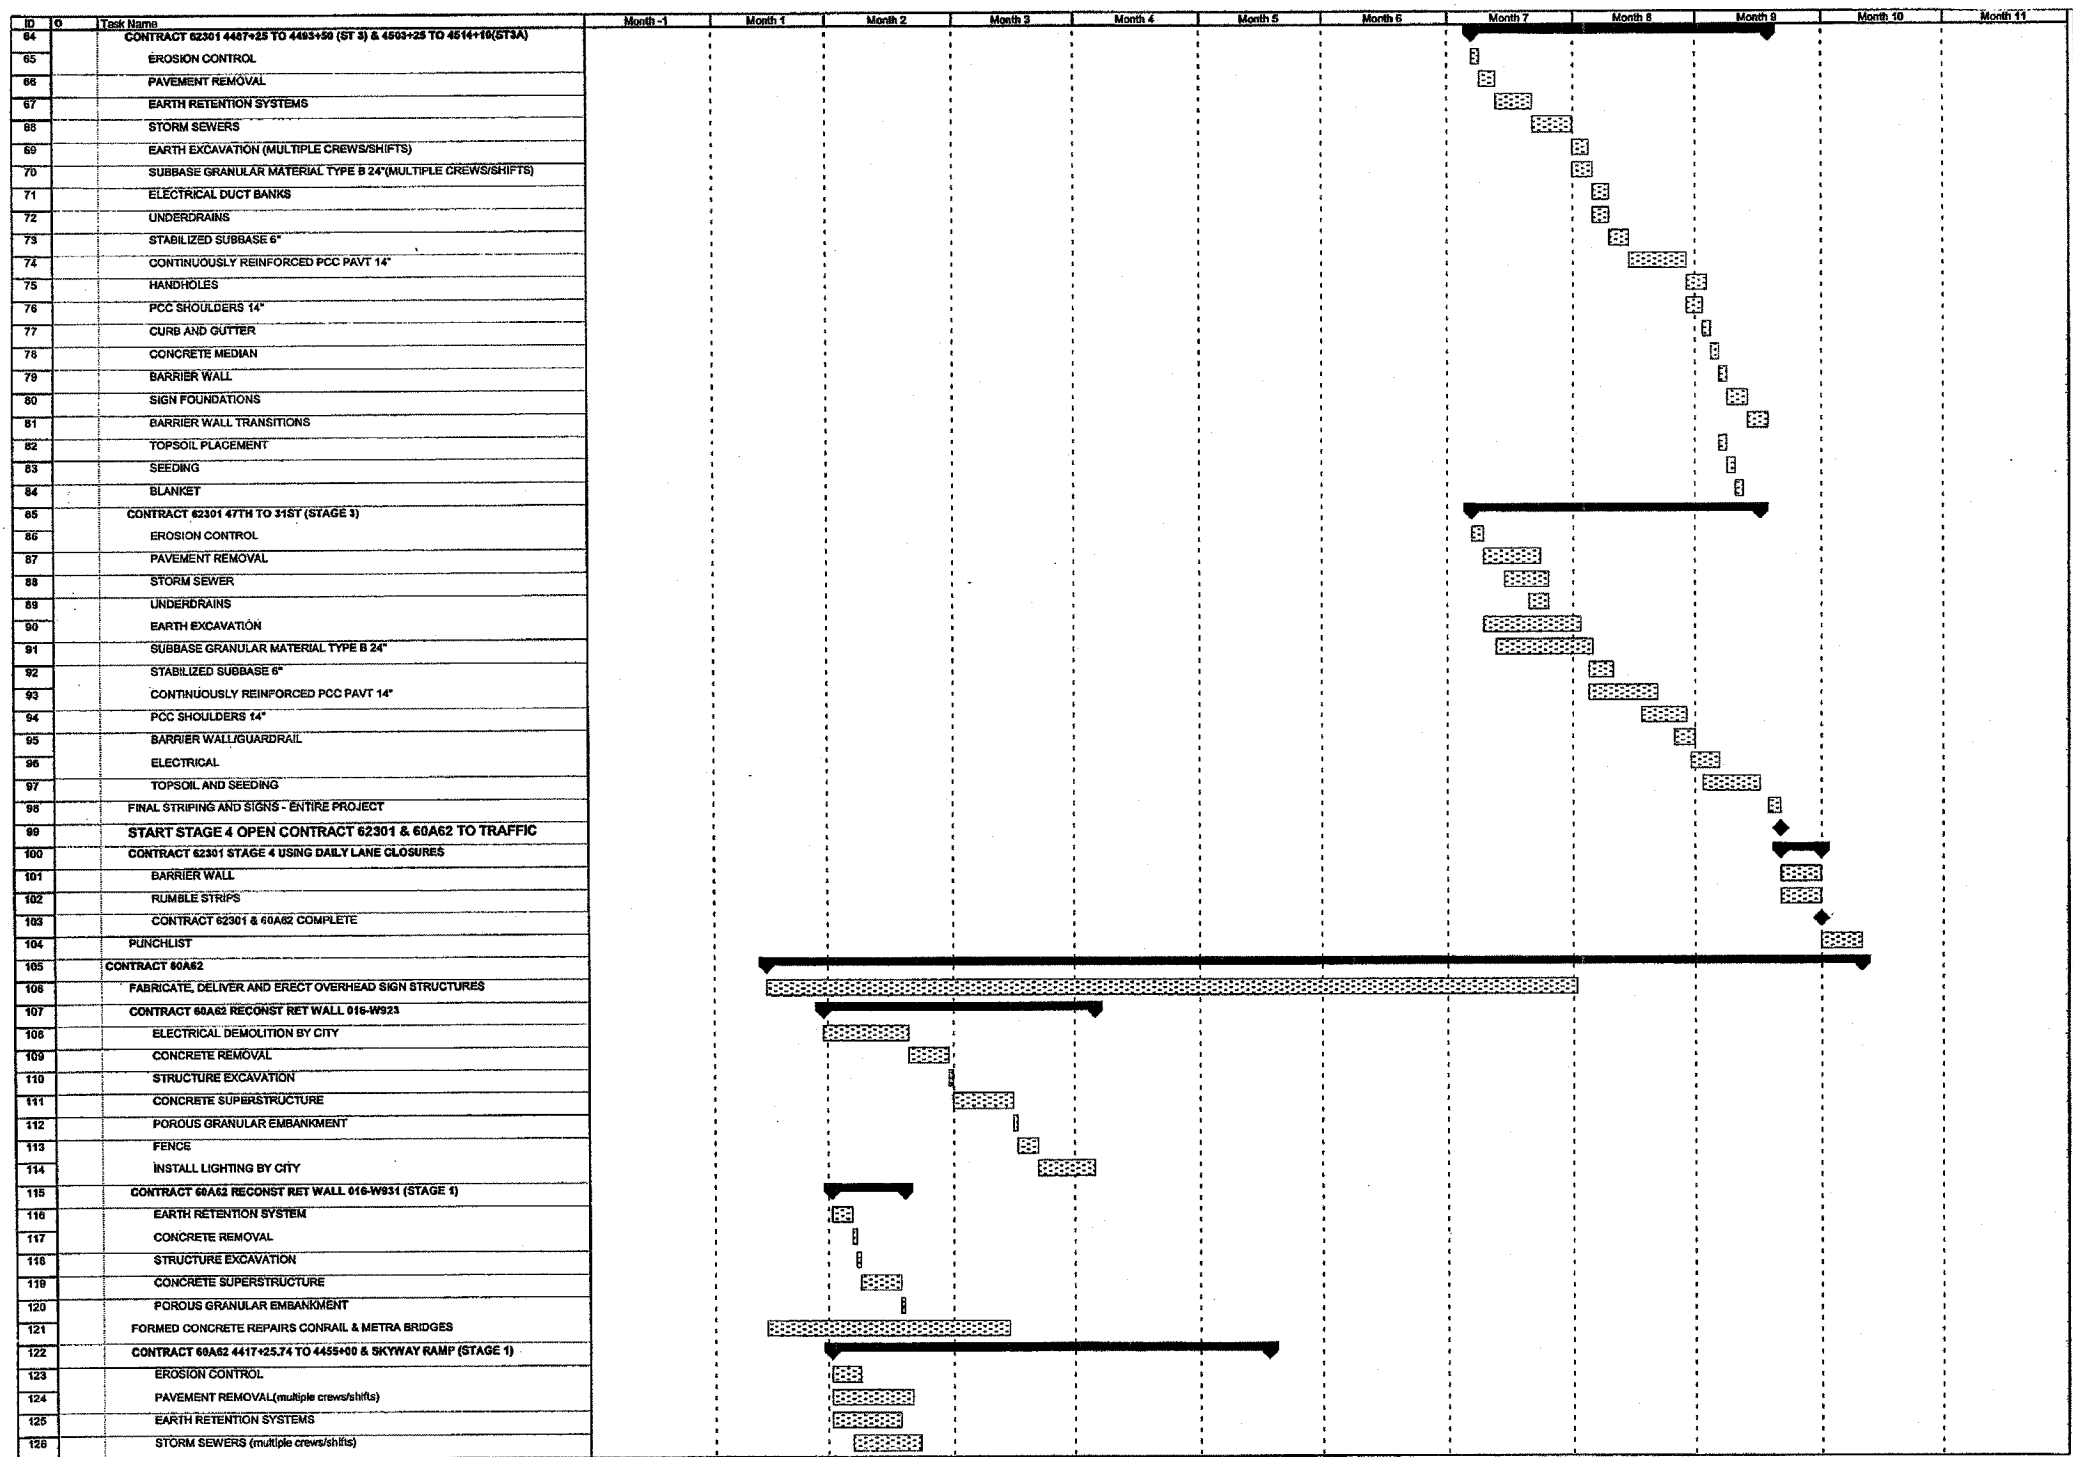

Project: DAN RYAN 18 & 19A Date: Fri 6/2/06

Task Split: [Pattern] Progress Milestone

Summary: [Pattern] Rolled Up Task

Roll Up Split: [Pattern] Rolled Up Milestone

Roll Up Progress: [Pattern] External Tasks

Project Summary: [Pattern] External Milestone

Deadline: [Symbol]

Page 2



REVISIONS	
NAME	DATE

CS-2

ILLINOIS DEPARTMENT OF TRANSPORTATION
 F.A.I. 90/94 (DAN RYAN EXPRESSWAY)
 GARFIELD BLVD TO 31ST STREET (NB LOCAL LANES)

SUGGESTED SEQUENCE OF OPERATION

SCALE: NONE
 DATE: June 9, 2006

DRAWN BY: NJH
 CHECKED BY: RMG

6/7/2006 10:20:29 AM