



F.A.U. RTE.	SECTION	COUNTY	TOTAL SHEETS	SHEET NO.
1587	3098-BS-4	COOK	32	19
STA.		TO STA.		
FED. ROAD DIST. NO. 1		ILLINOIS		FED. AID PROJECT

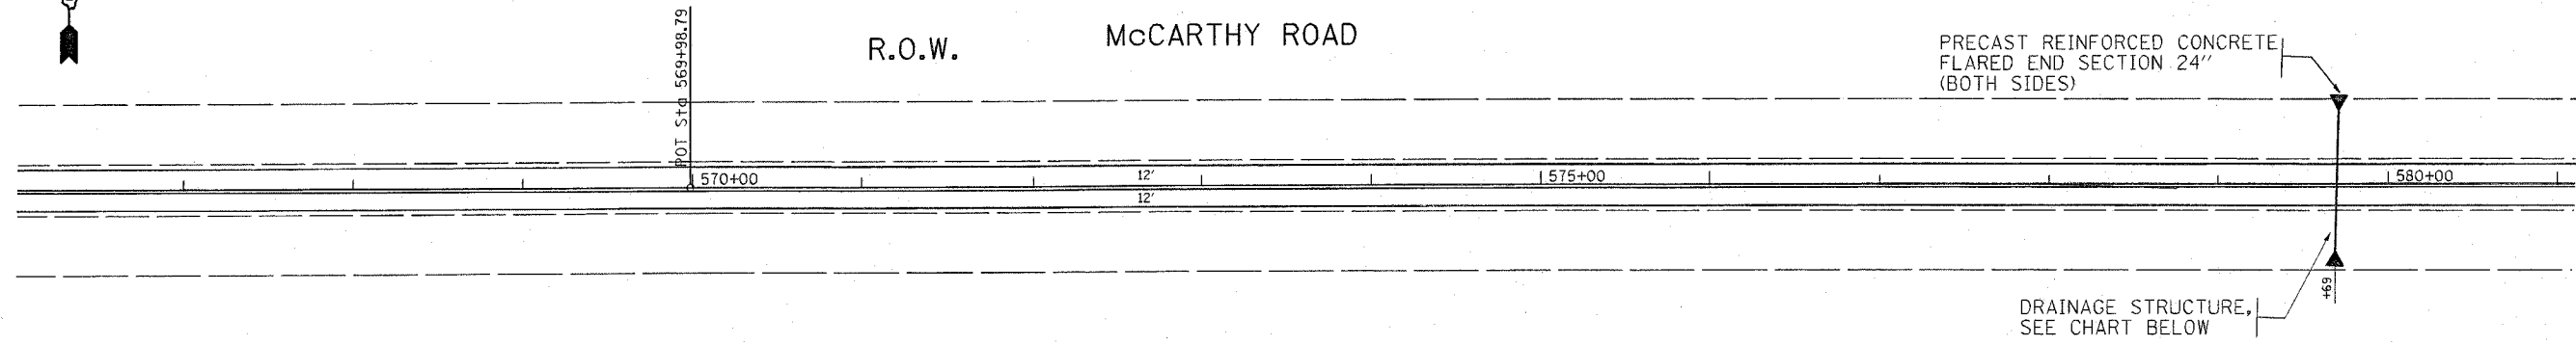

PIPE SIZE	SHAPE	LENGTH	UPSTREAM INV.	DOWNSTREAM INV.
24"	TYPE 2 RCCP 24"	45'	692.20 (SOUTH)	692.05 (NORTH)

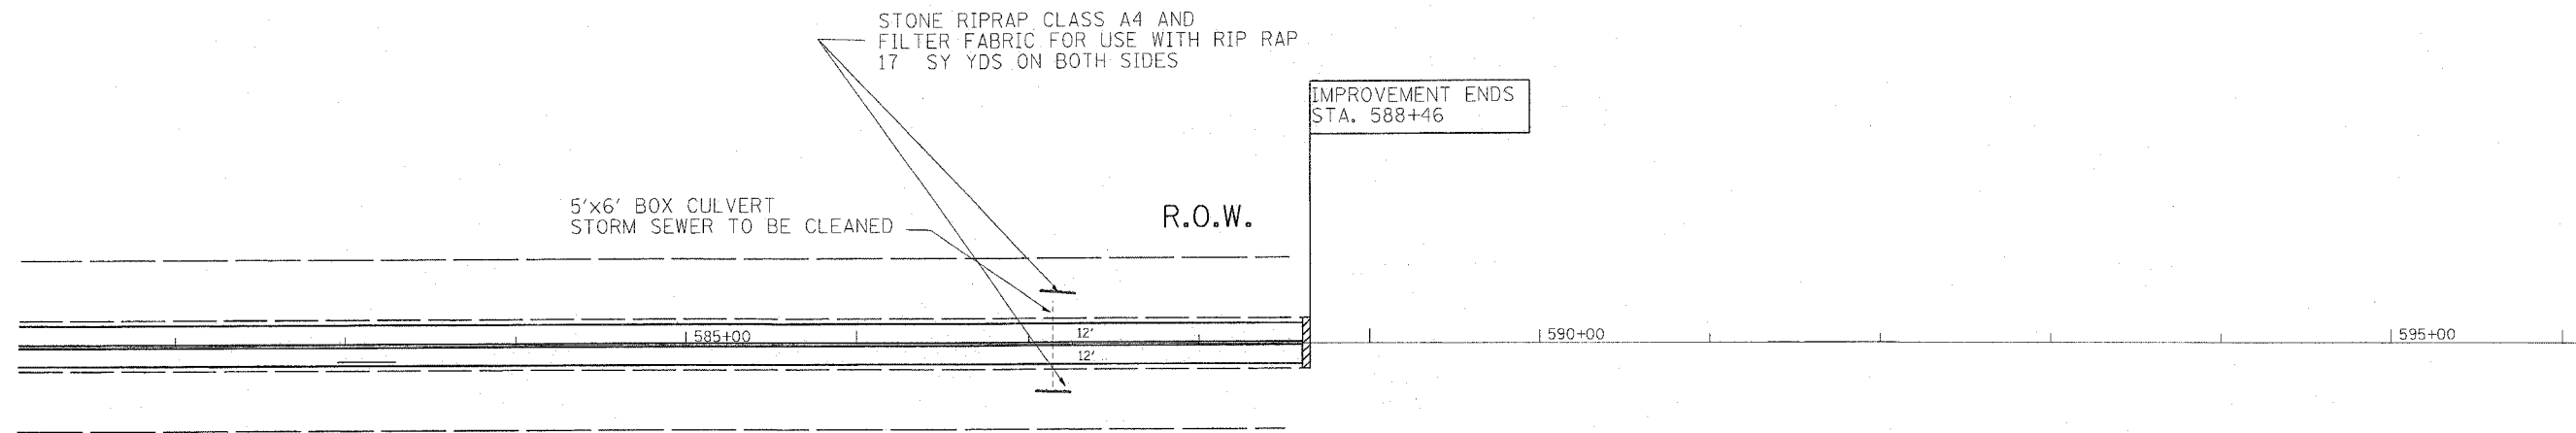

PLOT DATE = 4/5/2006
 PLOT SCALE = 5/8" = 1'-0"
 USER NAME = bockal

REVISIONS	
NAME	DATE

ILLINOIS DEPARTMENT OF TRANSPORTATION

**MCCARTHY ROAD
PROPOSED DRAINAGE PLANS**

SCALE: VERT. _____
 HORIZ. _____
 DATE _____

DRAWN BY _____
 CHECKED BY _____