



F.A. RTE.	SECTION	COUNTY	TOTAL SHEETS	SHEET NO.
1373 00-00058-00-RS		COOK	113	36
STA. 114+25		TO STA. 119+25		
ILLINOIS FED. AID PROJECT				
CONTRACT No: 83861				

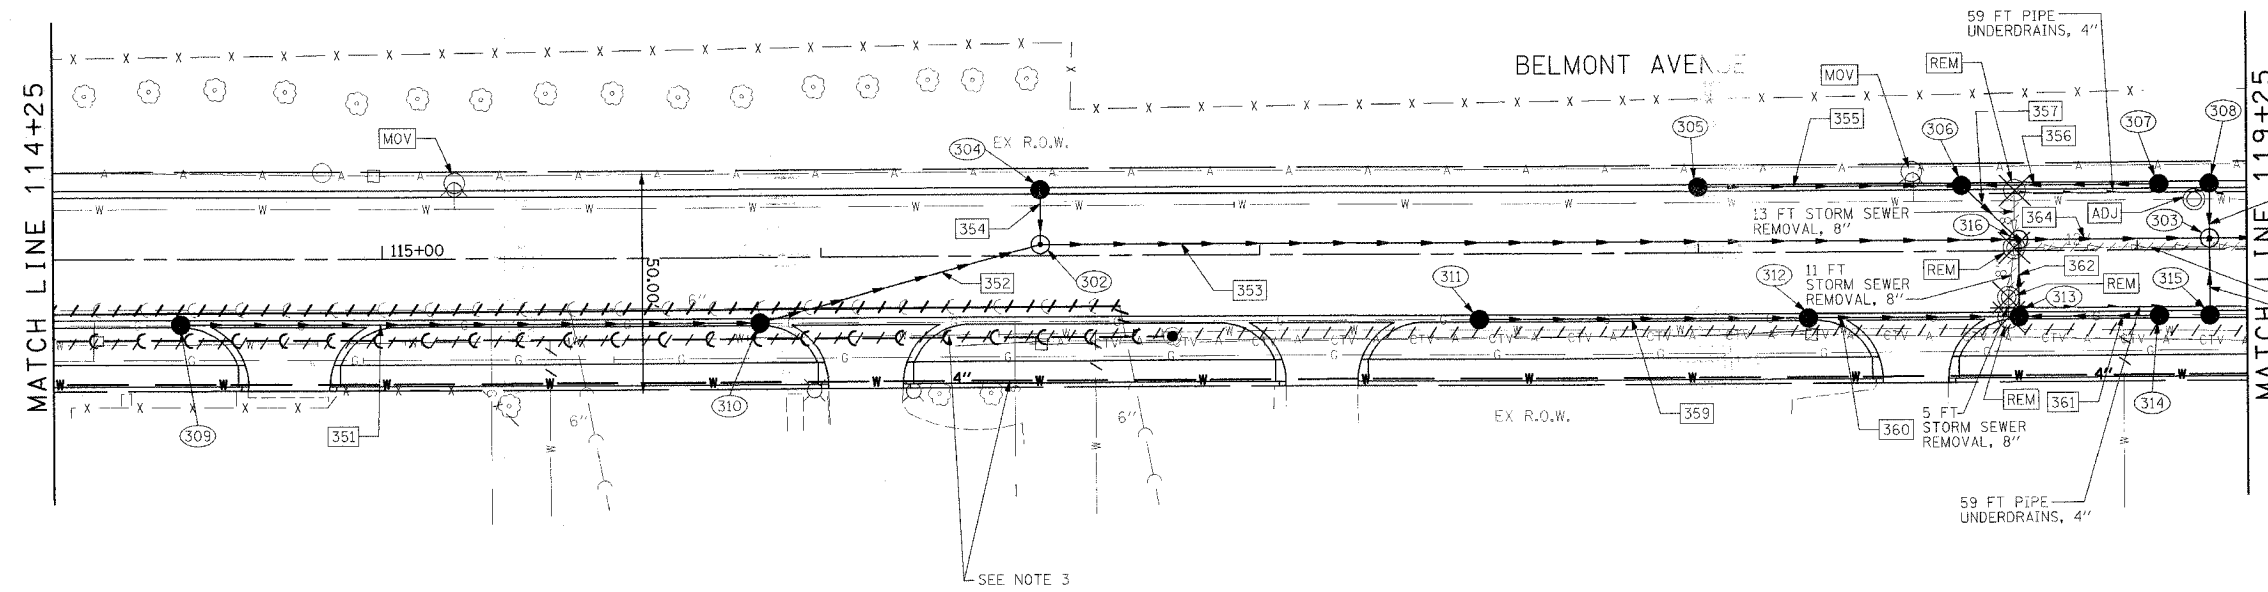

- NOTE
- SEE SHEET 34 FOR DRAINAGE LEGEND.
 - CONTRACTOR TO CONNECT PIPE UNDERDRAINS TO CATCH BASINS AND GROUT IN PLACE. THIS WORK SHALL BE INCLUDED IN THE CONTRACT UNIT PRICE PER FOOT OF PIPE UNDERDRAINS, 4".
 - SEE "LEYDEN TOWNSHIP UTILITY RELOCATION PLAN AND PROFILE" FOR DETAILED INFORMATION ON THE SANITARY SEWER AND WATER MAIN RELOCATIONS AND SANITARY AND WATER SERVICE ADJUSTMENTS.

PLAN

SCALE: 1"=20'

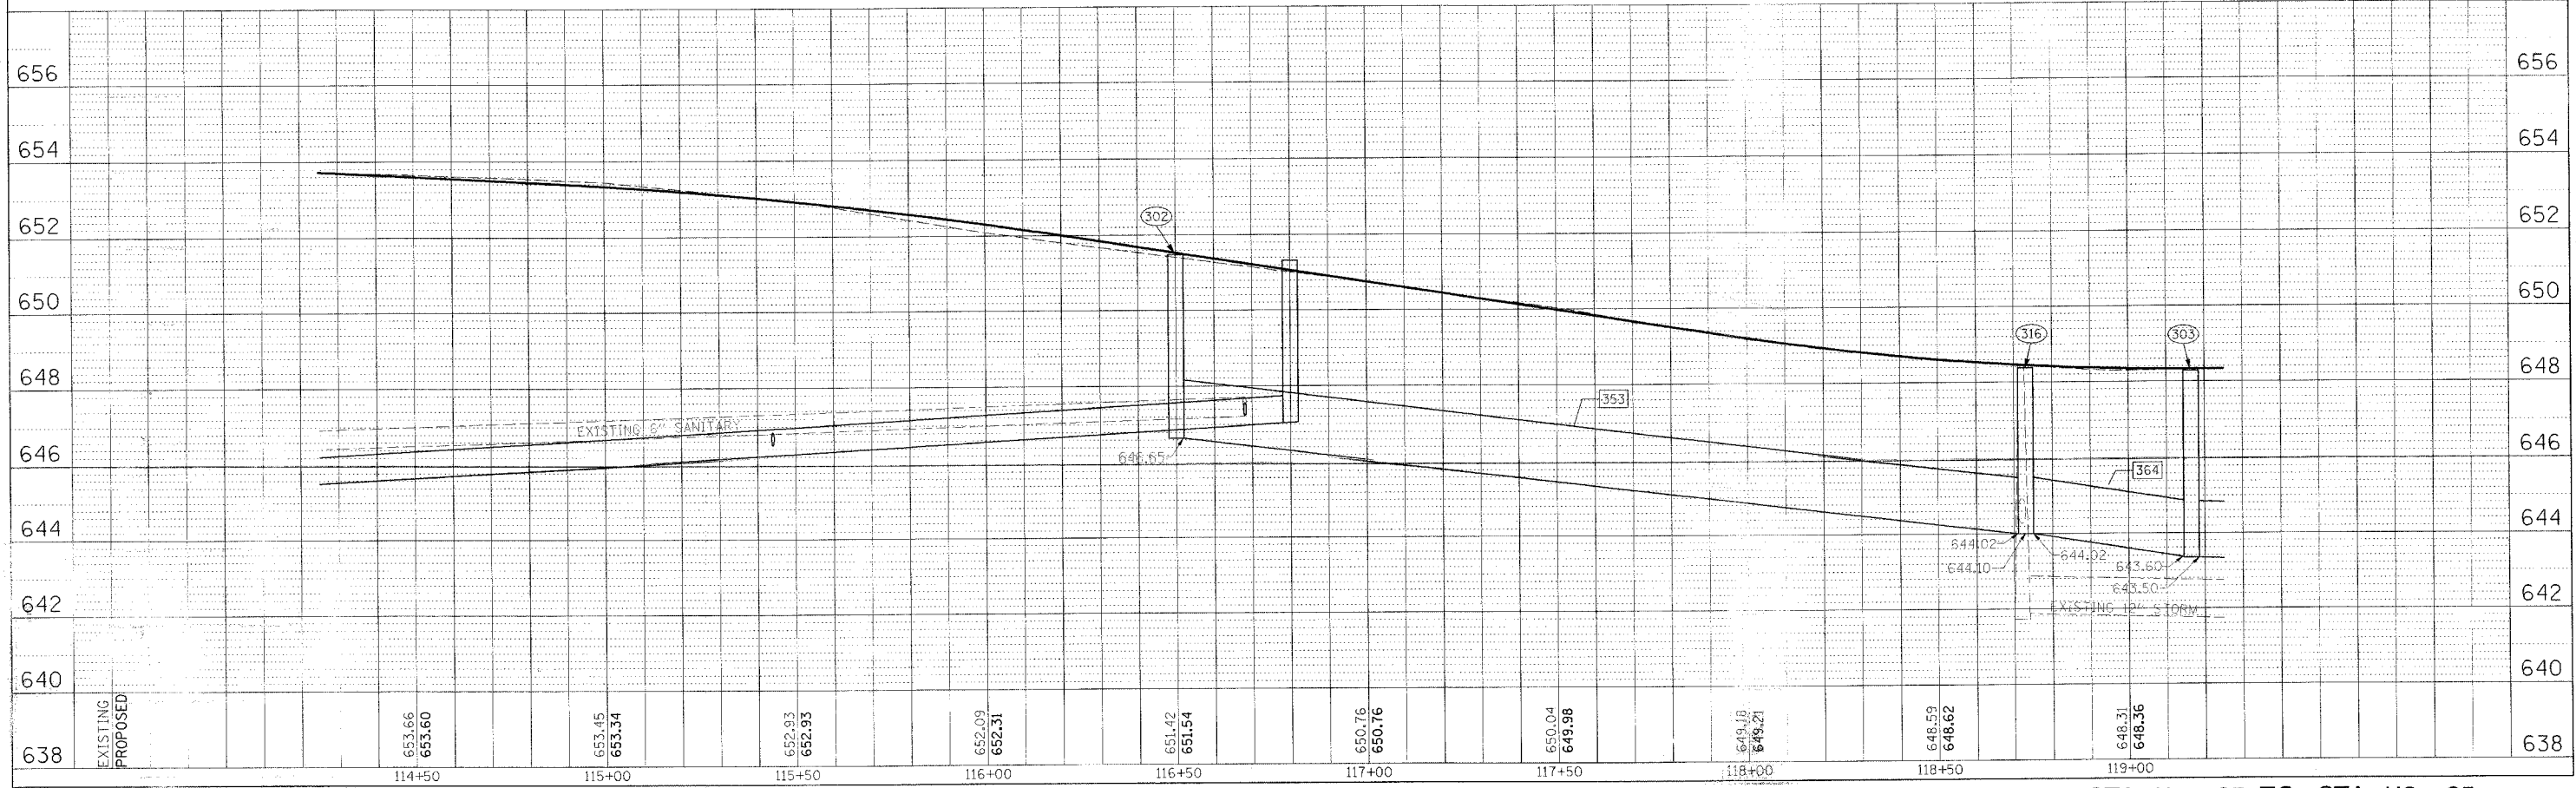

DRAINAGE PLAN AND PROFILE STA. 114+25 TO STA. 119+25

PLAN	DATE
DESIGNED BY	
CHECKED BY	
DATE	

BY	DATE
DESIGNED BY	
CHECKED BY	
DATE	

\\fs114300\plans\sheets\14320\drp\10104.dgn
 11/17/2006 11:57 AM